


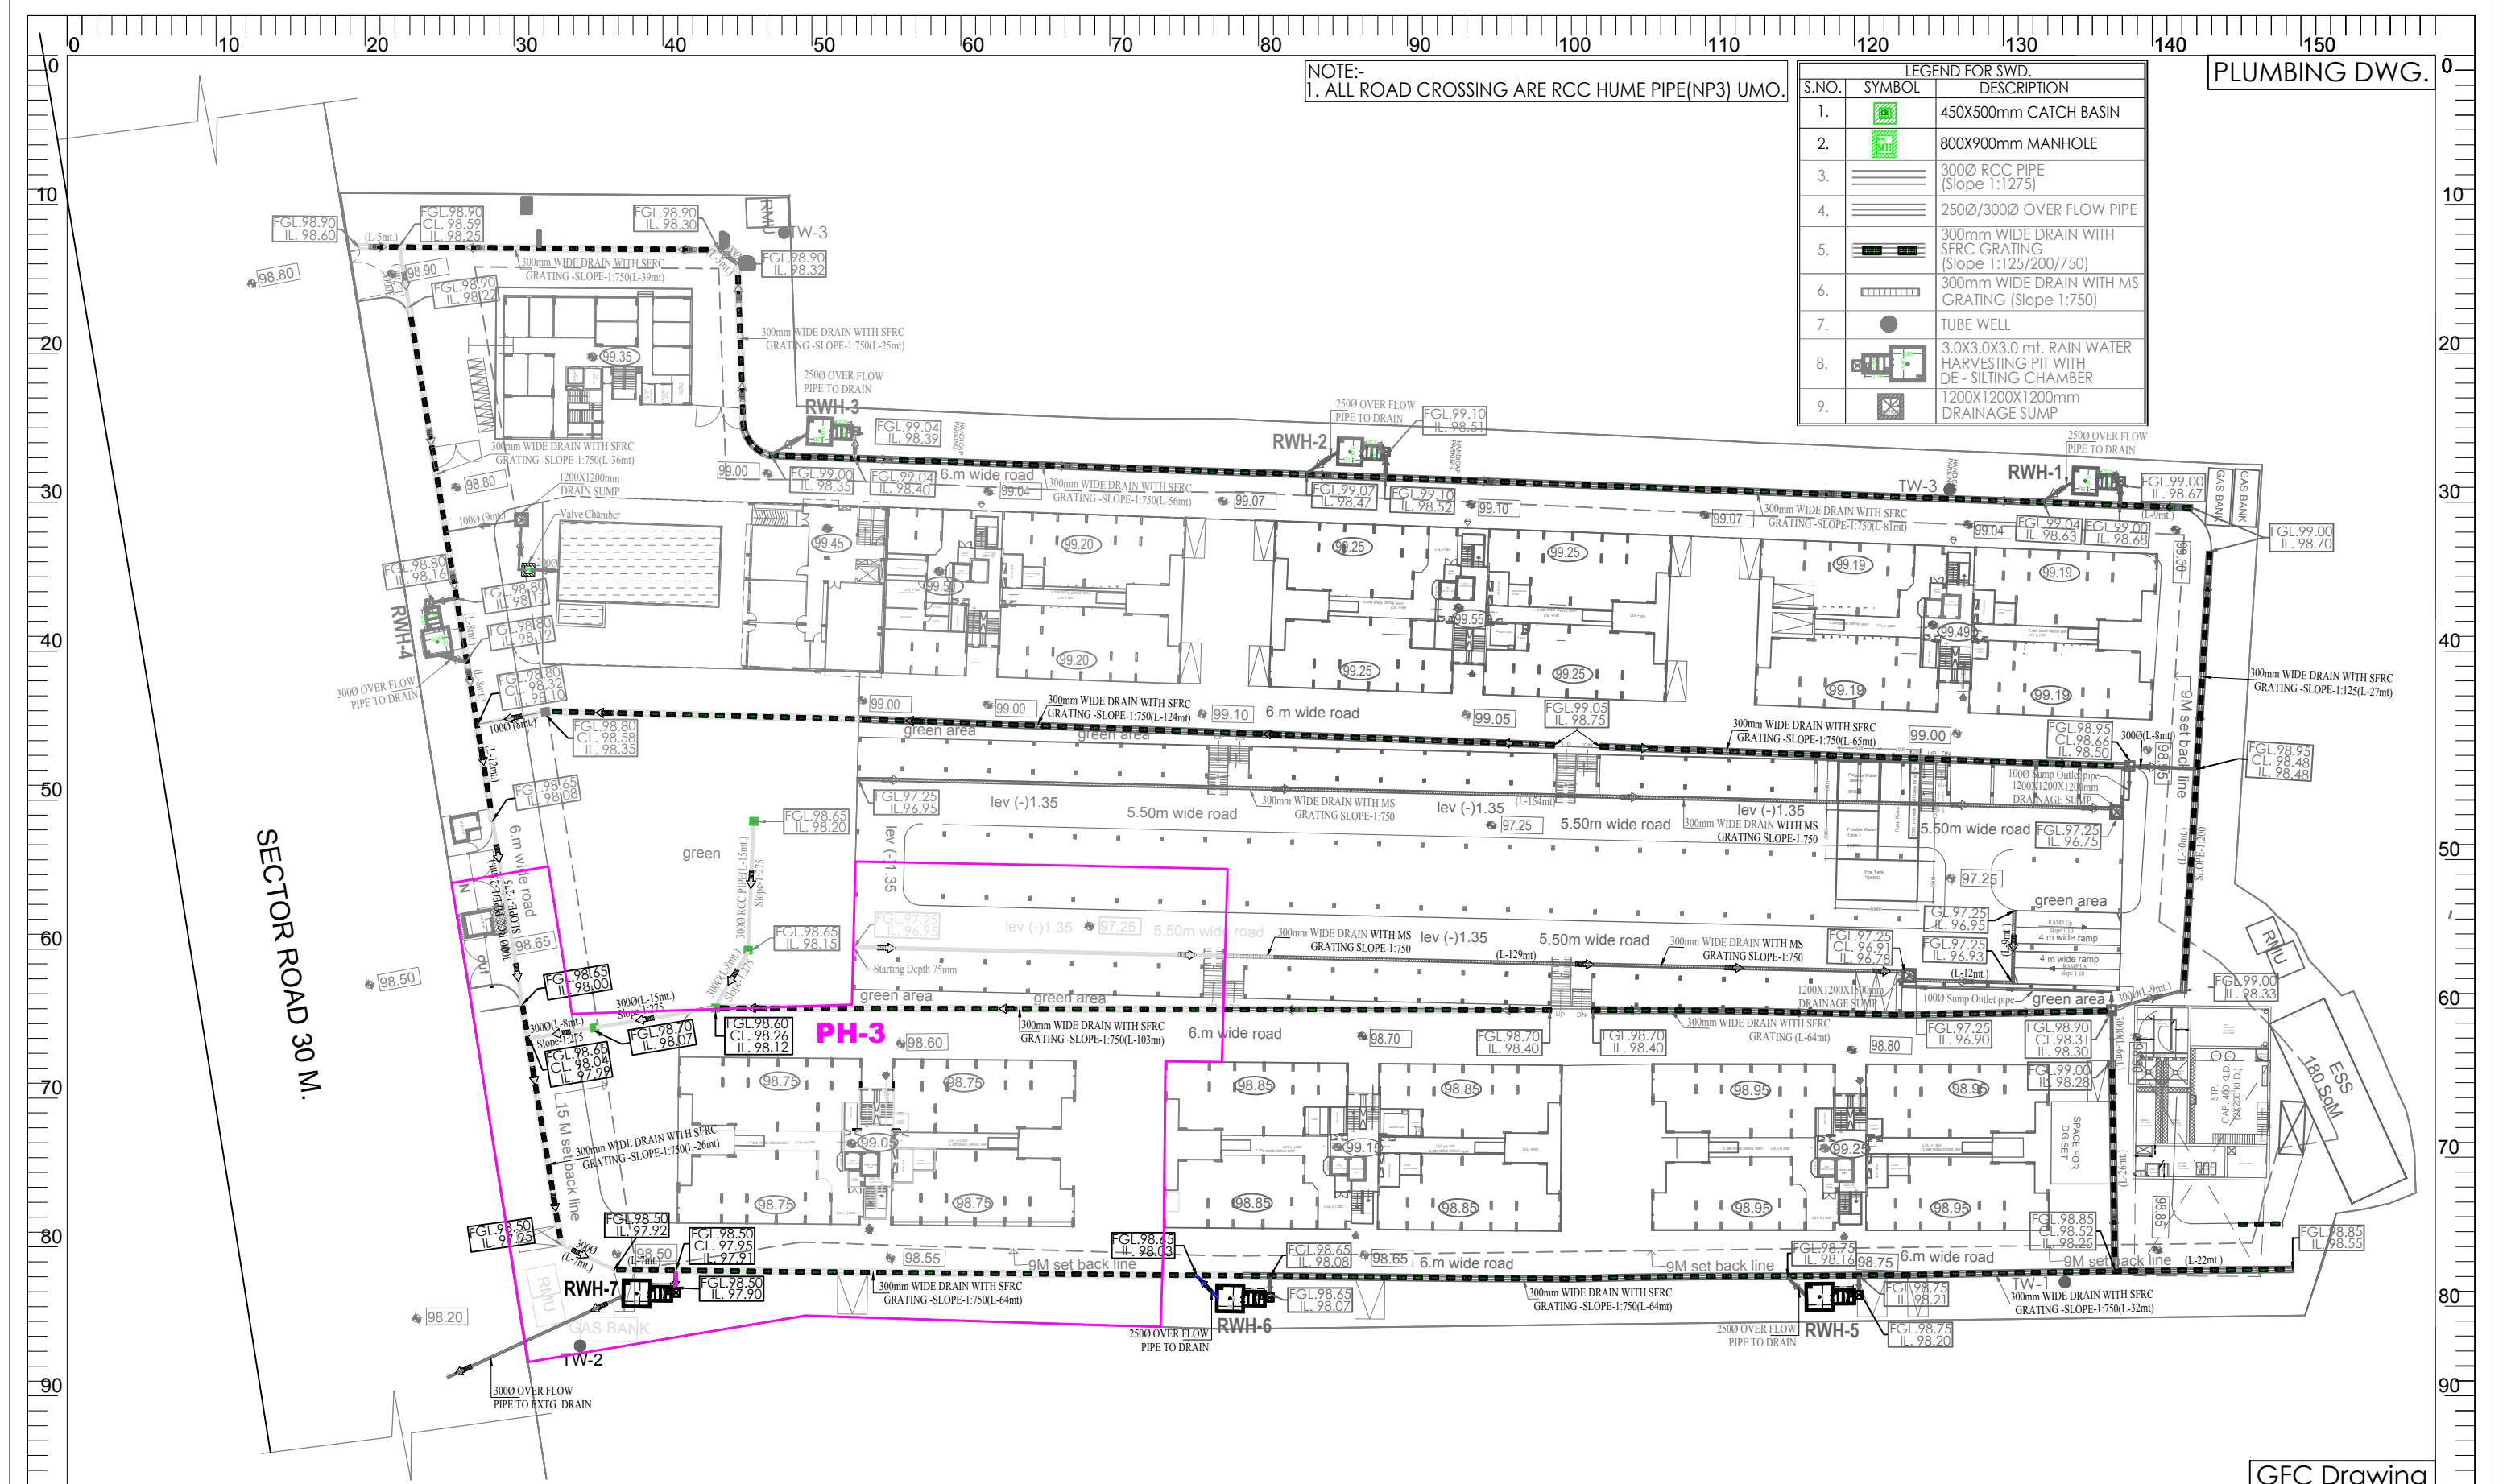

LEGEND FOR SWD.		
S.NO.	SYMBOL	DESCRIPTION
1.		450X500mm CATCH BASIN
2.		800X900mm MANHOLE
3.		300Ø RCC PIPE (Slope 1:1275)
4.		250Ø/300Ø OVER FLOW PIPE
5.		300mm WIDE DRAIN WITH SFR C GRATING (Slope 1:125/200/750)
6.		300mm WIDE DRAIN WITH M GRATING (Slope 1:750)
7.		TUBE WELL
8.		3.0X3.0X3.0 mt. RAIN WATER HARVESTING PIT WITH DE - SILTING CHAMBER
9.		1200X1200X1200mm DRAINAGE SUMP

PLUMBING DWG.

GFC Drawing

PROJECT :
ASHIANA DAKSH

OWNERS NAME
Ashiana Housing Ltd.
304, Southern park, saket District Centre,
Saket New Delhi - 110017
Phone no. 011- 42 65 42 65


Services consultants:-



DRG. TITLE:	Site plan
	Rain Water
	Harvesting Plan

SCALE:

 DATE:



Drawn By

Checked By

Approved By	
-------------	--

Rev.No.	
---------	--

Rev.Date

Remarks
