


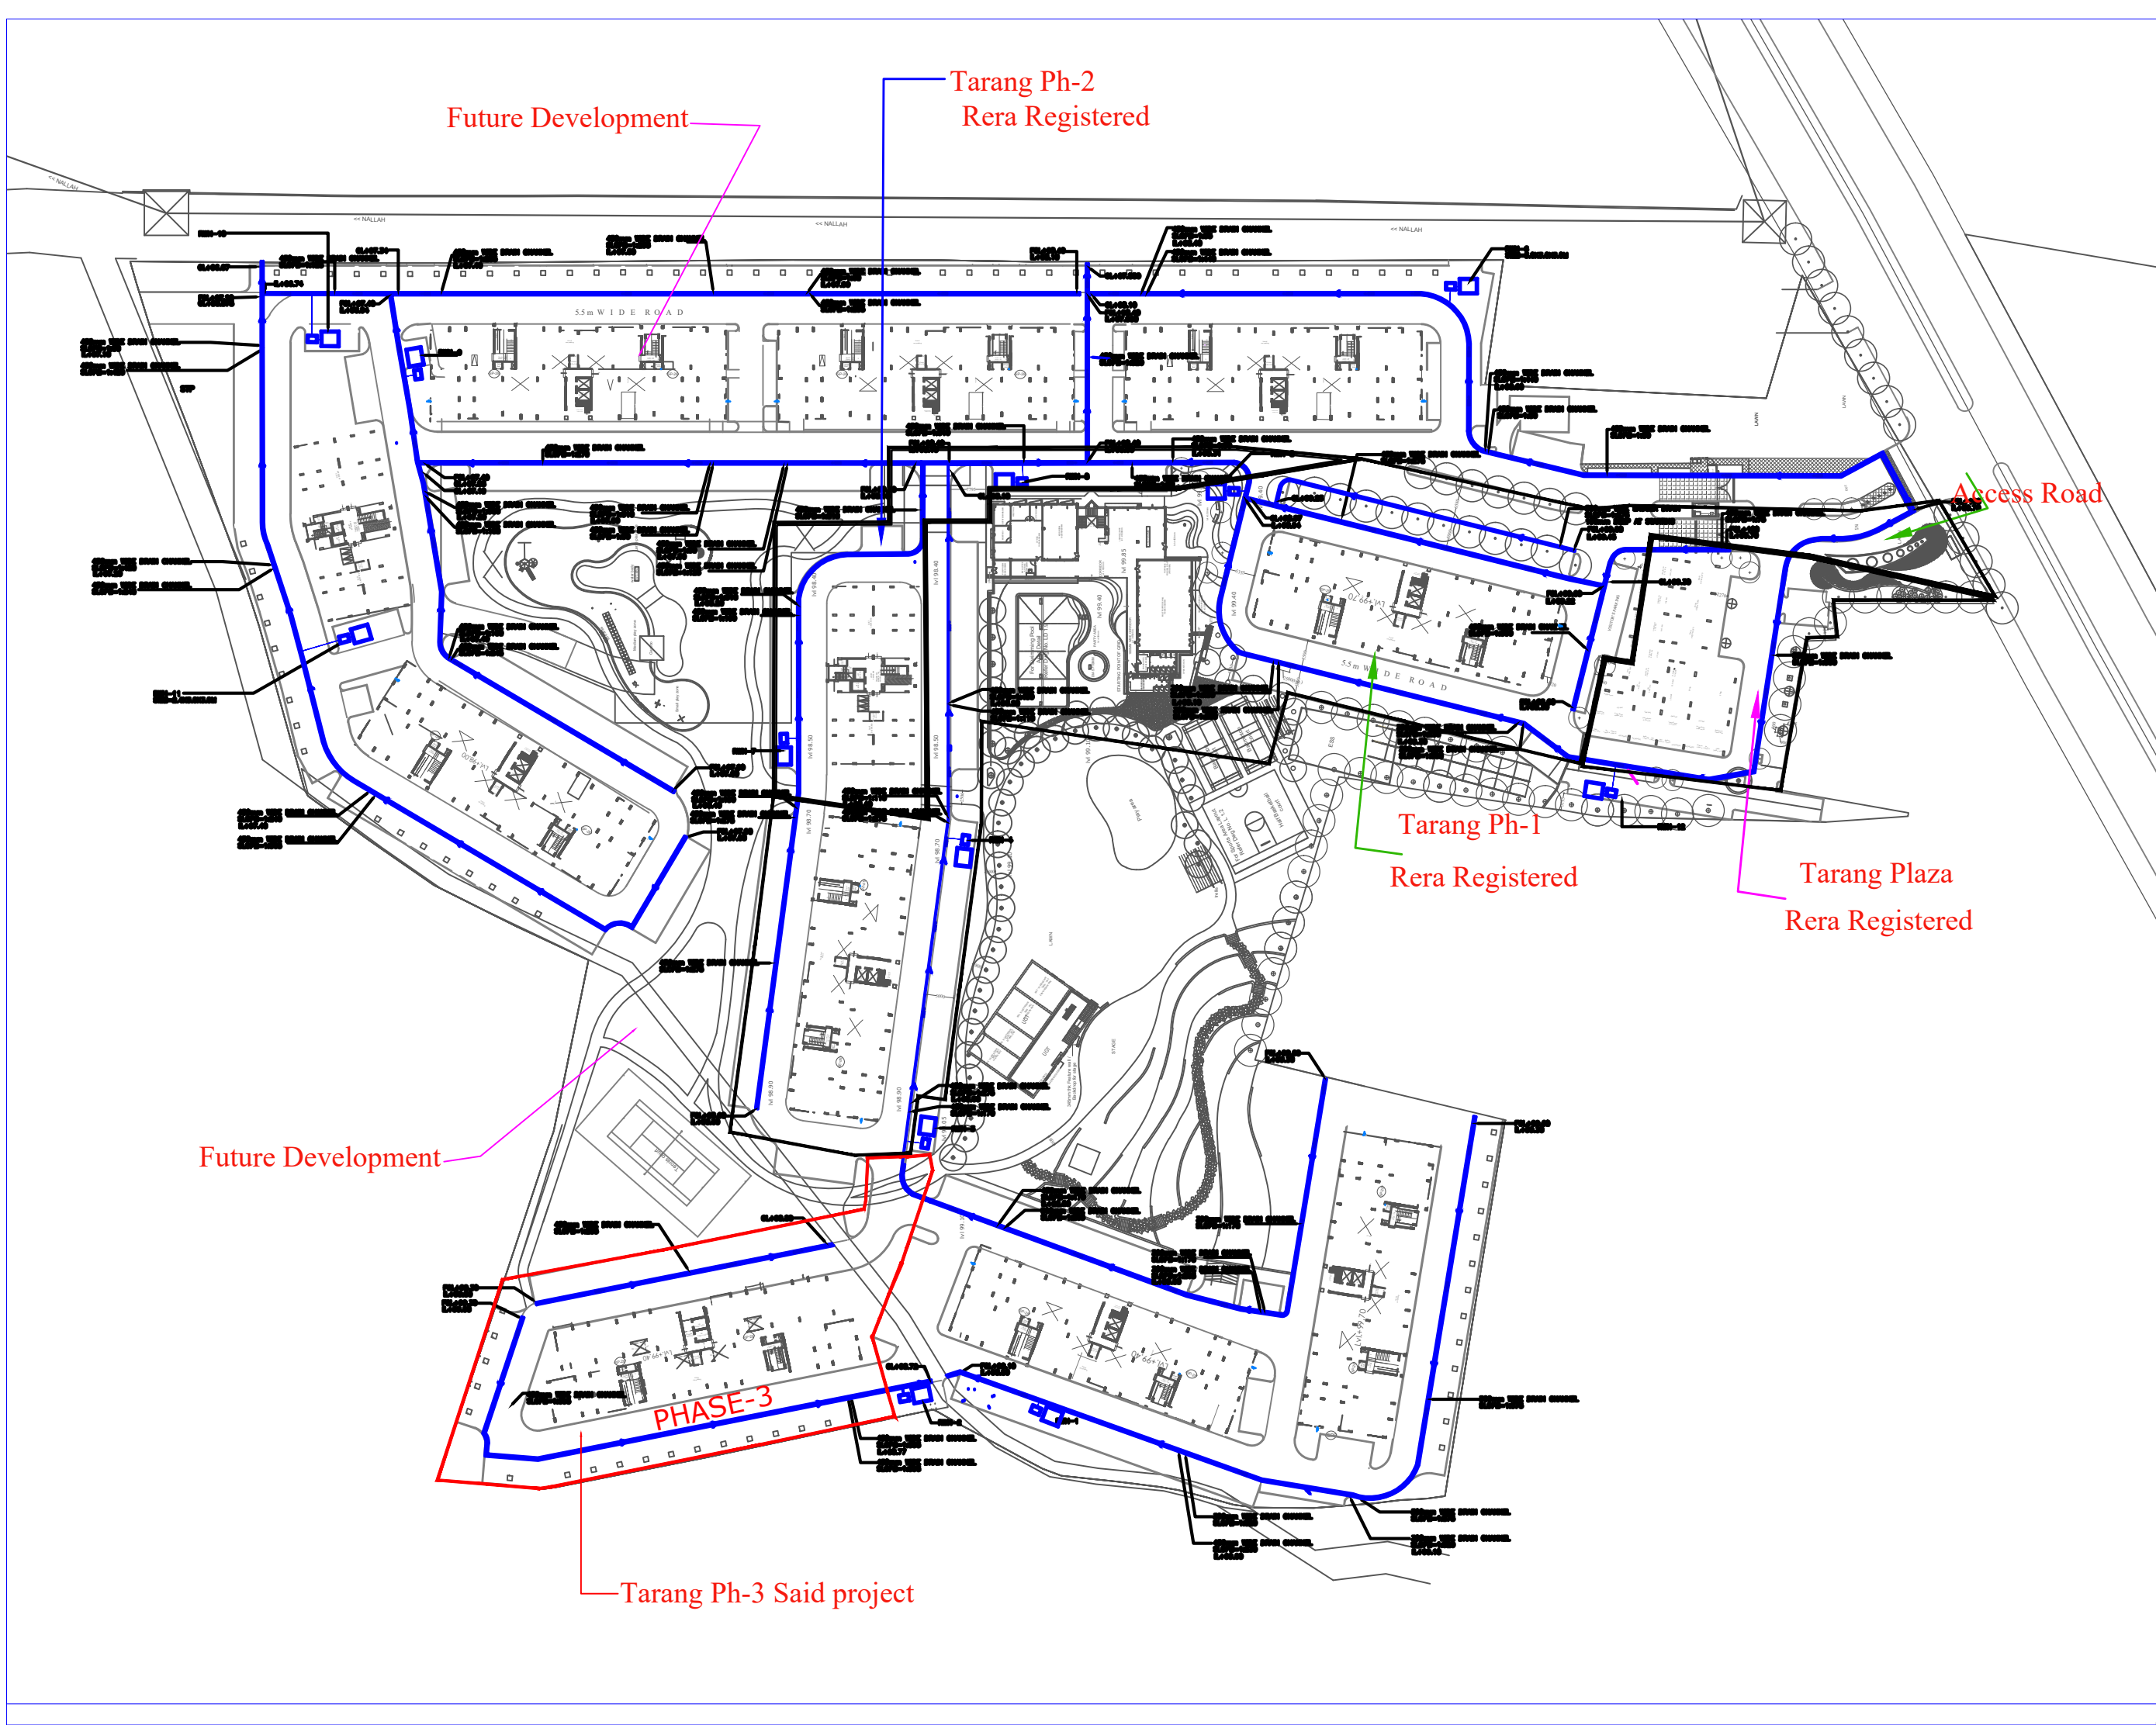

KEY PLAN

NOTES :-

1. ALL DIMENSION ARE IN MM.

2. FOR LEGENDS AND GENERAL NOTES REFER DRAWING 16280-P-A1-0001

3. FOR PLUMBING TYPICAL DETAILS REFER DRAWING 16280-P-A1-0200

LEGEND:-

SYMBOLS	DESCRIPTION
	DRAIN CHANNEL
	FGF
	IL
	CL

R2	06.07.17	ARCH.	ISSUED FOR APPROVAL	DKK	DKT
R1	22.06.17	ARCH.	ISSUED FOR APPROVAL	DKK	DKT
R0	22.12.16	ARCH.	ISSUED FOR APPROVAL	VIK	DKT

Rev	Date	Issued to	Description	By	Chk

The concepts and information contained in this document are the copyright of think BIM Technical Services Pvt. Ltd. Use or copying of the document in whole or in part without the written permission of think BIM Technical Services Pvt. Ltd. constitutes an infringement of copyright. Do not scale drawings. If in doubt, ask

ARCHITECTS :

b.sengupta architect

A305,RANGOLI,ASHIANAVILLAGEBHIWADI.
PH . 09887498263

MEP CONSULTANT :

thinkBIM

DESIGN . CONSTRUCTION . PH

Unit No. 228-236, 2nd Floor
Tower A Spaze i-Tech Park,
Sohna Road, Sector-49,
Gurgaon- 122018 Haryana, India
PH-0124-4069379, 4145060-61

STRUCTURAL CONSULTANT :

Developer:-

ASHIANA HOUSING LTD
Unit no.4 & 5,Plot No.D-2,3rd Floor,
Southern park, saket District Centre,
Saket New Delhi - 110017
Phone no. 011- 42 65 42 65

Title

SITE PLAN
RAIN WATER HARVESTING LOCATION

Discipline	PLUMBING SERVICE	Status	GFC
Designed By	VIK	Checked By	MAS
Project No.	15280	Date	
Drawing No.	16280-P-A0-A-0501	Revision	R2

Approved By	DKT
Scale	1:400 (at A0)