




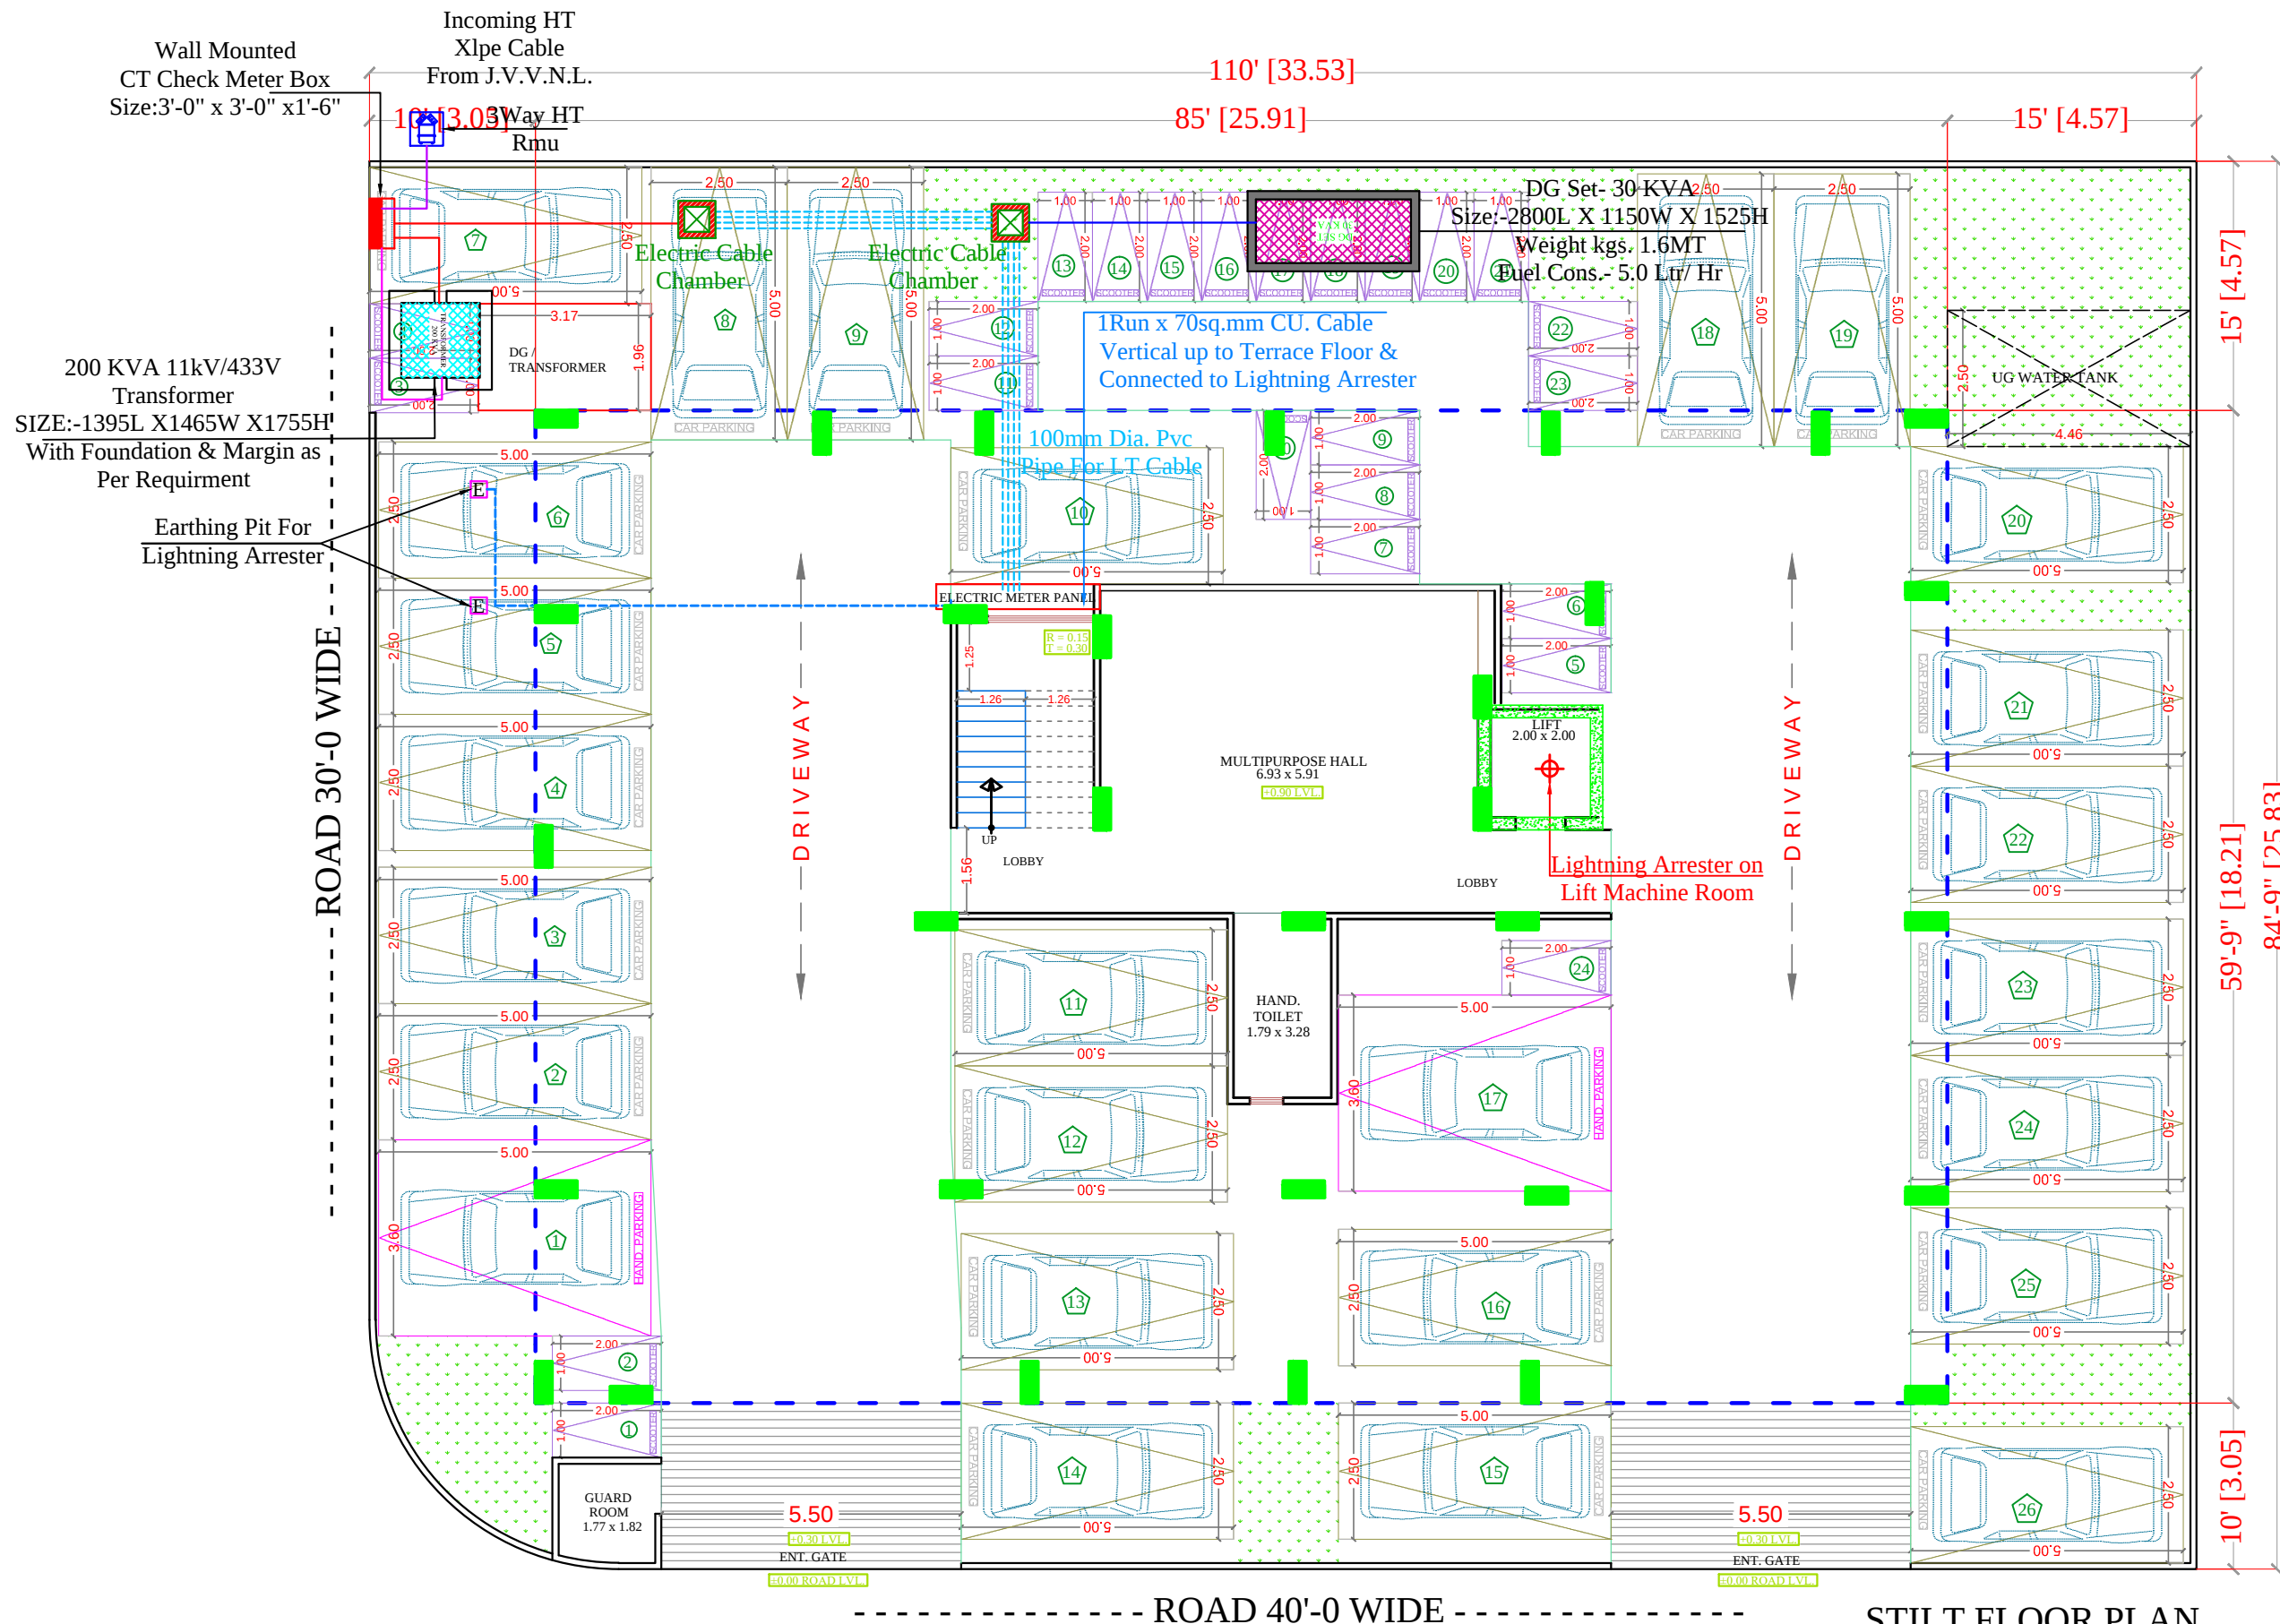

STILT FLOOR PLAN

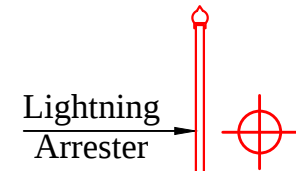

Model: Stormaster – ESE
- 30 (Level 2/Medium
Protection)
(Protection radius - 25M,
Mast Height -2 Mtr)

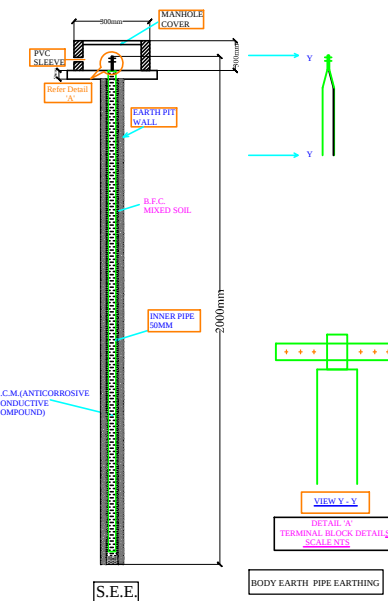

SEAL:-

SPACE CONSULTANT

PLOT-A-173, JAGDAMBA NAGAR, HEERAPURA
POWER HOWER, JAIPUR (RAJ) 302024

ARCHITECT :-

FRANK SQUARE
ARCHITECTURE | PLANNER | DESIGNER
C-49 VIDYA APARTMENT PARAS MARG,
BAPU NAGAR JAIPUR, (RAJ.)
Email-afranksquare@gmail.com
Mobile-9461302542

PROJECT :-

PROPOSED BUILDING AT PLOT
NO.-A-53 & A-54,
NARAYANPURI-A, JAIPUR


DRAWING:

STILT FLOOR
ELECTRIC SUB STATION,
CABLE ROUTE &
LIGHTNING ARRESTER FOR
RERA SUBMISSION PLAN

DATE

SCALE:-

N.T.S.

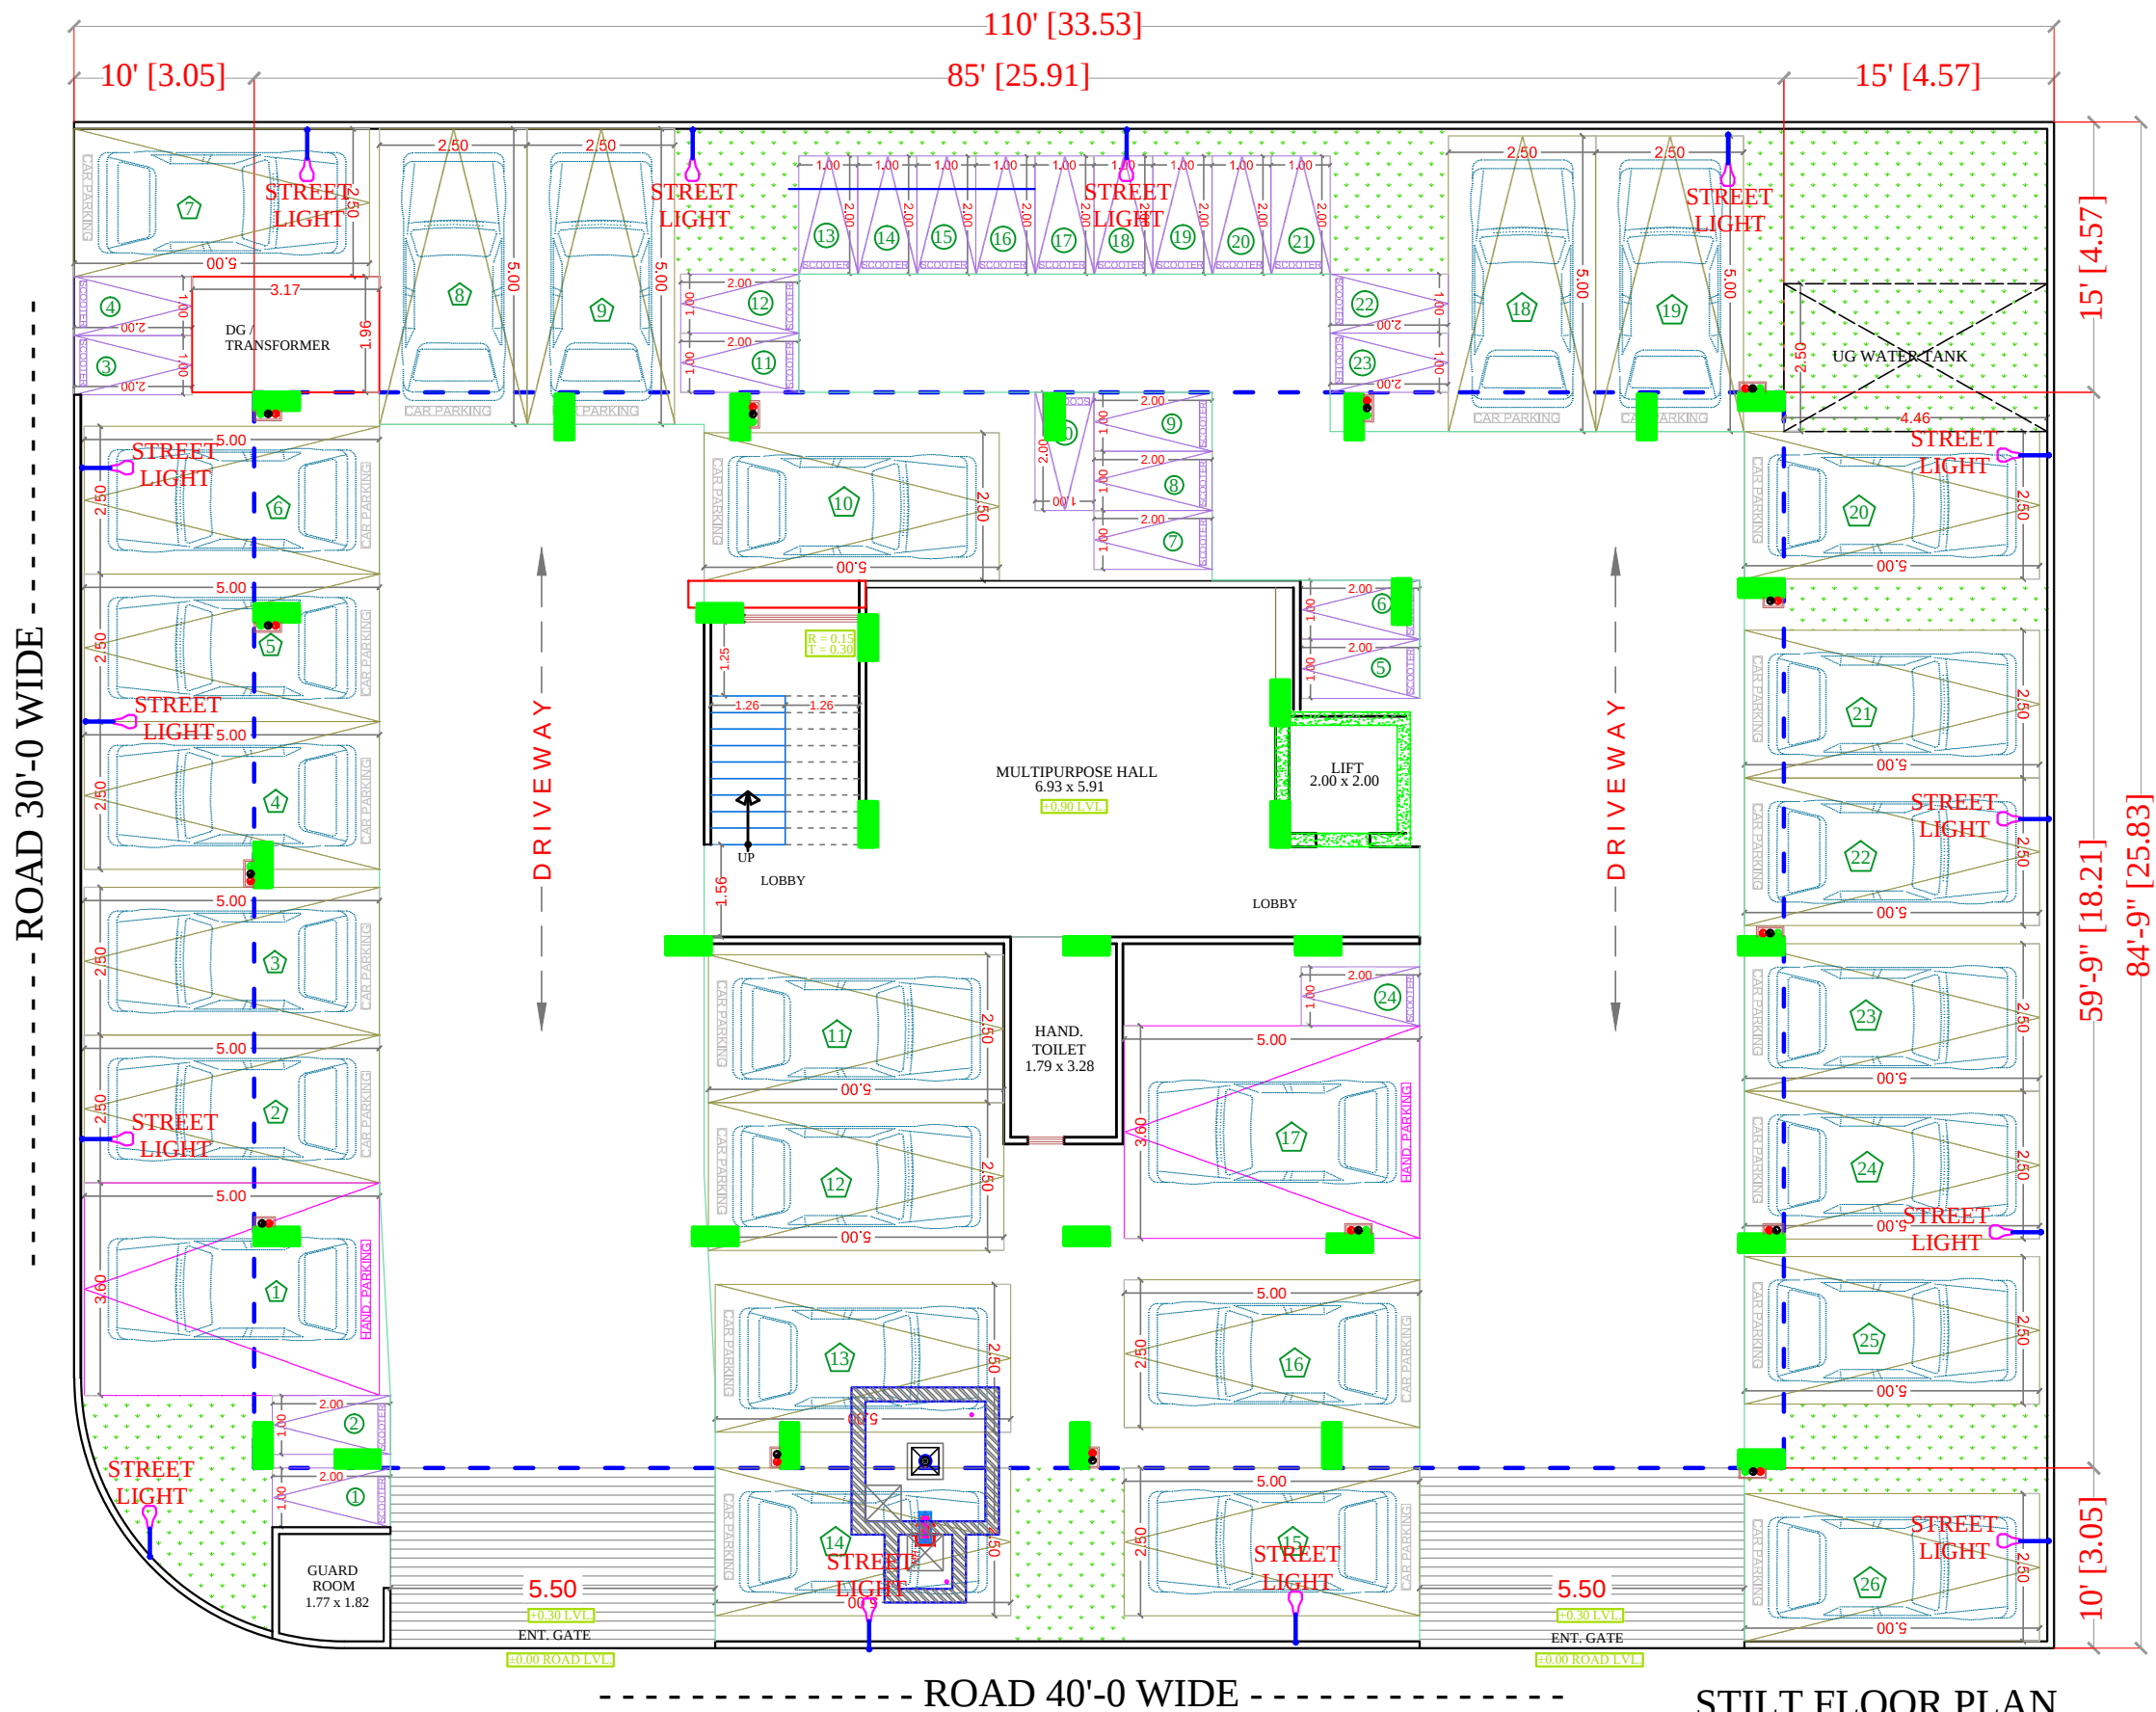

STILT FLOOR PLAN

LEGENDS:

Qty.	I D	Symbol	Description
14	PL		STREET LIGHT

SEAL:-



SPACE CONSULTANT

PLOT-A-173, JAGDAMBA NAGAR, HEERAPURA
POWER HOWER, JAIPUR (RAJ) 302024

ARCHITECT :-



FRANK SQUARE

ARCHITECTURE | PLANNER | DESIGNER
C-49 VIDYA APARTMENT PARAS MARG,
BAPU NAGAR JAIPUR, (RAJ.)
Email-afranksquare@gmail.com
Mobile-9461302542

PROJECT :-

PROPOSED BUILDING AT PLOT
NO.-A-53 & A-54,
NARAYANPURI-A, JAIPUR


DRAWING:

STILT FLOOR
EXTERNAL STREET LIGHT
FOR RERA SUBMISSION PLAN

DATE

SCALE:-

N.T.S.

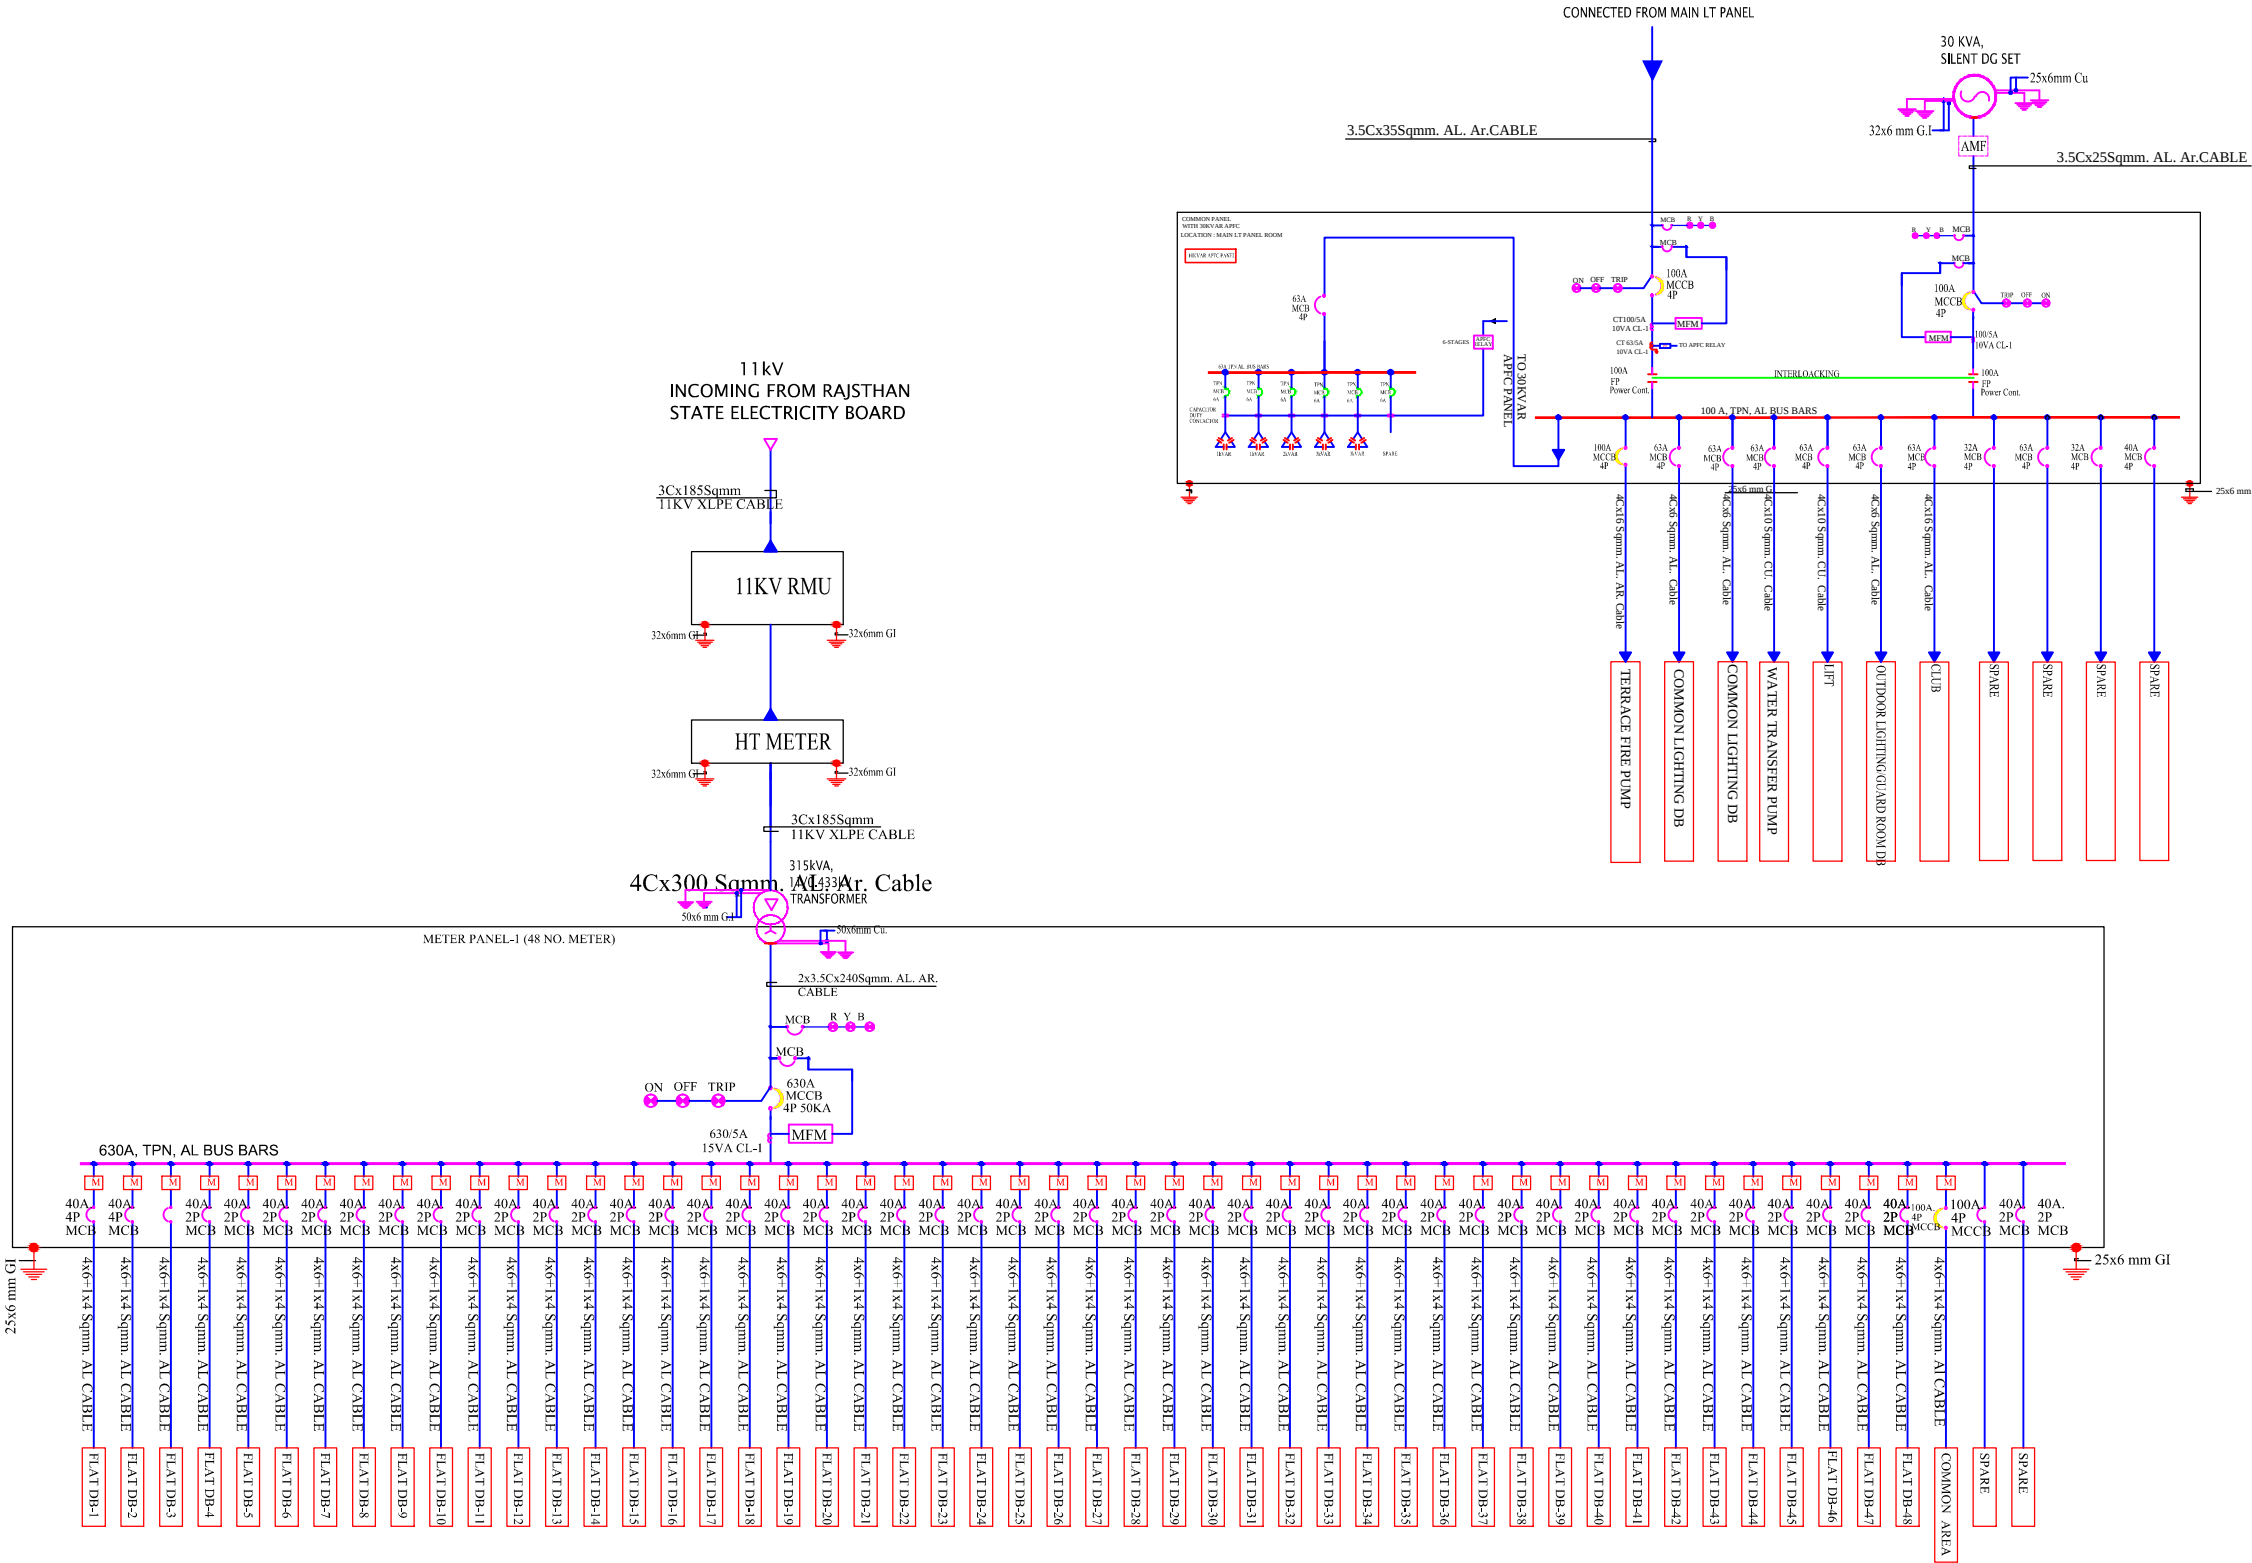

LEGEND	
SYMB.	DESCRIPTION
	AMMETER
	VOLTMETER
	POWER FACTOR METER
	VOLTMETER, AMMETER, FRICTION METER
	FREQUENCY METER
	KILOWATT HOUR METER
	KILOWATT METER
	AMMETER SELECTOR SWITCH
	VOLTMETER SELECTOR SWITCH
	LOCKOUT RELAY
	SUPERVISORY TRIP RELAY
	UNDER VOLTAGE DEVICE
	OVER VOLTAGE DEVICE
	REVERSE POWER PHASE DEVICE
	DIFFERENTIAL PROTECTION RELAY
	OVER CURRENT & EARTH FAULT RELAY
	MULTI FUNCTION RELAY
	ELECTRICAL OPERATED MANUALLY DRAWOUT
	CONTROL FUSE
	CURRENT TRANSFORMER
	TRIVECTOR METER
	INDICATING LAMP
	OVER LOAD RELAY
	POWER CONTACTOR
	POTENTIAL TRANSFORMER
	DUAL SOURCE ELECTRONIC ENERGY METER
	GROUNDING
	MICRO PROCESSOR BASED RELEASE
	ELECTRONIC ENERGY METER
	AIR CIRCUIT BREAKER
	VACUUM CIRCUIT BREAKER
	MINIATURE CIRCUIT BREAKER
	MOULDED CASE CIRCUIT BREAKER
	MOTOR PROTECTION CIRCUIT BREAKER

REVISION - 00	
GENERAL NOTES :	
1. ALL THE DIMENSIONS ON THE DRAWING ARE IN WRITTEN.	
2. ONLY WRITTEN DIMENSIONS ARE TO BE FOLLOWED, DRAWING SHOULD NOT BE SCALED IN ANY CIRCUMSTANCES.	
3. ALL MEASUREMENTS MUST BE CHECKED AND VERIFIED BY THE CONTRACTORS PRIOR TO EXECUTION OF WORK AT THE SITE.	
4. THIS DRAWING IS TO BE READ IN CONJUNCTION WITH ALL RELEVANT STRUCTURAL, ARCHITECTURAL & FACILITY PLANNING DRAWINGS.	
5. ANY DISCREPANCIES MUST BE BROUGHT TO THE NOTICE OF THE ENGINEER IMMEDIATELY & PRIOR TO EXECUTION AT SITE.	
6. CO-ORDINATION WITH SERVICES SUCH AS HVAC, PLUMBING & ELECTRICAL, ETC. IS THE RESPONSIBILITY OF THE CONTRACTORS.	
7. FOR DETAILS, REFER RELEVANT LARGE SCALE DETAIL DRGS. AS INDICATED.	

LIGHTING LEGEND			
SR.NO.	SYMBOL	DESCRIPTION	HEIGHT FROM FFL
1		CEILING TUBELIGHT POINT	CEILING
2		LED CEILING LIGHT POINT	CEILING
3		LED WALL BRACKET LIGHT POINT AT WALL	+7'-4"
4		6A SOCKET WITH SWITCH	+2'-0"
5		GENERAL POINT 16A SOCKET WITH SWITCH	+2'-0"
6		MDF BOX	+5'-0"
7		CEILING ROSE	+7'-4"
8		SWITCH BOARD	+4'-0"
9		EXHAUST FAN	VENT. HT.
10		LIGHT & POWER DISTRIBUTION BOARD	+5'-1"
11		025MM POINT CONDUIT	CEILING
12		025MM POWER CIRCUIT CONDUIT	CEILING FLOORING
13		025MM LIGHT CIRCUIT CONDUIT	CEILING FLOORING
14		CEILING FAN	CEILING

ARCHITECT

THE URBAN SQUARE
ARCHITECT , PLANNER , BPAS
BAPU NAGAR JAIPUR, (RAJ.)
Mobile- 9461302542

PROJECT :-	
PROPOSED BUILDING AT PLOT NO.-A-53 & A-54, NARAYANPURI-A, JAIPUR	
BUILDER/DEVELOPER/CLIENT:-	
DRAWING TITLE:-	
MAIN PANEL SLD	
SUBMITTED FOR :-	
PRELIMINARY	APPROVAL
PROPOSAL	FOR RERA
DATE :- 10.01.2025	NORTH :-
DRAWN :- RAKESH	
APPROVED :- NARESH	
DRAWING NO.:-	SCALE :-

CONSULTANT

AMP INFRA SERVICES
VILLA NO 16. SHUBHASIS GEETA
JAISINGHPURA, BHANKROTA &
CHIMANPURA,JAIPUR 302026
EMAIL ID- ampinfrajr@gmail.com
CONTACT NO. :- 9462866389