
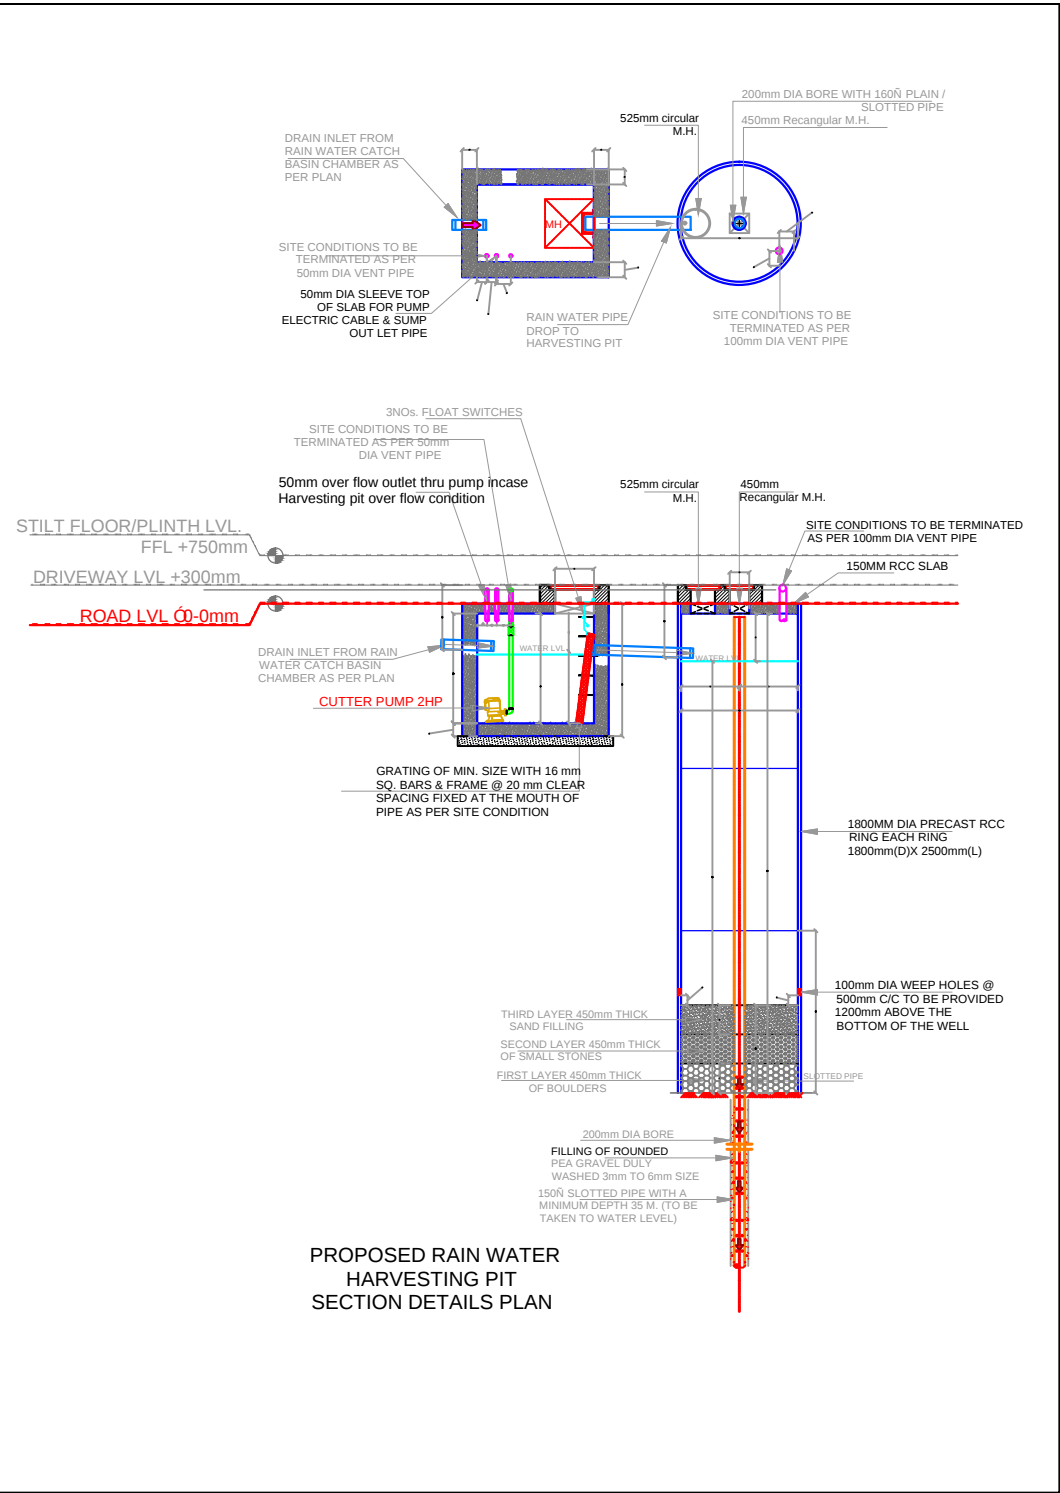


40'-0" WIDE ROAD

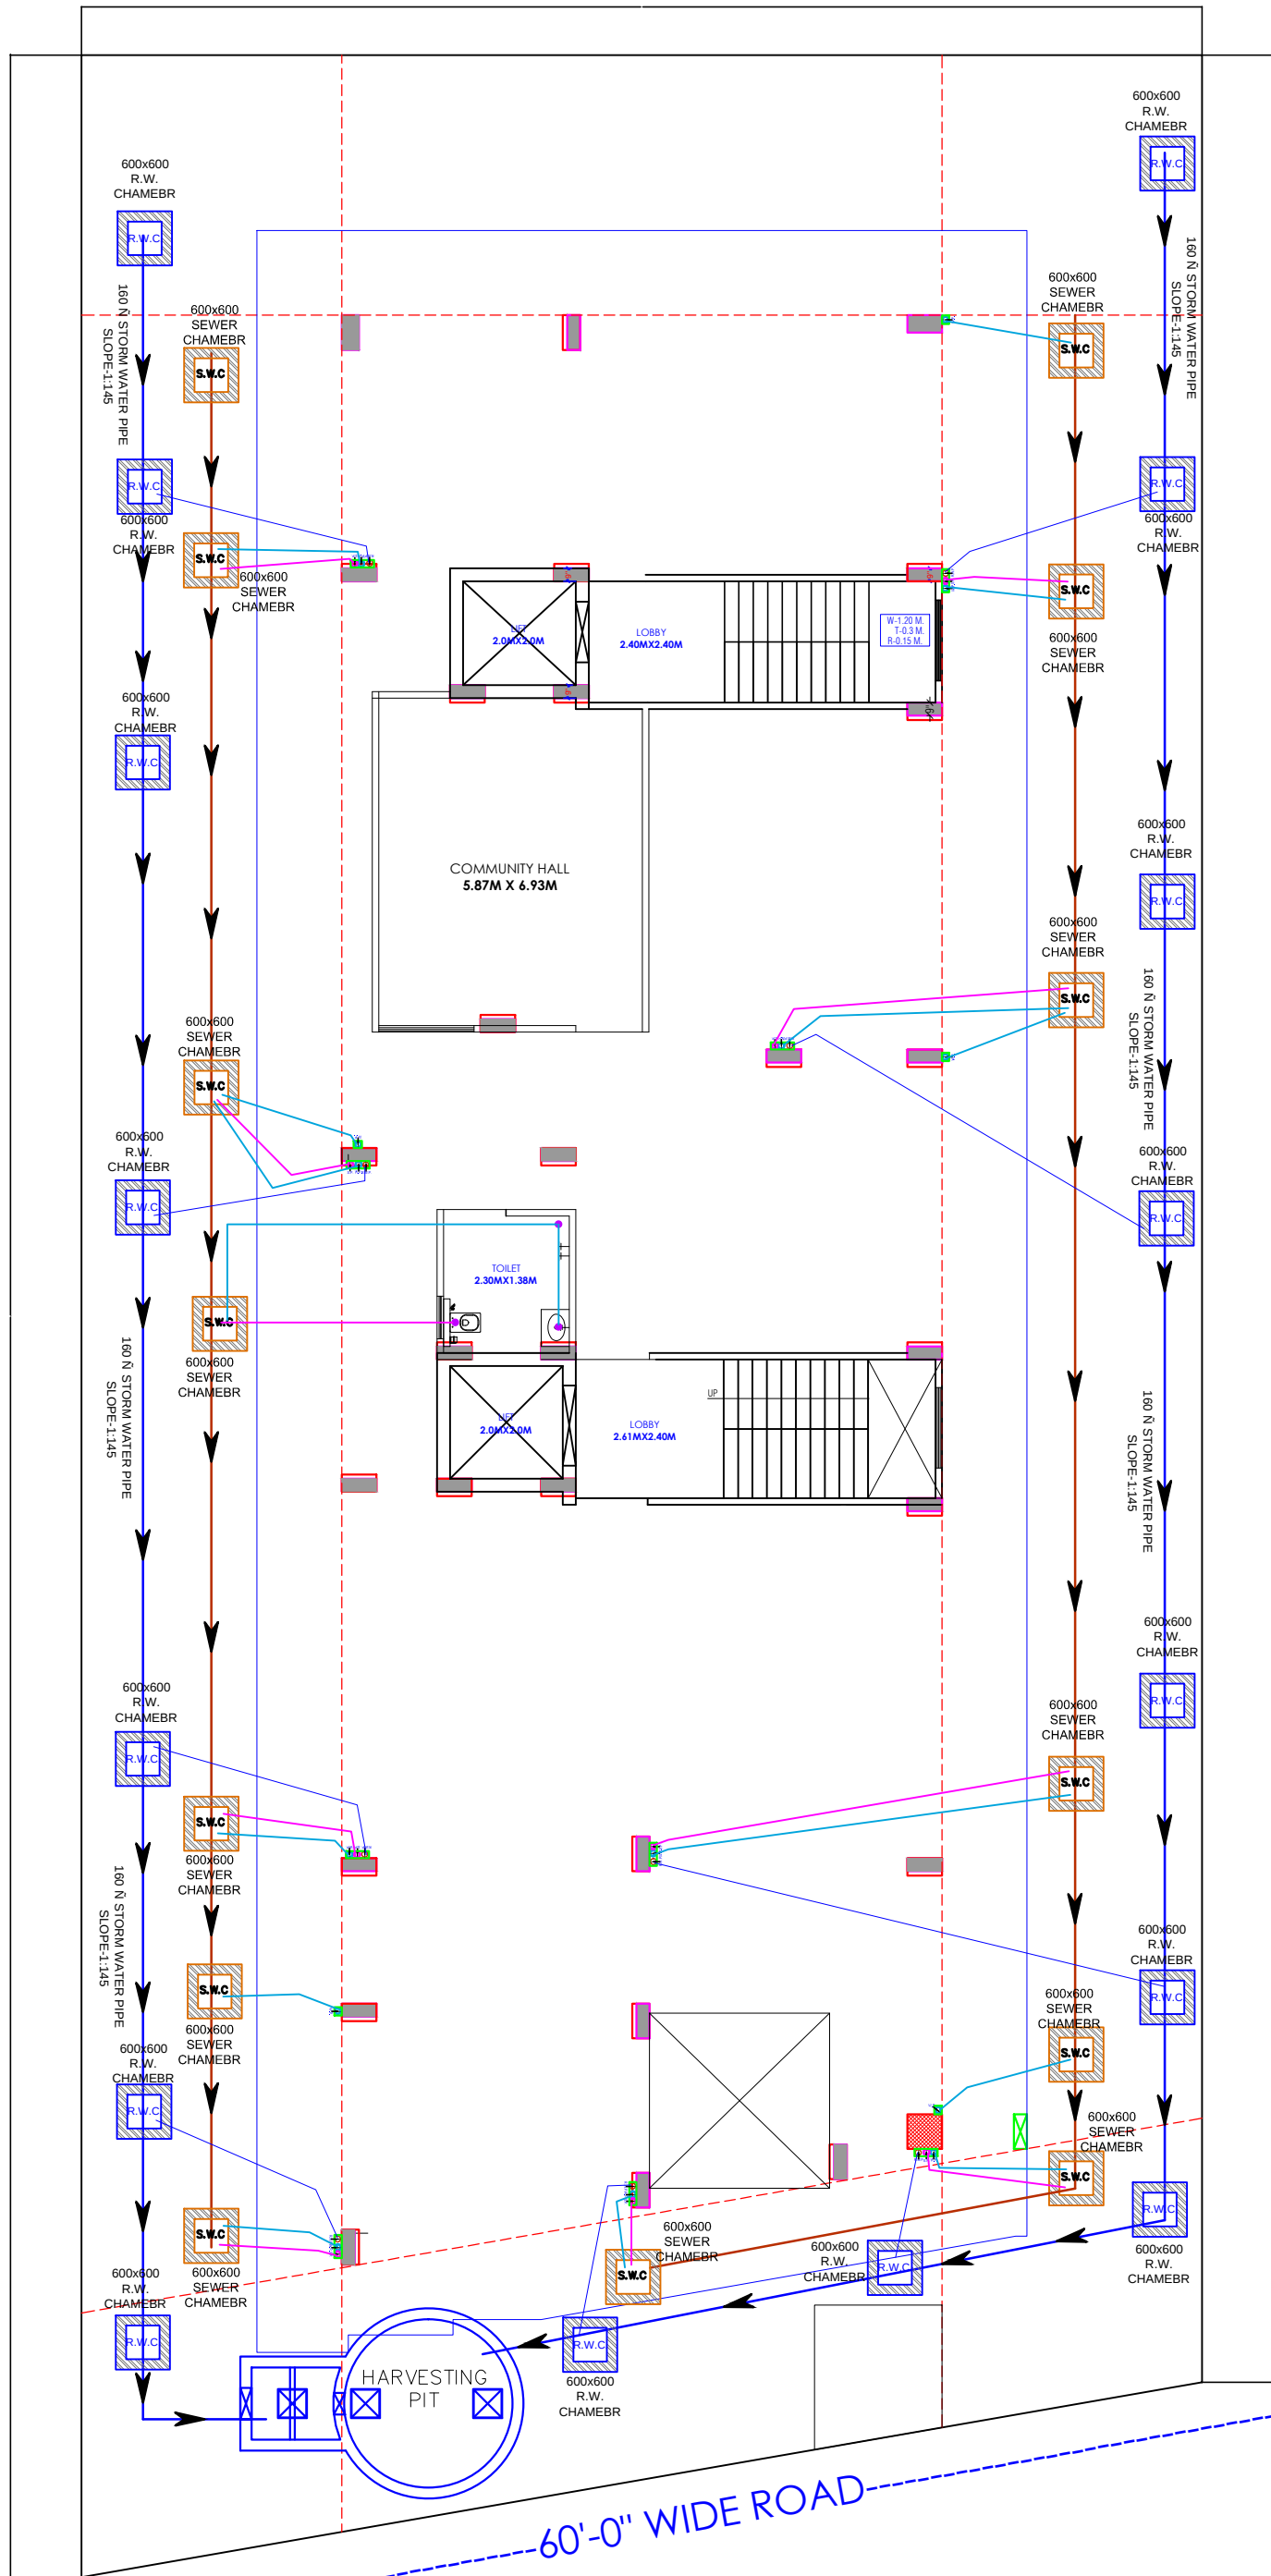

1	RAIN WATER PIPE		
2	WEST WATER PIPE		
3	SOIL WATER PIPE		
4	INSPECTION CHAMBER / GULLY TRAP	2' DEPTH	
5	MAN HOLE	2' DEPTH	
6	ELECTRICAL PIPELINE		

LEGENDS		
S.NO.	SYMBOL	DESCRIPTION
1.		SDR-11 Fresh Water Pipe
2.		SDR-11 Solar Water Pipe
3.		Waste Water Pipe (W.P.)
4.		Soil Pipe (S.P.)
5.		Rain Water Pipe (R.W.P.)
6.		Butter Fly Valve(B.F.V.)
7.		Geyser
8.		RO
9.		Single Lever Diverter
10.		Canceled Valve
11.		Angle Valve
12.		Nahani Trap
13.		P-Trap
14.		Tap
15.		Floor Drain (F.D.)
16.		Plain Tee (P-tee)
17.		Gully Trap (G.T.)
18.		

WARNING

1. This drawing is the sole copyright of Architects **VISTAAR** and should be used for the purpose expressly issued.

GENERAL NOTES

1. All dimensions are in feet and inches.
2. Do not scale this drawing follow written dimensions only.
3. This drawing should be read in conjunction with other architectural and structural drawings.
4. Any discrepancy in the drawing should be immediately brought to the notice of architect.

PROJECT TITLE

CITY PALM
BUILDING AT PLOT-E-84,JAGDAMBA
NAGAR-E,JAIPUR

DRAWING TITLE

.SANITATION(STORM WATER DRAINAGE,
SEWERAGE,STP,SOLID WATER DISPOSAL) AND
RAIN WATER HARVESTING PLAN

ARCHITECTS :

**VISTAAR ARCHITECTS &
PLANNERS**

Architects :: Interior Designers
B-2/12, Chitrkoot scheme,
main Gandhi Path,Opp mall of jaipur,Jaipur
PH.- 0141-4116461,09001010366


DRN.	DATE	REV.	NORTH
MANU KUMAWAT	23-06-2023		
SCALE	JOB NO.		
N.T.S			



For R K Builders & Developers
B. Tech. (Mechanical)
Proprietor

Krishna
KRISHNA KUMAR
B. Tech. (Mechanical)
M.E.P Consultant

40'-0" WIDE ROAD

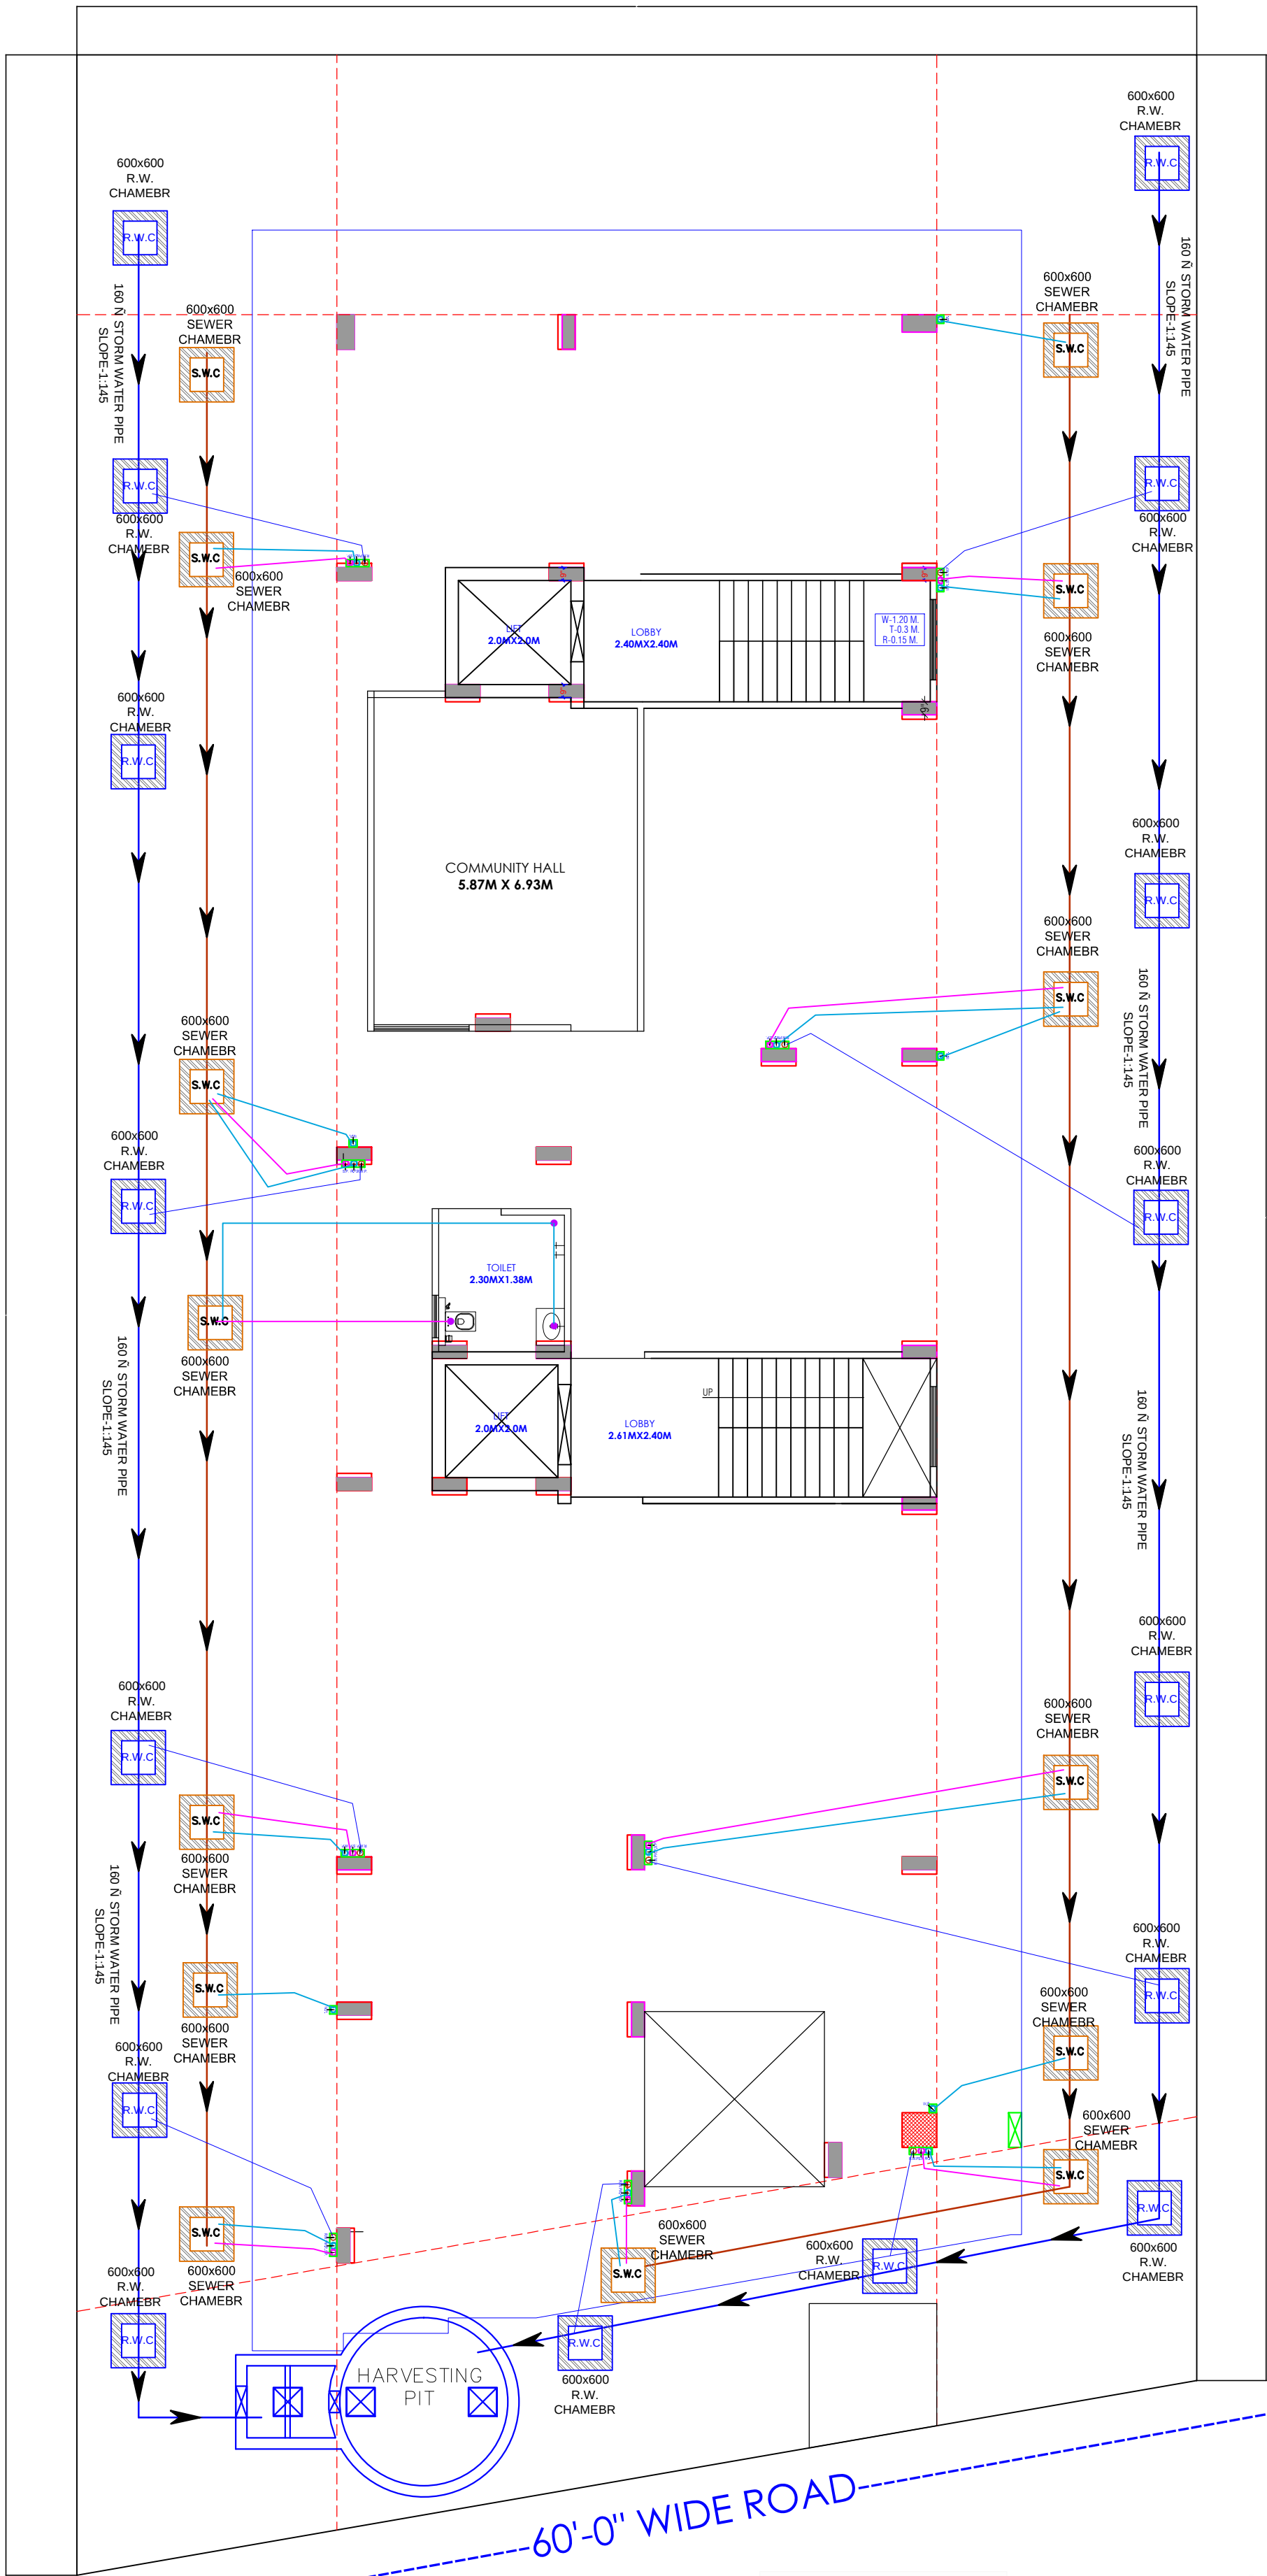

①	RAIN WATER PIPE		
②	WEST WATER PIPE		
③	SOIL WATER PIPE		
④		INSPECTION CHAMBER / GULLY TRAP	2'6" DEPTH
⑤		MAN HOLE	2'6" DEPTH
⑥		ELECTRICAL PIPELINE	

LEGENDS		
S.NO.	SYMBOL	DESCRIPTION
1.		SDR-11 Fresh Water Pipe
2.		SDR-11 Solar Water Pipe
3.		Waste Water Pipe (W.P.)
4.		Soil Pipe (S.P.)
5.		Rain Water Pipe (R.W.P.)
6.		Butter Fly Valve (B.F.V.)
7.		Geyser
8.		RO
9.		Single Lever Diverter
10.		Concealed Valve
11.		Angle Valve
12.		Nahani Trap
13.		P-Trap
14.		Tap
15.		Floor Drain (F.D.)
16.		Plain Tee (P-tee)
17.		Gully Trap (G.T.)
18.		

WARNING

1. This drawing is the sole copyright of Architects VISTAAR and should be used for the purpose expressly issued.

GENERAL NOTES

1. All dimensions are in feet and inches.
2. Do not scale this drawing follow written dimensions only.
3. This drawing should be read in conjunction with other architectural and structural drawings.
4. Any discrepancy in the drawing should be immediately brought to the notice of architect.

PROJECT TITLE

CITY PALM
BUILDING AT PLOT-E-84,JAGDAMBA
NAGAR-E,JAIPUR

DRAWING TITLE

STILT FLOOR DRAINAGE PLAN

ARCHITECTS :

VISTAAR ARCHITECTS &
PLANNERS

Architects :: Interior Designers
B-2/12, Chitrkoot scheme,
main Gandhi Path, Opp mall of jaipur,Jaipur
PH. - 0141-4116461,09001010366

PATH :-

DRN.

DATE

REV.

NORTH


MANOJ
KUMAWAT

23-06-2023

SCALE

JOB NO.

N.T.S

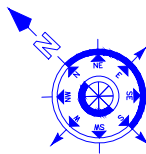

For R K Builders & Developers
B. Tech. (Mechanical)
M.E.P Consultant
Proprietor

Krishna
KRISHNA KUMAR
B. Tech. (Mechanical)
M.E.P Consultant