



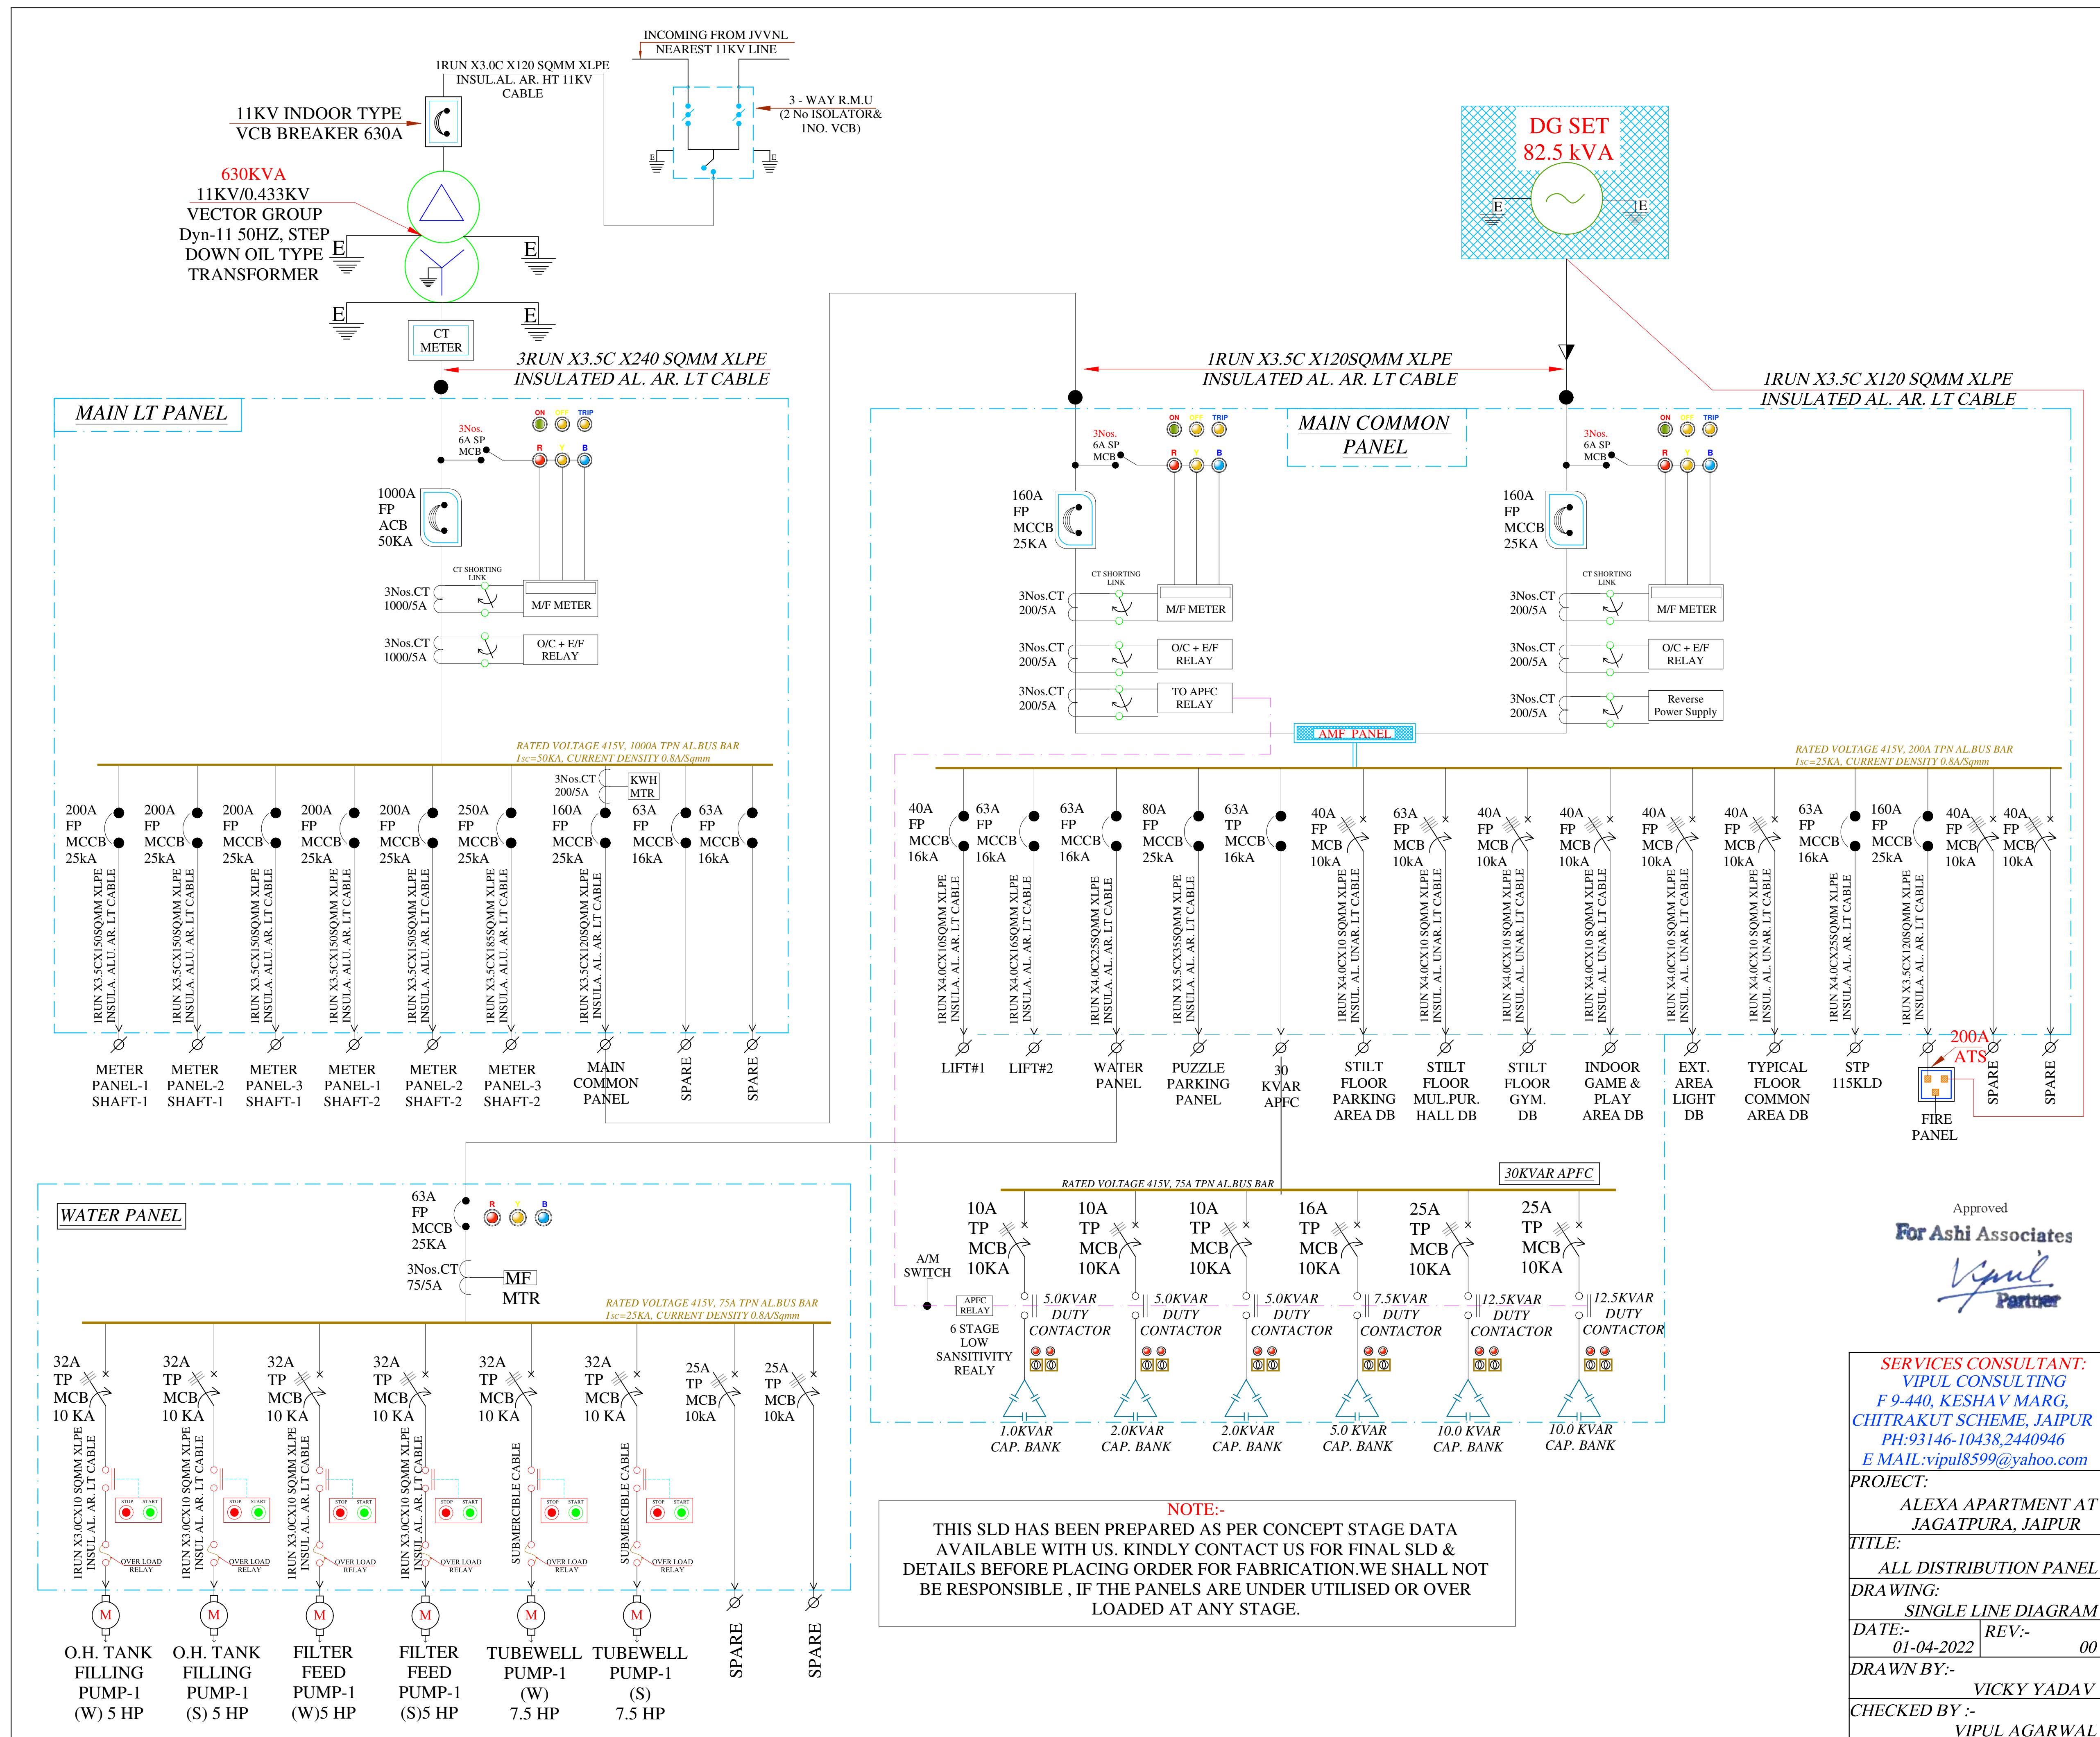


SHAFT-1: METER PANEL-1
TOTAL 1BHK FLATS 60NOS

REQUIRED TYPICAL 2NO. METER PANEL
PANEL-1=30NOS. 1BHK FLATS METER
PANEL-2=30NOS. 1BHK FLATS METER

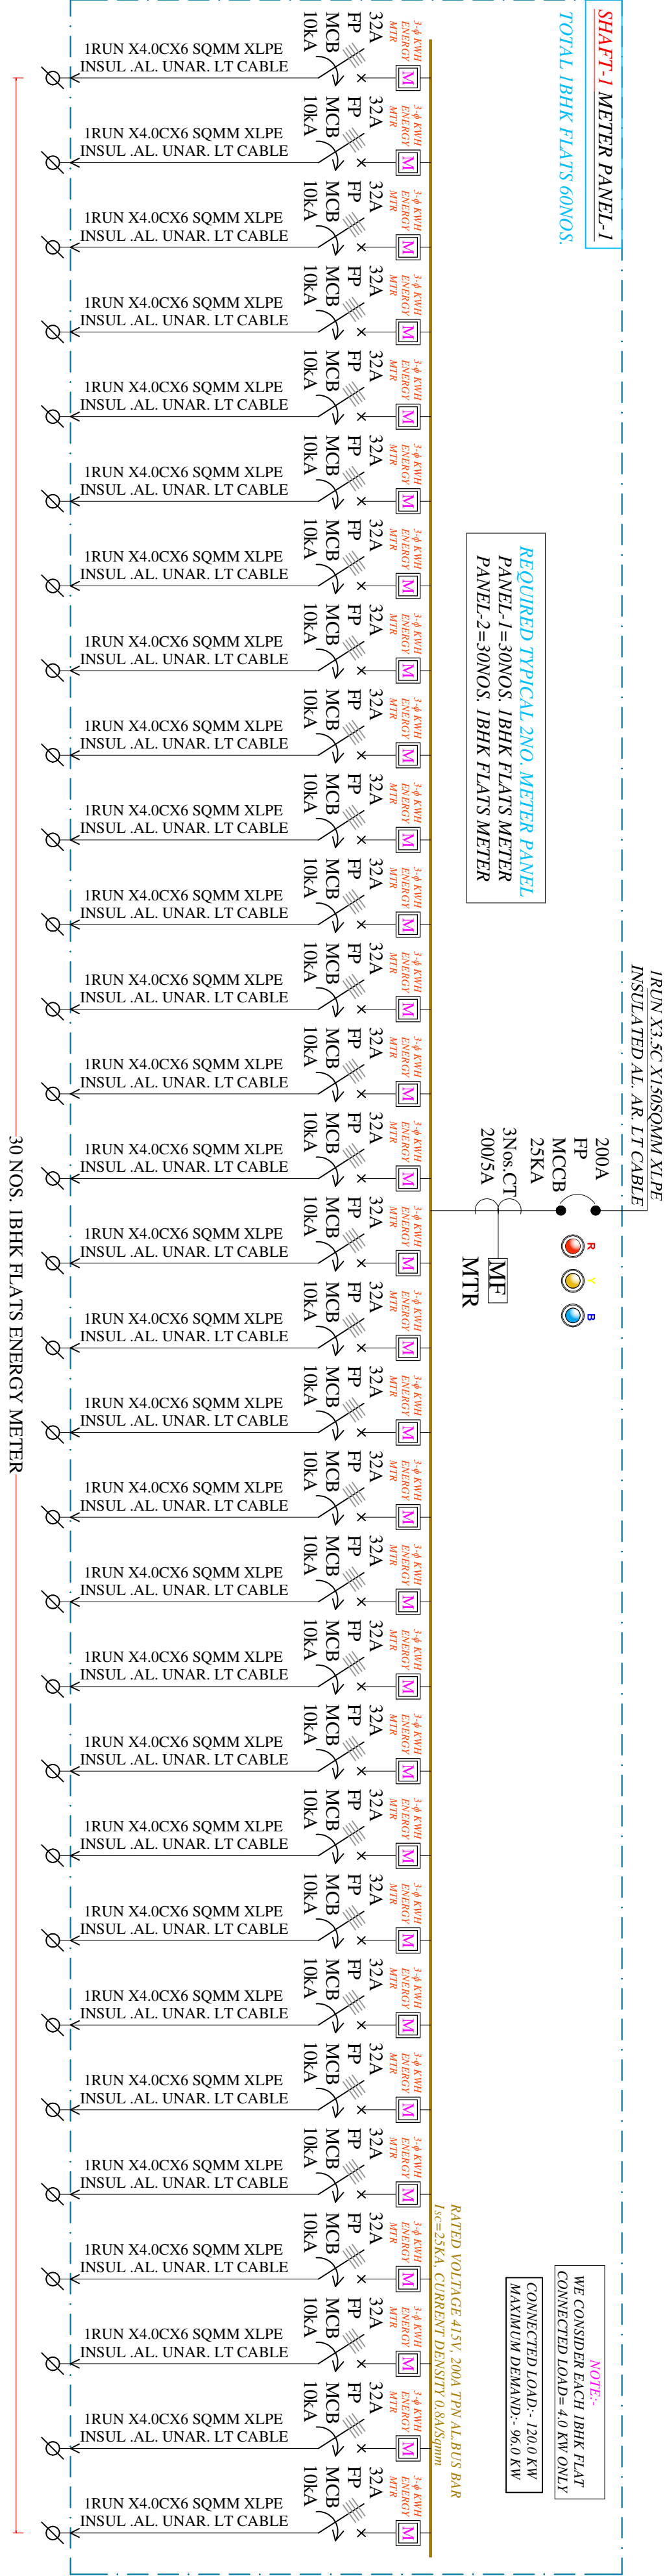


SHAFT-1: METER PANEL-3
TOTAL 2BHK FLATS 15NOS
TOTAL 3BHK FLATS 08NOS

REQUIRED TYPICAL 2NO. METER PANEL
PANEL-1=30NOS. 1BHK FLATS METER
PANEL-2=30NOS. 1BHK FLATS METER

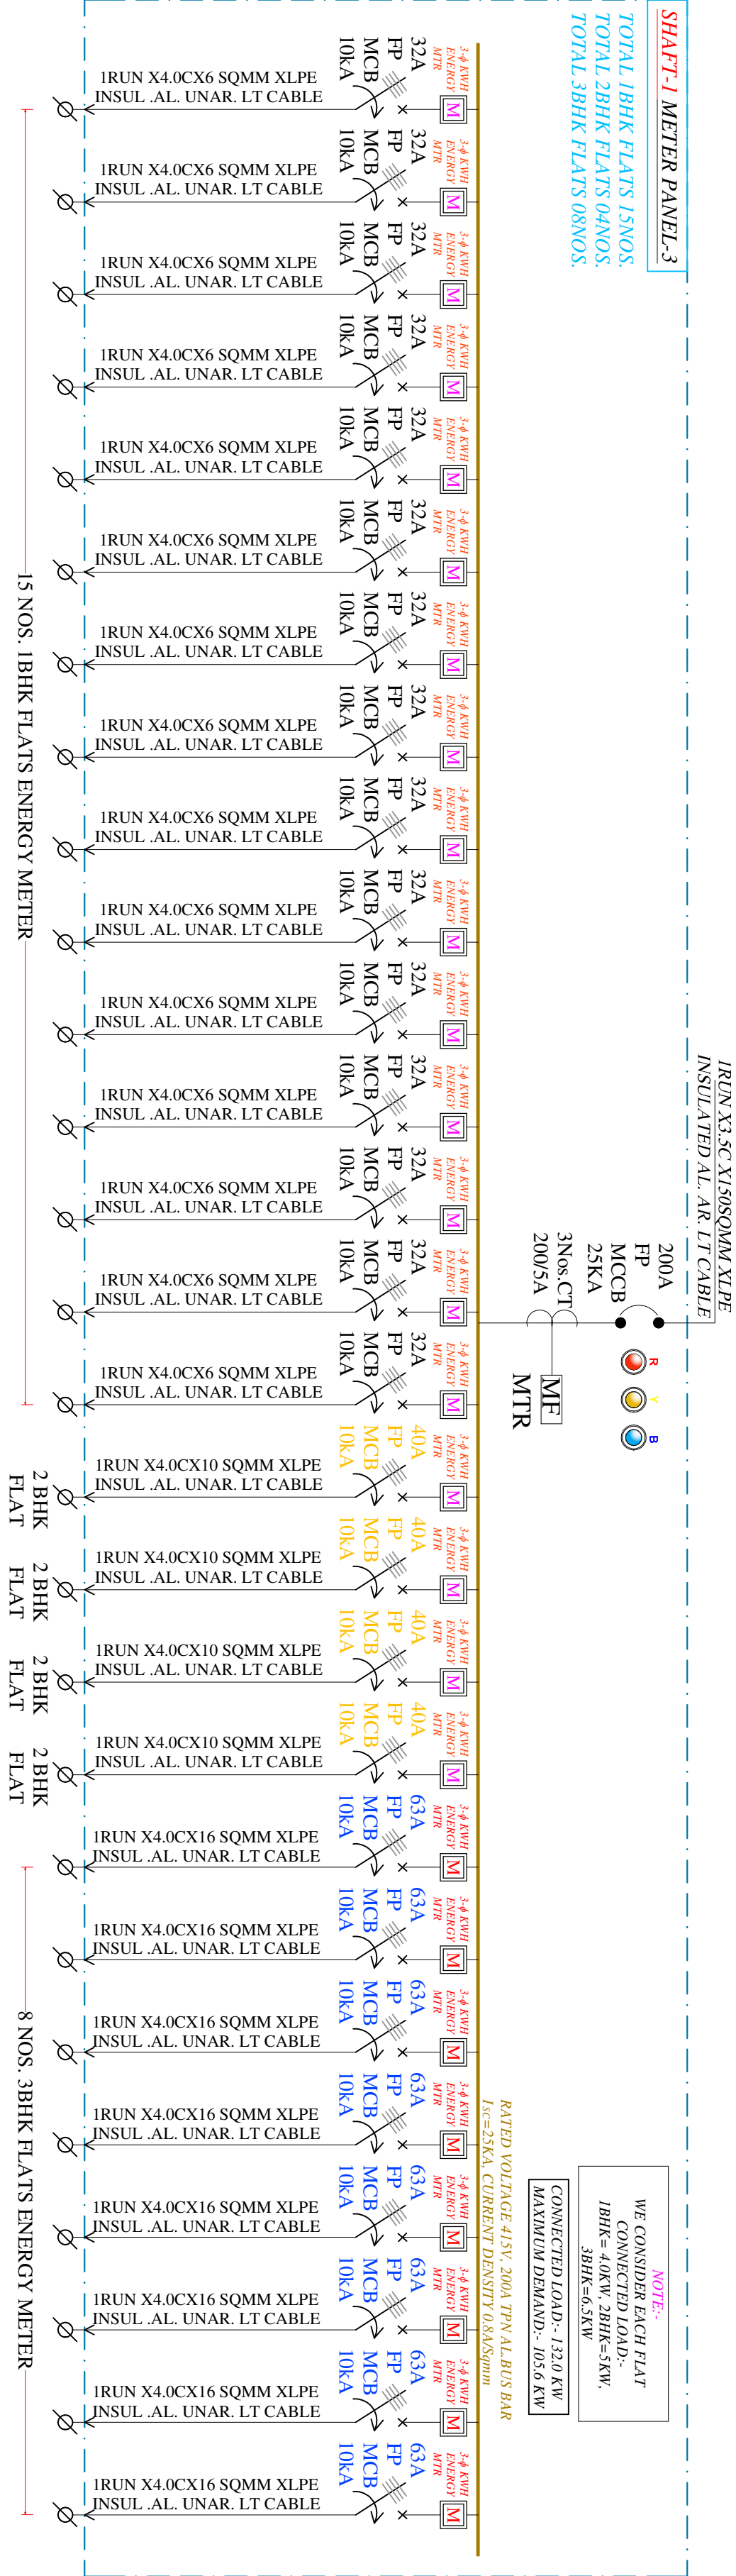


SHAFT-2: METER PANEL-1
TOTAL 1BHK FLATS 60NOS

REQUIRED TYPICAL 2NO. METER PANEL
PANEL-1=30NOS. 1BHK FLATS METER
PANEL-2=30NOS. 1BHK FLATS METER

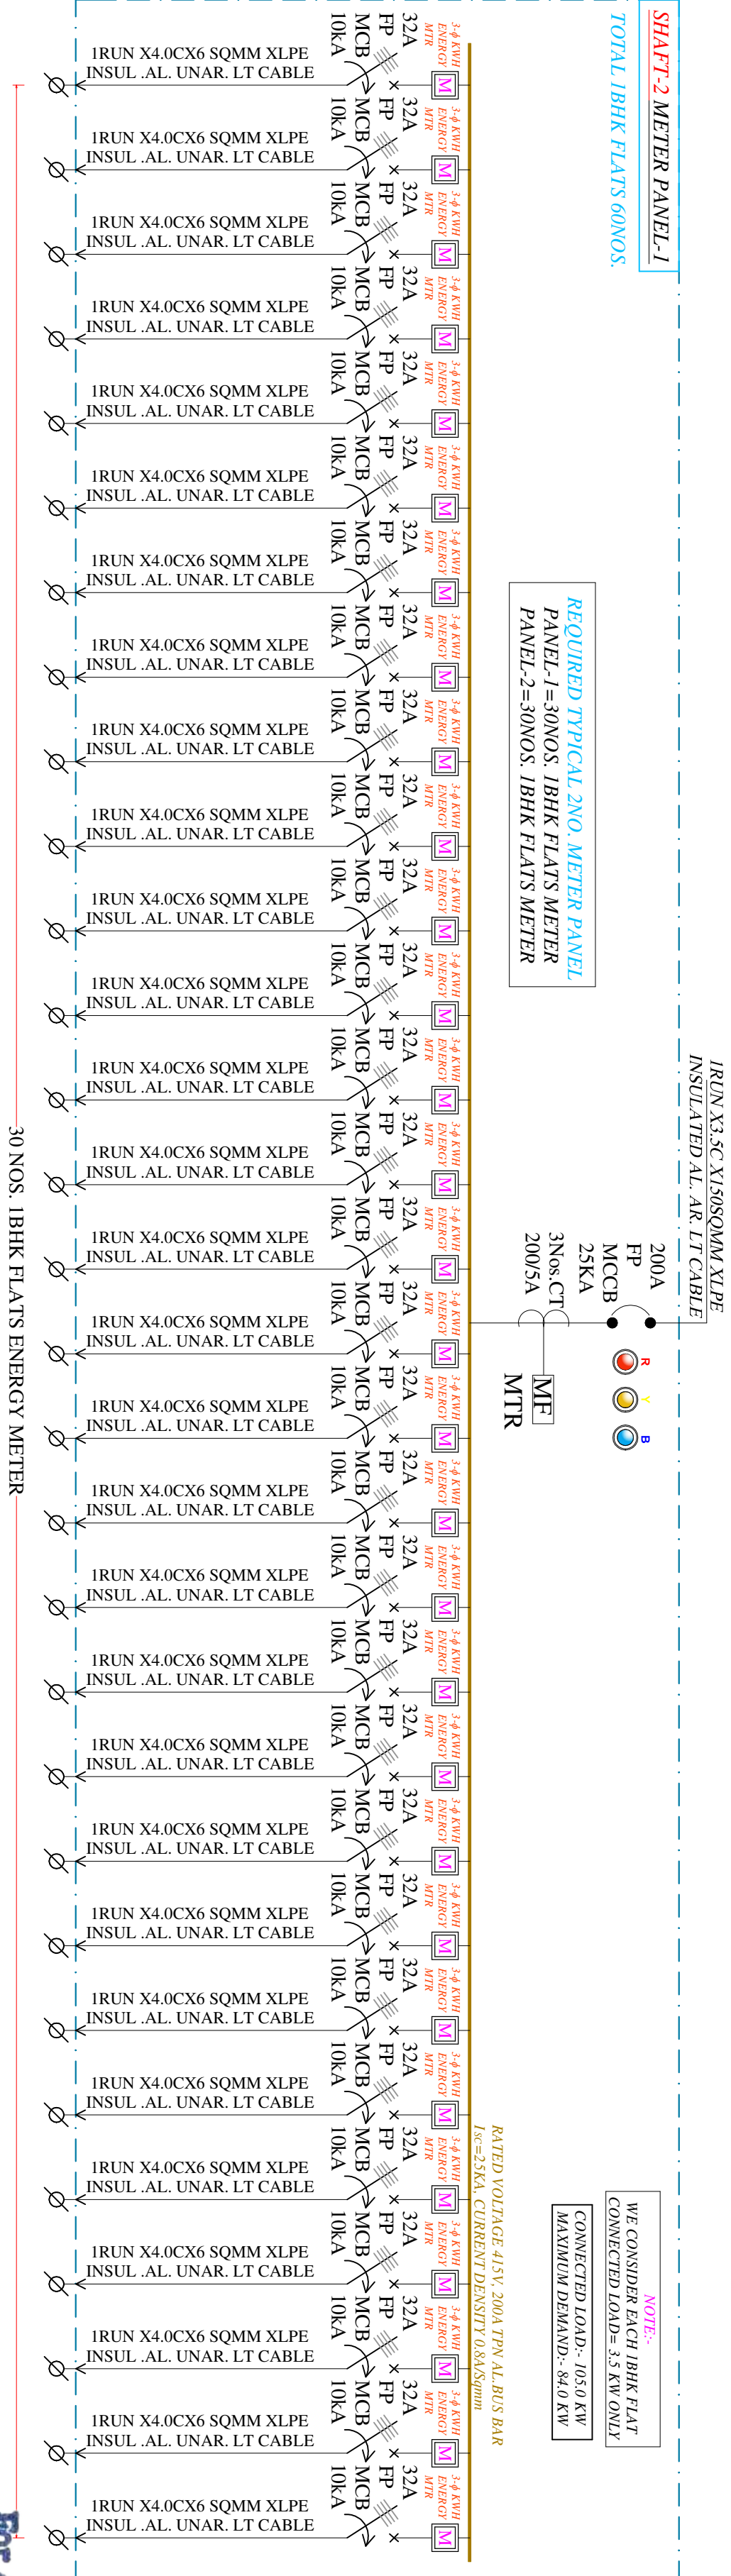

SHAFT-2: METER PANEL-3
TOTAL 2BHK FLATS 08NOS
TOTAL 3BHK FLATS 20NOS

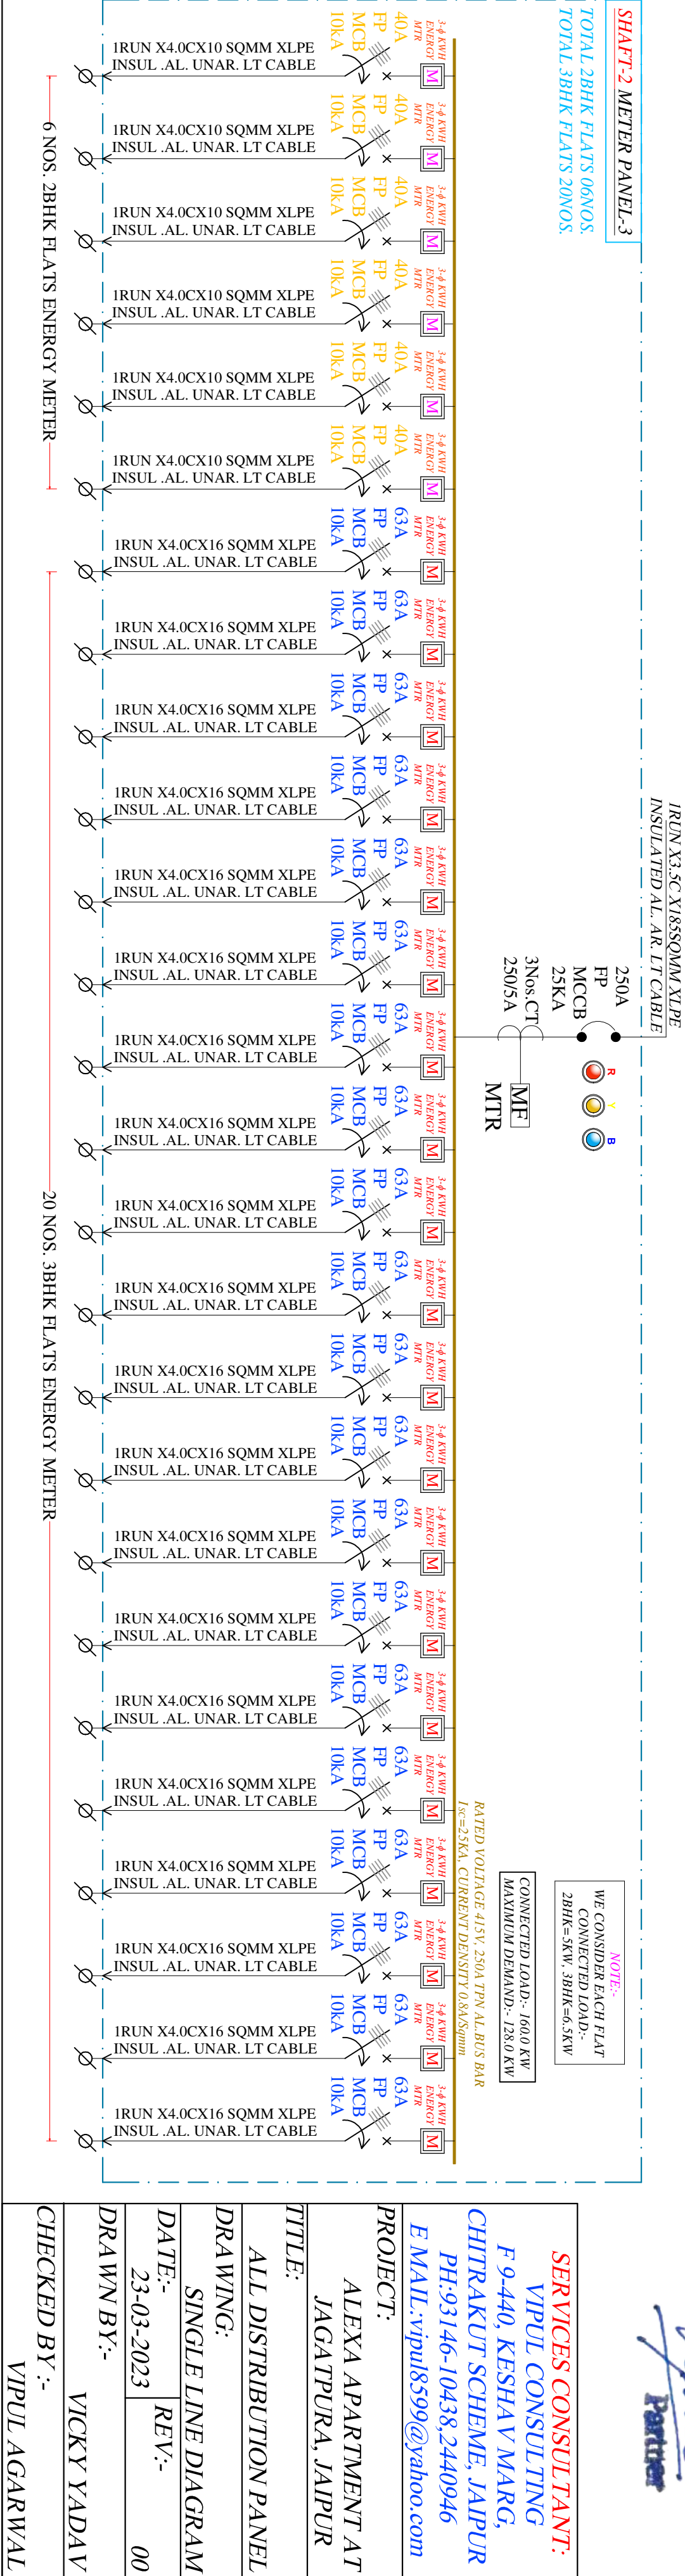

Approved
For Ashi Associates
Patel

SERVICES CONSULTANT:
VIPUL CONSULTING
F-9-440, KESHAV NAGAR,
CHITRAKUT SCHEME, JAIPUR
PH-93146-10438,2440946
E-MAIL:-vipul8599@yahoo.com

PROJECT:
ALEXA APARTMENT AT
JAGATPURA, JAIPUR
TITLE:
ALL DISTRIBUTION PANEL
DRAWING:
SINGLE LINE DIAGRAM
DATE:-
23-03-2023
REV:-
00
DRAWN BY:-
VICKY YADAV
CHECKED BY :-
VIPUL AGARWAL