












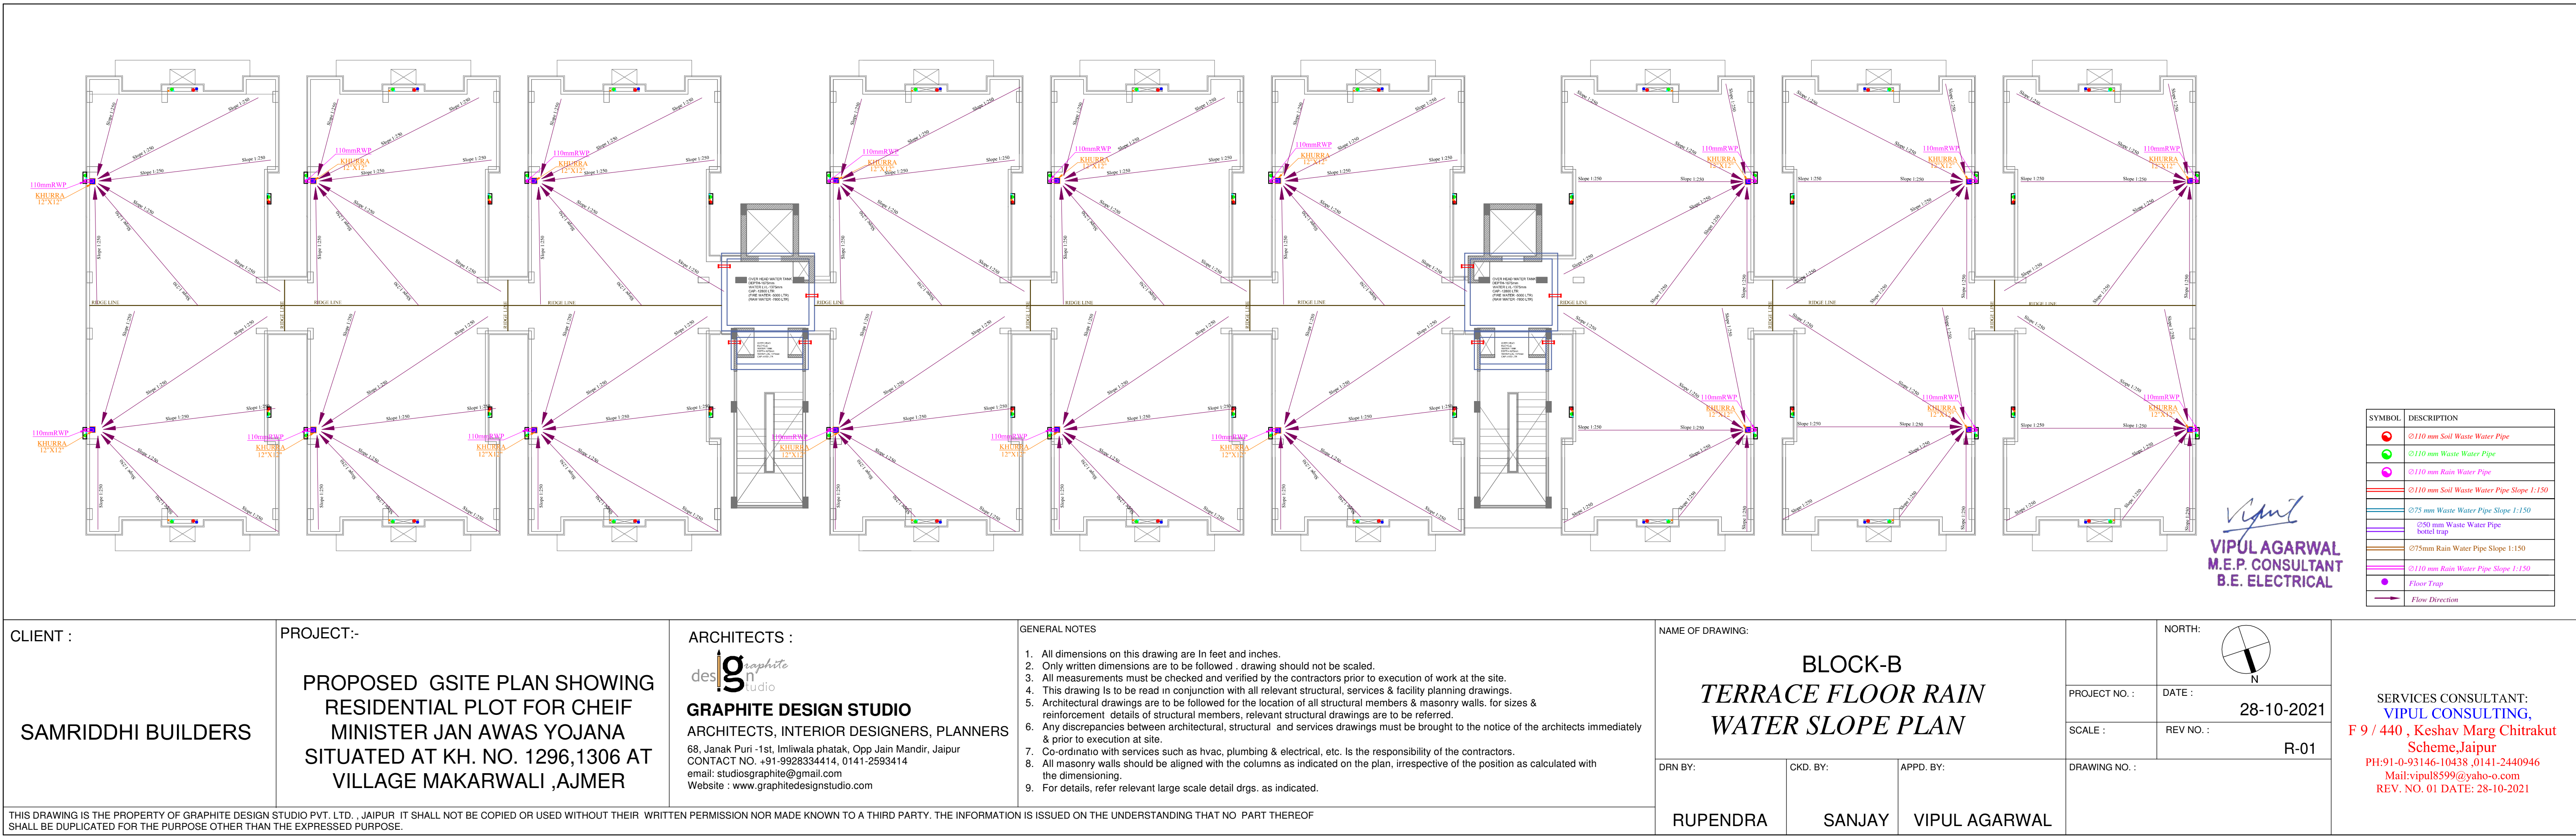



Vipul
VIPUL AGARWAL
M.E.P. CONSULTANT
B.E. ELECTRICAL


CLIENT :	PROJECT:-	<div>des^{ig}raphite studio</div> <div>GRAPHITE DESIGN STUDIO</div> <div>ARCHITECTS, INTERIOR DESIGNERS, PLANNERS</div> <div>68, Janak Puri -1st, Milwala phatak, Opp Jain Mandir, Jaipur</div> <div>CONTACT NO. +91-9928334414, 0141-2593414</div> <div>email: studiosgraphite@gmail.com</div> <div>Website: www.graphitedesignstudio.com</div>	<div>GENERAL NOTES</div> <div>1. All dimensions on this drawing are in feet and inches.</div> <div>2. Only written dimensions are to be followed - drawing should not be scaled.</div> <div>3. All measurements must be checked and verified by the contractors prior to execution of work at the site.</div> <div>4. This drawing is to be read in conjunction with all relevant structural, services & facility planning drawings.</div> <div>5. Architectural drawings are to be followed for the location of all structural members & masonry walls, for sizes & reinforcement details of structural members, relevant structural drawings are to be referred.</div> <div>6. Any discrepancies between architectural, structural and services drawings must be brought to the notice of the architects immediately & prior to execution at site.</div> <div>7. Co-ordinate with services such as hvac, plumbing & electrical, etc. Is the responsibility of the contractors.</div> <div>8. All masonry walls should be aligned with the columns as indicated on the plan, irrespective of the position as calculated with the dimensioning.</div> <div>9. For details, refer relevant large scale detail drgs. as indicated.</div>	<div>SERVICES CONSULTANT:</div> <div>VIPUL CONSULTING,</div> <div>F 9 / 440 , Keshav Marg Chitrakut Scheme,Jaipur</div> <div>PH:91-0-93146-10438,0141-2440946 Mail:vipul8599@yahoo.com</div>	<div>NAME OF DRAWING:</div> <div>EXTERNAL RAIN WATER PIPE AND CHAMBER ROUTE WITH LEVELS PLAN</div>	<div>DRAWN BY:</div> <div>FALGUNI</div>	<div>CHECK BY:</div> <div>SANJAY</div>	<div>APPROVED BY:</div> <div>VIPUL AGARWAL</div>	<div>PROJECT NO. :</div> <div>DATE : 24-02-2022</div>	<div>SCALE :</div> <div>REV NO. : R-01</div>	<div>DRAWING NO. :</div>	<div></div>	<div></div>	<div>110 mm RAIN WATER PIPE</div>	<div></div>	<div>75 mm RAIN WATER PIPE</div>	<div></div>	<div>75 mm RAIN WATER PIPE</div>	<div></div> <div>Ø160 mm RAIN WATER PIPE SLOPE 1:200</div>	<div></div> <div>RAIN WATER GRATING CHAMBER 450 X 450 MM</div>
	<div></div> <div>Ø200 mm Rain Water Pipe Slope 1:200</div>			<div></div> <div>RAIN WATER GRATING CHAMBER 600 X 600 MM</div>																
	<div></div> <div>110 mm Rain Water Pipe</div>			<div></div> <div>RAIN WATER GRATING CHAMBER 900 X 800 MM</div>																
	<div></div> <div>75 mm RAIN WATER PIPE</div>																			
	<div></div> <div></div>			<div></div> <div>RAIN WATER PIPE SLOPE</div>																
<div>THIS DRAWING IS THE PROPERTY OF GRAPHITE DESIGN STUDIO PVT. LTD., JAIPUR. IT SHALL NOT BE COPIED OR USED WITHOUT THEIR WRITTEN PERMISSION NOR MADE KNOWN TO A THIRD PARTY. THE INFORMATION IS ISSUED ON THE UNDERSTANDING THAT NO PART THEREOF SHALL BE DUPLICATED FOR THE PURPOSE OTHER THAN THE EXPRESSED PURPOSE.</div>																				



<div>CLIENT :</div> <div>SAMRIDDHI BUILDERS</div>	<div>PROJECT:-</div> <div>PROPOSED GSITE PLAN SHOWING RESIDENTIAL PLOT FOR CHEIF MINISTER JAN AWAS YOJANA SITUATED AT KH. NO. 1296,1306 AT VILLAGE MAKARWALI ,AJMER</div>	<div>ARCHITECTS :</div> <div><div><div>desig</div><div>graphite</div><div>studio</div></div><div>GRAPHITE DESIGN STUDIO</div><div>ARCHITECTS, INTERIOR DESIGNERS, PLANNERS</div><div>68, Janak Puri -1st, Imliwala phatak, Opp Jain Mandir, Jaipur</div><div>CONTACT NO. +91-9928334414, 0141-2593414</div><div>email: studiosgraphite@gmail.com</div><div>Website : www.graphitedesignstudio.com</div></div>	<div>GENERAL NOTES</div> <div><div>1. All dimensions on this drawing are In feet and inches.</div><div>2. Only written dimensions are to be followed , drawing should not be scaled.</div><div>3. All measurements must be checked and verified by the contractors prior to execution of work at the site.</div><div>4. This drawing Is to be read in conjunction with all relevant structural, services & facility planning drawings.</div><div>5. Architectural drawings are to be followed for the location of all structural members & masonry walls. for sizes & reinforcement details of structural members, relevant structural drawings are to be referred.</div><div>6. Any discrepancies between architectural, structural and services drawings must be brought to the notice of the architects immediately & prior to execution at site.</div><div>7. Co-ordinatio with services such as hvac, plumbing & electrical, etc. Is the responsibility of the contractors.</div><div>8. All masonry walls should be aligned with the columns as indicated on the plan, irrespective of the position as calculated with the dimensioning.</div><div>9. For details, refer relevant large scale detail drgs. as indicated.</div></div>	<div>NAME OF DRAWING:</div> <div>BLOCK-B TERRACE FLOOR RAIN WATER SLOPE PLAN</div> <div><div>DRN BY:</div><div>CKD. BY:</div><div>APPD. BY:</div></div> <div><div>RUPENDRA</div><div>SANJAY</div><div>VIPUL AGARWAL</div></div>	<div><div>PROJECT NO. :</div><div>SCALE :</div></div> <div><div>DATE :</div><div>REV NO. :</div></div> <div><div>28-10-2021</div><div>R-01</div></div> <div><div>DRAWING NO. :</div></div>	<div><div>NORTH:</div><div></div></div> <div><div>SERVICES CONSULTANT:</div><div>VIPUL CONSULTING,</div><div>F 9 / 440 , Keshav Marg Chitrakut</div><div>Scheme,Jaipur</div><div>PH:91-0-93146-10438, 0141-2440946</div><div>Mail:vipul8599@yahoo-o.com</div><div>REV. NO. 01 DATE: 28-10-2021</div></div>
---	---	---	--	---	--	--

THIS DRAWING IS THE PROPERTY OF GRAPHITE DESIGN STUDIO PVT. LTD. , JAIPUR IT SHALL NOT BE COPIED OR USED WITHOUT THEIR WRITTEN PERMISSION NOR MADE KNOWN TO A THIRD PARTY. THE INFORMATION IS ISSUED ON THE UNDERSTANDING THAT NO PART THEREOF SHALL BE DUPLICATED FOR THE PURPOSE OTHER THAN THE EXPRESSED PURPOSE.

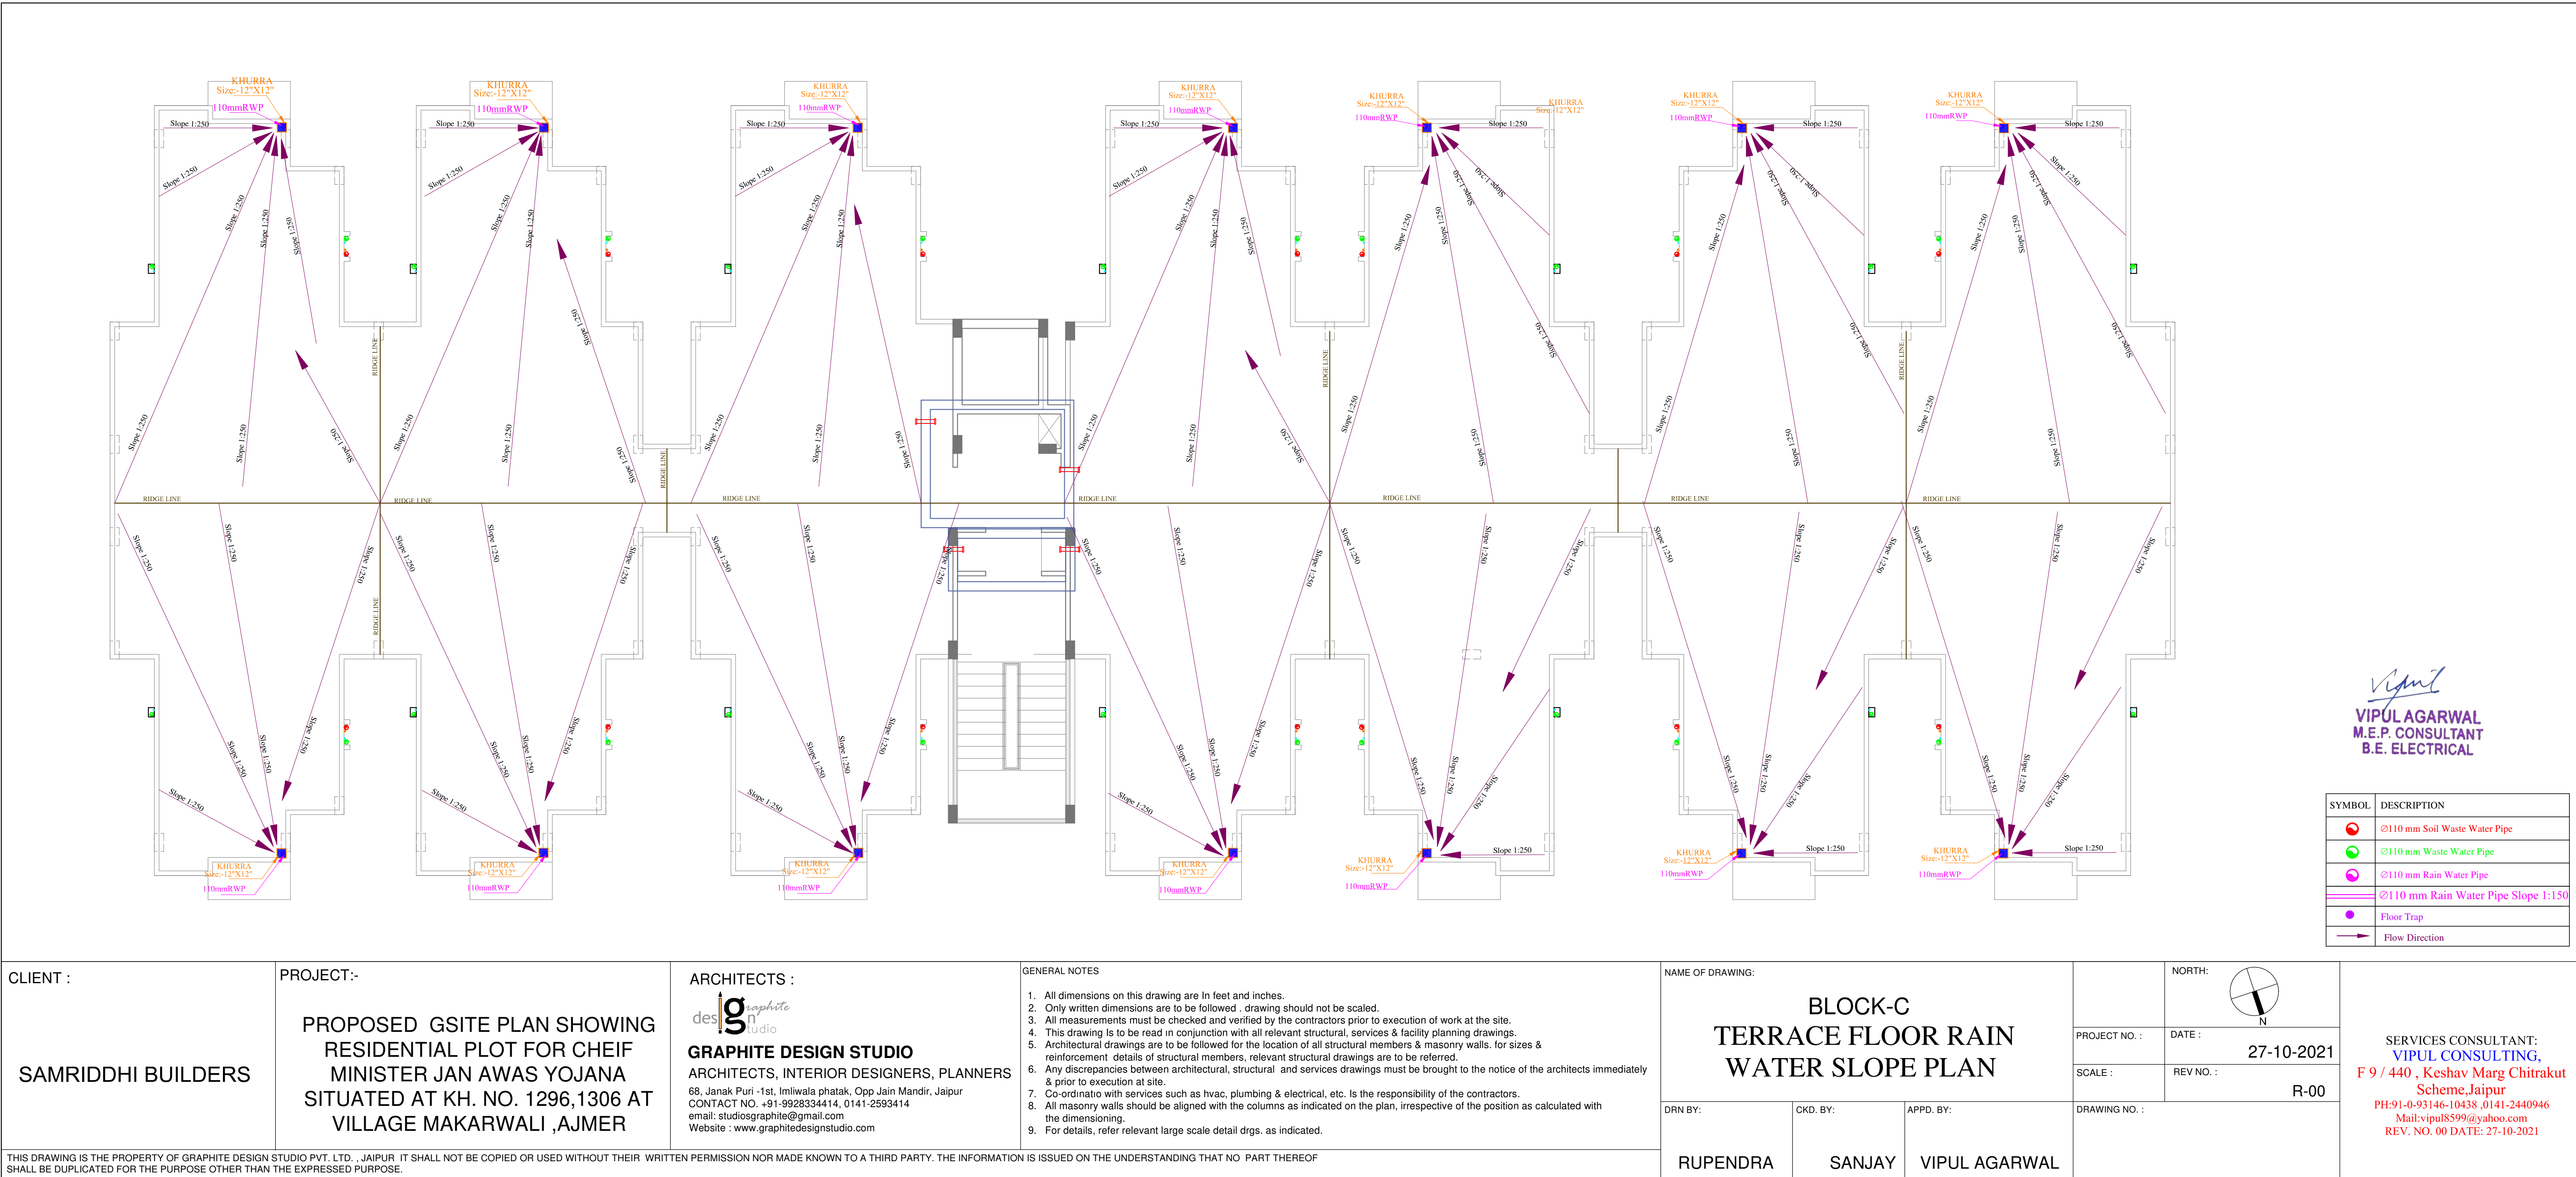

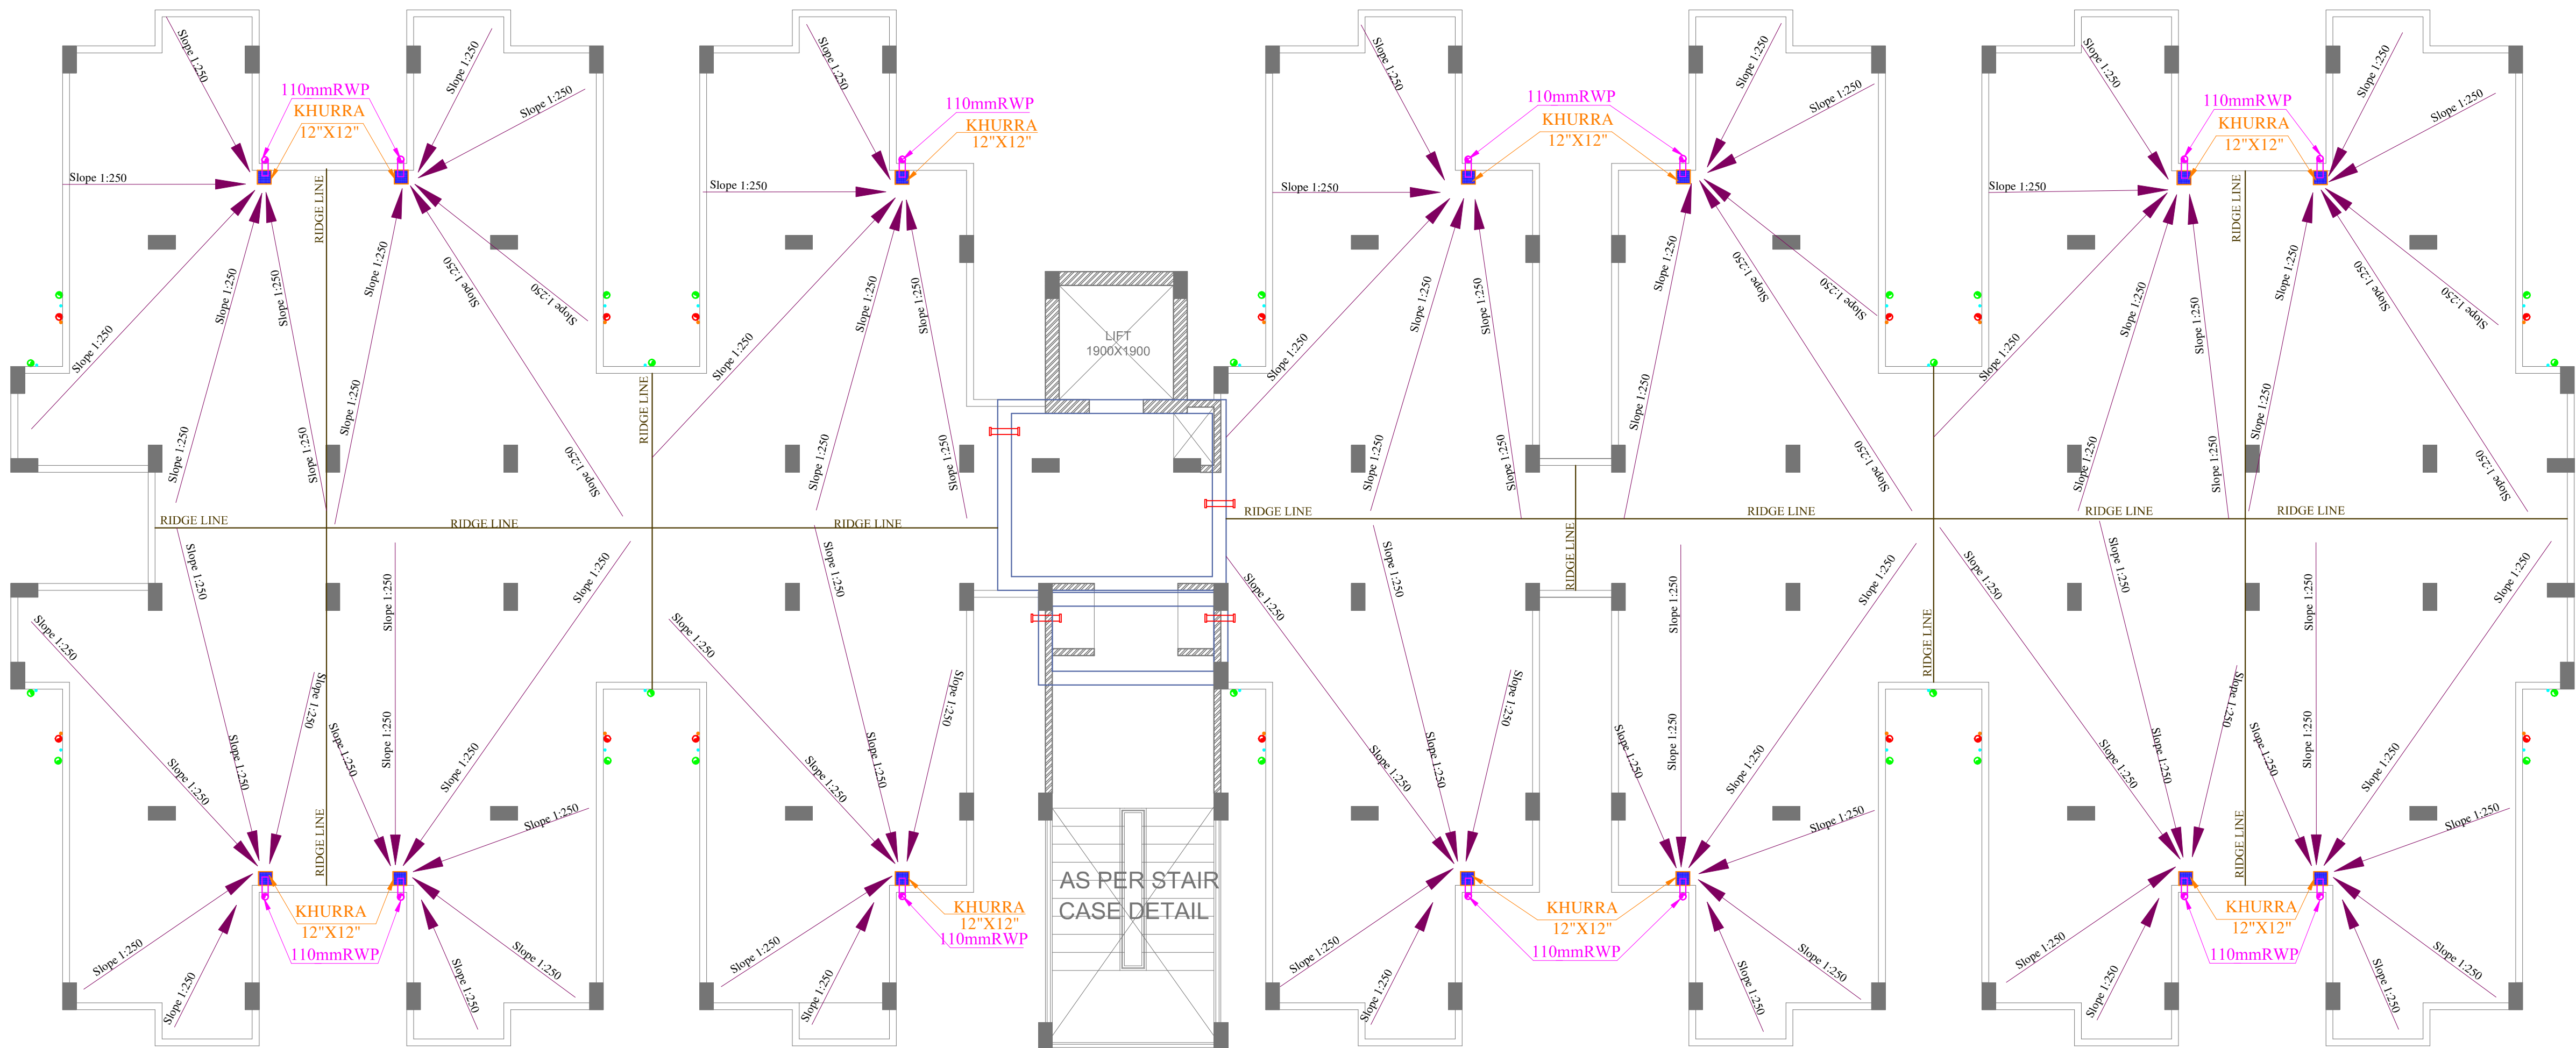



Vipul
VIPUL AGARWAL
M.E.P. CONSULTANT
B.E. ELECTRICAL

SYMBOL	DESCRIPTION
	Ø110 mm Soil Waste Water Pipe
	Ø110 mm Waste Water Pipe
	Ø110 mm Rain Water Pipe
	Flow Direction


CLIENT : SAMRIDDHI BUILDERS	PROJECT:- PROPOSED GSITE PLAN SHOWING RESIDENTIAL PLOT FOR CHEIF MINISTER JAN AWAS YOJANA SITUATED AT KH. NO. 1296,1306 AT VILLAGE MAKARWALI ,AJMER	ARCHITECTS : GRAPHITE DESIGN STUDIO ARCHITECTS, INTERIOR DESIGNERS, PLANNERS 68, Janak Puri -1st, Imliwala phatak, Opp Jain Mandir, Jaipur CONTACT NO. +91-9928334414, 0141-2593414 email: studiosgraphite@gmail.com Website : www.graphitedesignstudio.com	GENERAL NOTES <ol style="list-style-type: none">1. All dimensions on this drawing are in feet and inches.2. Only written dimensions are to be followed . drawing should not be scaled.3. All measurements must be checked and verified by the contractors prior to execution of work at the site.4. This drawing is to be read in conjunction with all relevant structural, services & facility planning drawings.5. Architectural drawings are to be followed for the location of all structural members & masonry walls. for sizes & reinforcement details of structural members, relevant structural drawings are to be referred.6. Any discrepancies between architectural, structural and services drawings must be brought to the notice of the architects immediately & prior to execution at site.7. Co-ordination with services such as hvac, plumbing & electrical, etc. is the responsibility of the contractors.8. All masonry walls should be aligned with the columns as indicated on the plan, irrespective of the position as calculated with the dimensioning.9. For details, refer relevant large scale detail drgs. as indicated.	NAME OF DRAWING: BLOCK-D TERRACE FLOOR RAIN WATER SLOPE PLAN		DRAWING NO. : R-01	NORTH: N	SERVICES CONSULTANT: VIPUL CONSULTING, F 9 / 440 , Keshav Marg Chitrakut Scheme,Jaipur PH:91-0-93146-10438 ,0141-2440946 Mail:vipul8599@yahoo.com REV. NO. 01 DATE: 27-10-2021
				DRN BY: RUPENDRA	CKD. BY: SANJAY	APPD. BY: VIPUL AGARWAL		

THIS DRAWING IS THE PROPERTY OF GRAPHITE DESIGN STUDIO PVT. LTD. , JAIPUR. IT SHALL NOT BE COPIED OR USED WITHOUT THEIR WRITTEN PERMISSION NOR MADE KNOWN TO A THIRD PARTY. THE INFORMATION IS ISSUED ON THE UNDERSTANDING THAT NO PART THEREOF SHALL BE DUPLICATED FOR THE PURPOSE OTHER THAN THE EXPRESSED PURPOSE.

RAIN WATER HARVESTING TANK
SIZE-15'-0"(L) X 15'-0"(W) X 16'-0"(D)
EFFECTIVE DEPTH
TOTAL DEPTH-18'-8"

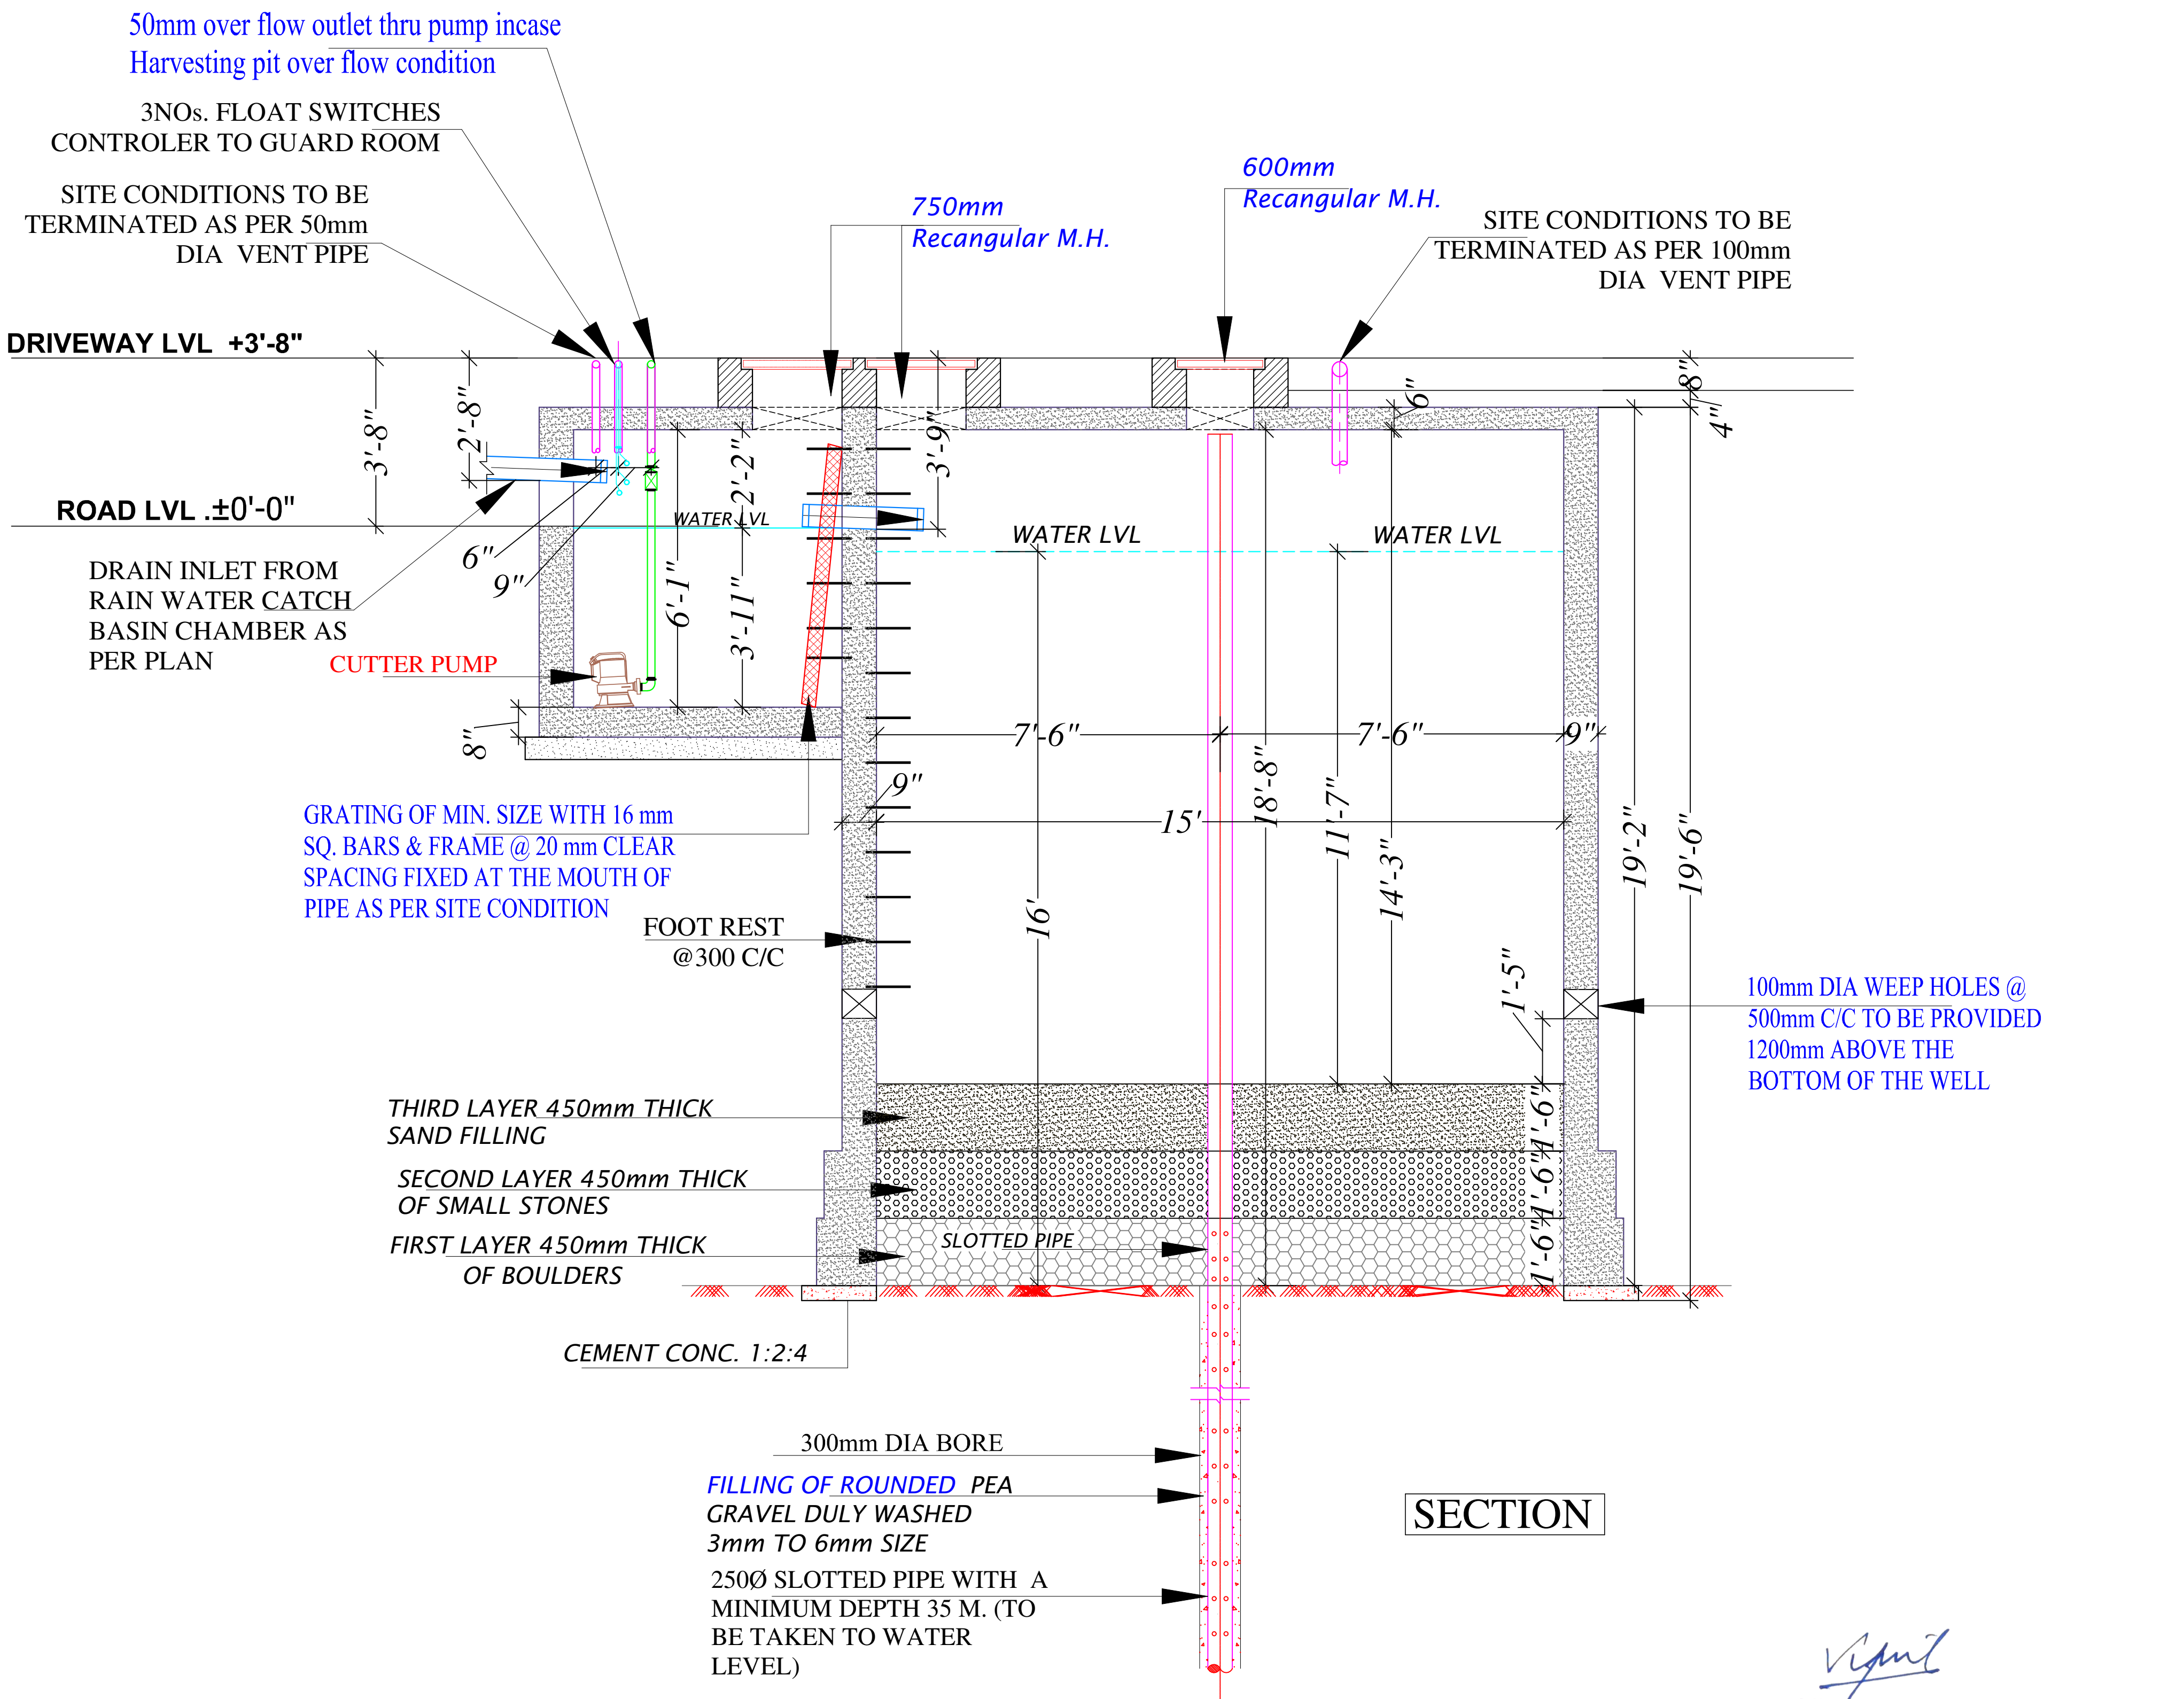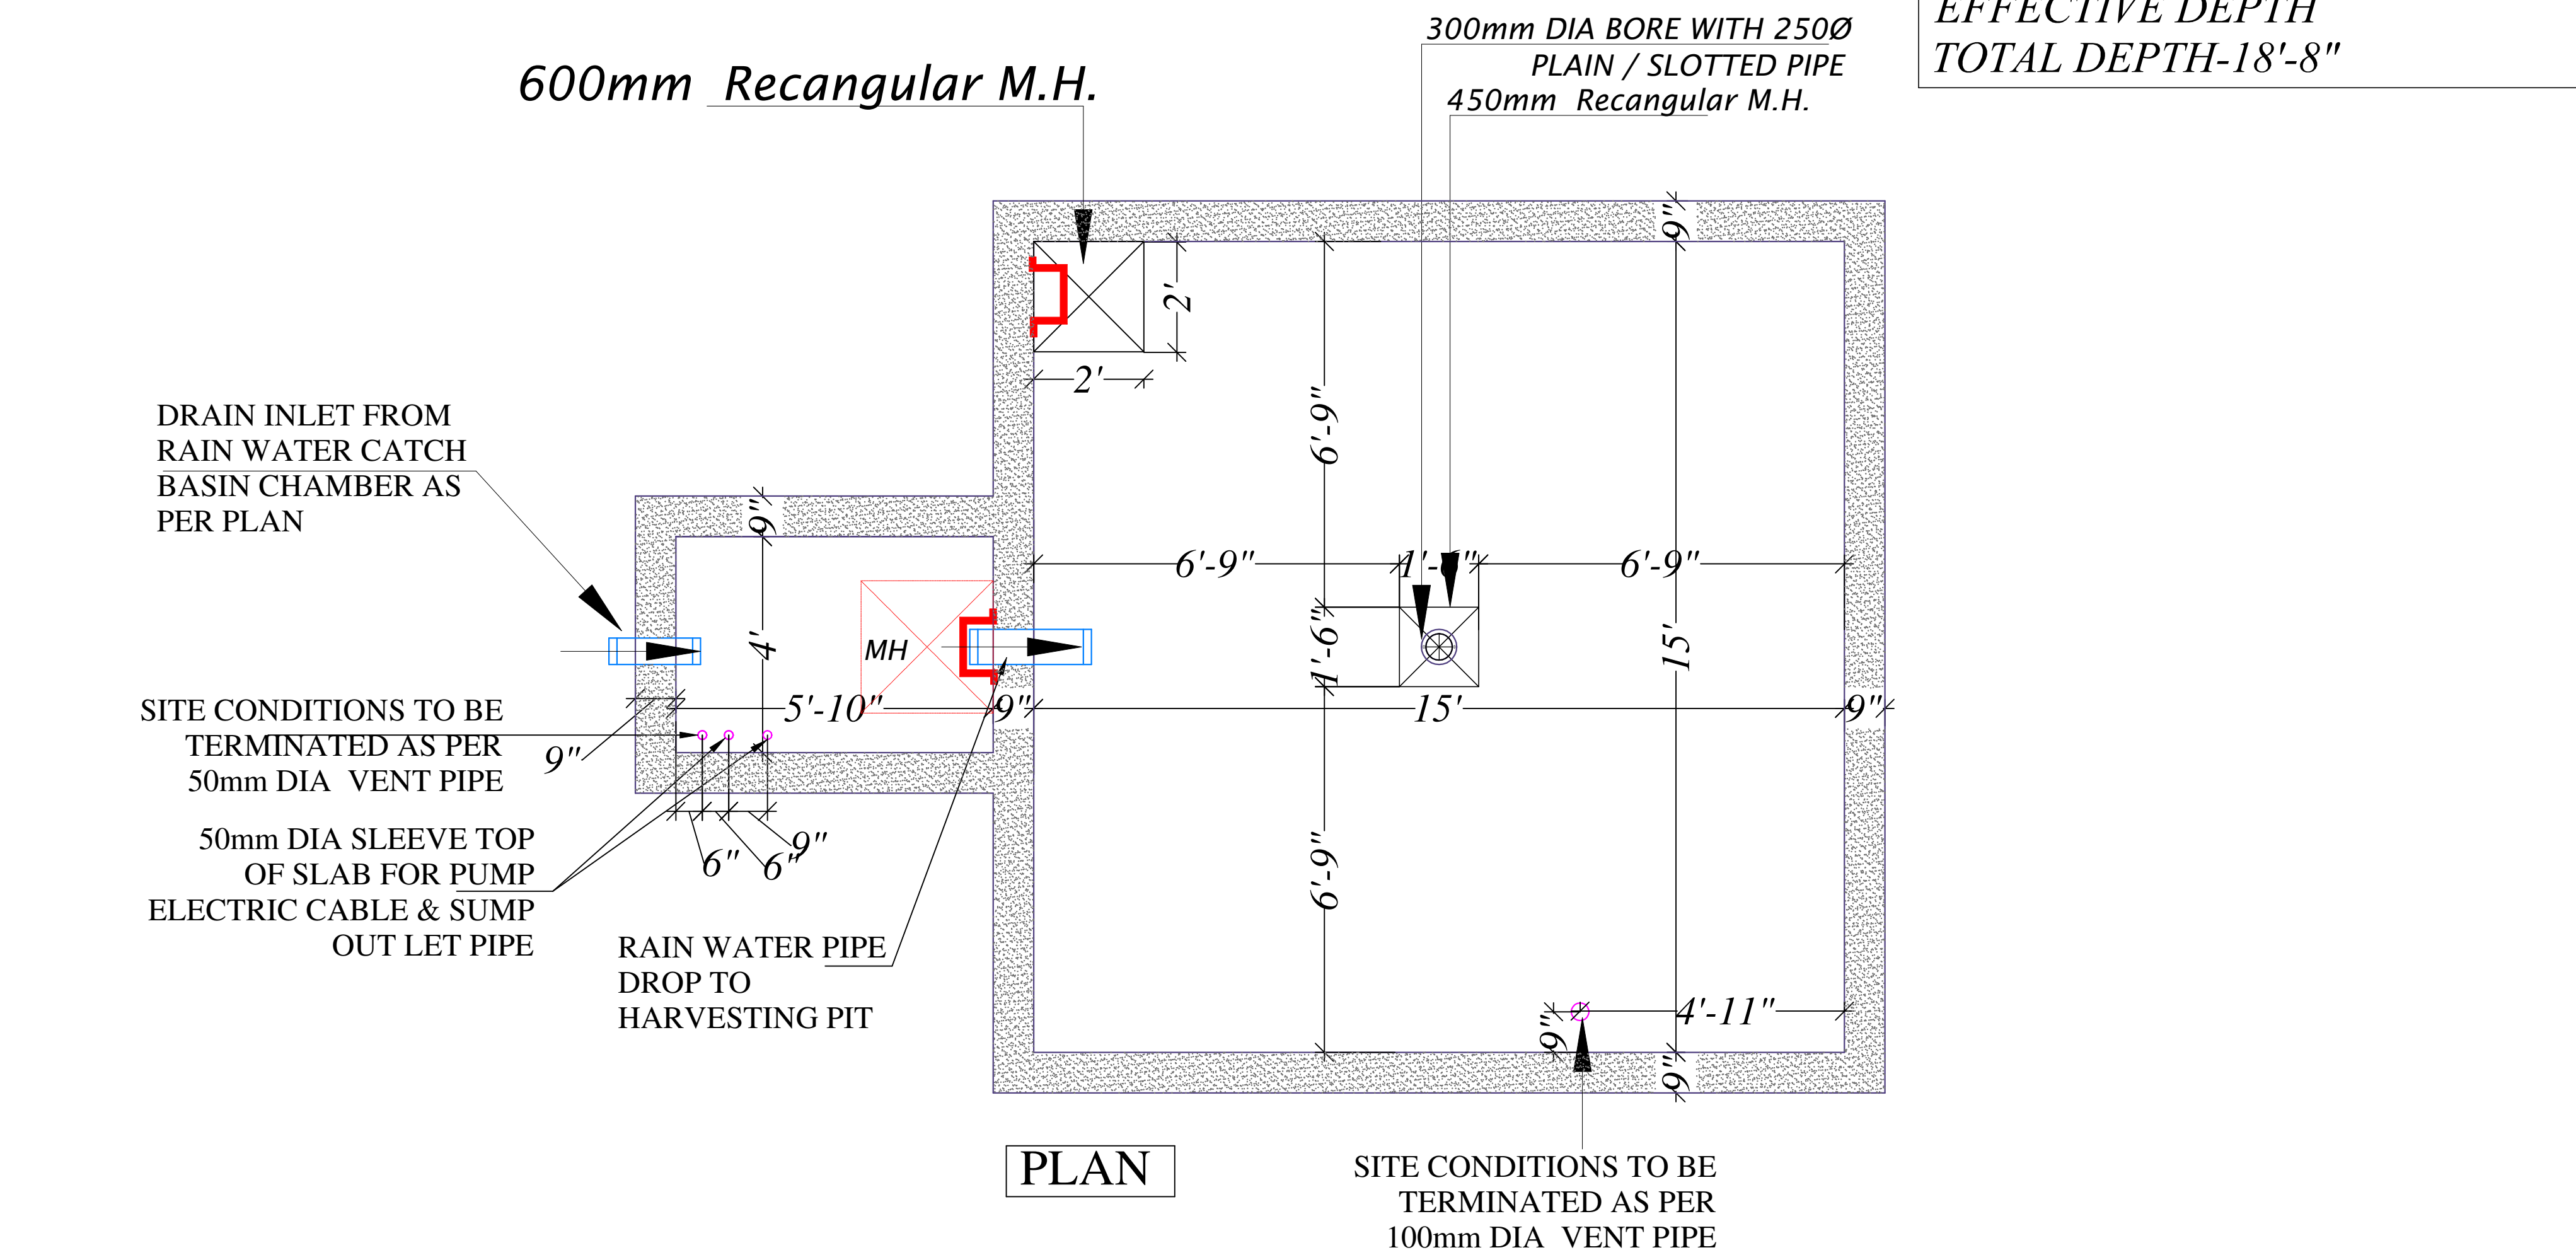

Vipul
VIPUL AGARWAL
M.E.P. CONSULTANT
B.E. ELECTRICAL

CLIENT : SAMRIDDHI BUILDERS	PROJECT:- PROPOSED GSITE PLAN SHOWING RESIDENTIAL PLOT FOR CHEIF MINISTER JAN AWAS YOJANA SITUATED AT KH. NO. 1296,1306 AT VILLAGE MAKARWALI ,AJMER	ARCHITECTS : des ^g graphite studio GRAPHITE DESIGN STUDIO ARCHITECTS, INTERIOR DESIGNERS, PLANNERS 66, Janak Puri-1st, Indirapatti phatak, Opp Jan Mandir, Jaipur CONTACT NO. +91-9928334414, 0141-2593414 email: studiosgraphite@gmail.com Website : www.graphitedesignstudio.com	<div>GENERAL NOTES</div> <div><div>1. All dimensions on this drawing are in feet and inches.</div><div>2. Only written dimensions are to be followed. drawing should not be scaled.</div><div>3. All measurements must be checked and verified by the contractors prior to execution of work at the site.</div><div>4. This drawing is to be read in conjunction with all relevant structural, services & facility planning drawings.</div><div>5. Architectural drawings are to be followed for the location of all structural members & masonry walls, for sizes & reinforcement details of structural members, relevant structural drawings are to be referred.</div><div>6. Any discrepancies between architectural, structural and services drawings must be brought to the notice of the architects immediately & prior to execution at site.</div><div>7. Co-ordination with services such as hvac, plumbing & electrical, etc. is the responsibility of the contractors.</div><div>8. All masonry walls should be aligned with the columns as indicated on the plan, irrespective of the position as calculated with the dimensioning.</div><div>9. For details, refer relevant large scale detail drgs. as indicated.</div></div>	SERVICES CONSULTANT: VIPUL CONSULTING, F 9 / 440 , Keshav Marg Chitrakut Scheme,Jaipur PH:91-0-93146-10438, 0141-2440946 Mail: vipul8599@yahoo.com		<div></div>		
				NAME OF DRAWING: TYPICAL RAIN HARVESTING PIT SECTION DETAILS PLAN				
				DRAWN BY:	CHECK BY:		APPROVED BY:	DRAWING NO. :
				RAAJ	SANJAY		VIPUL AGARWAL	MEP/RHP-01
				THIS DRAWING IS THE PROPERTY OF GRAPHITE DESIGN STUDIO PVT. LTD., JAIPUR. IT SHALL NOT BE COPIED OR USED WITHOUT THEIR WRITTEN PERMISSION NOR MADE KNOWN TO A THIRD PARTY. THE INFORMATION IS ISSUED ON THE UNDERSTANDING THAT NO PART THEREOF SHALL BE DUPLICATED FOR THE PURPOSE OTHER THAN THE EXPRESSED PURPOSE.				