 




PROPOSED LAYOUT PLAN FOR
RESIDENTIAL PLOT'S SCHEME AT
VILLAGE :NAYAKHERA, TEH.
LADPURA, DIST. KOTA
(RAJ.)KHASRA
NO.-507,508,509,511,514,
522,522/563,607/523,&523/1

LEGEND

SYMBOL	DESCRIPTION
	LT LINE TOWER
	HT LINE TOWER
	TRANSFORMER
	STREET LIGHT
	STREET LIGHT POLE DOUBLE ARM
	DISTRIBUTION PANEL
	CEMENT PIPE 4" DIA. TO BE EMBEDDED IN CONCRETE.

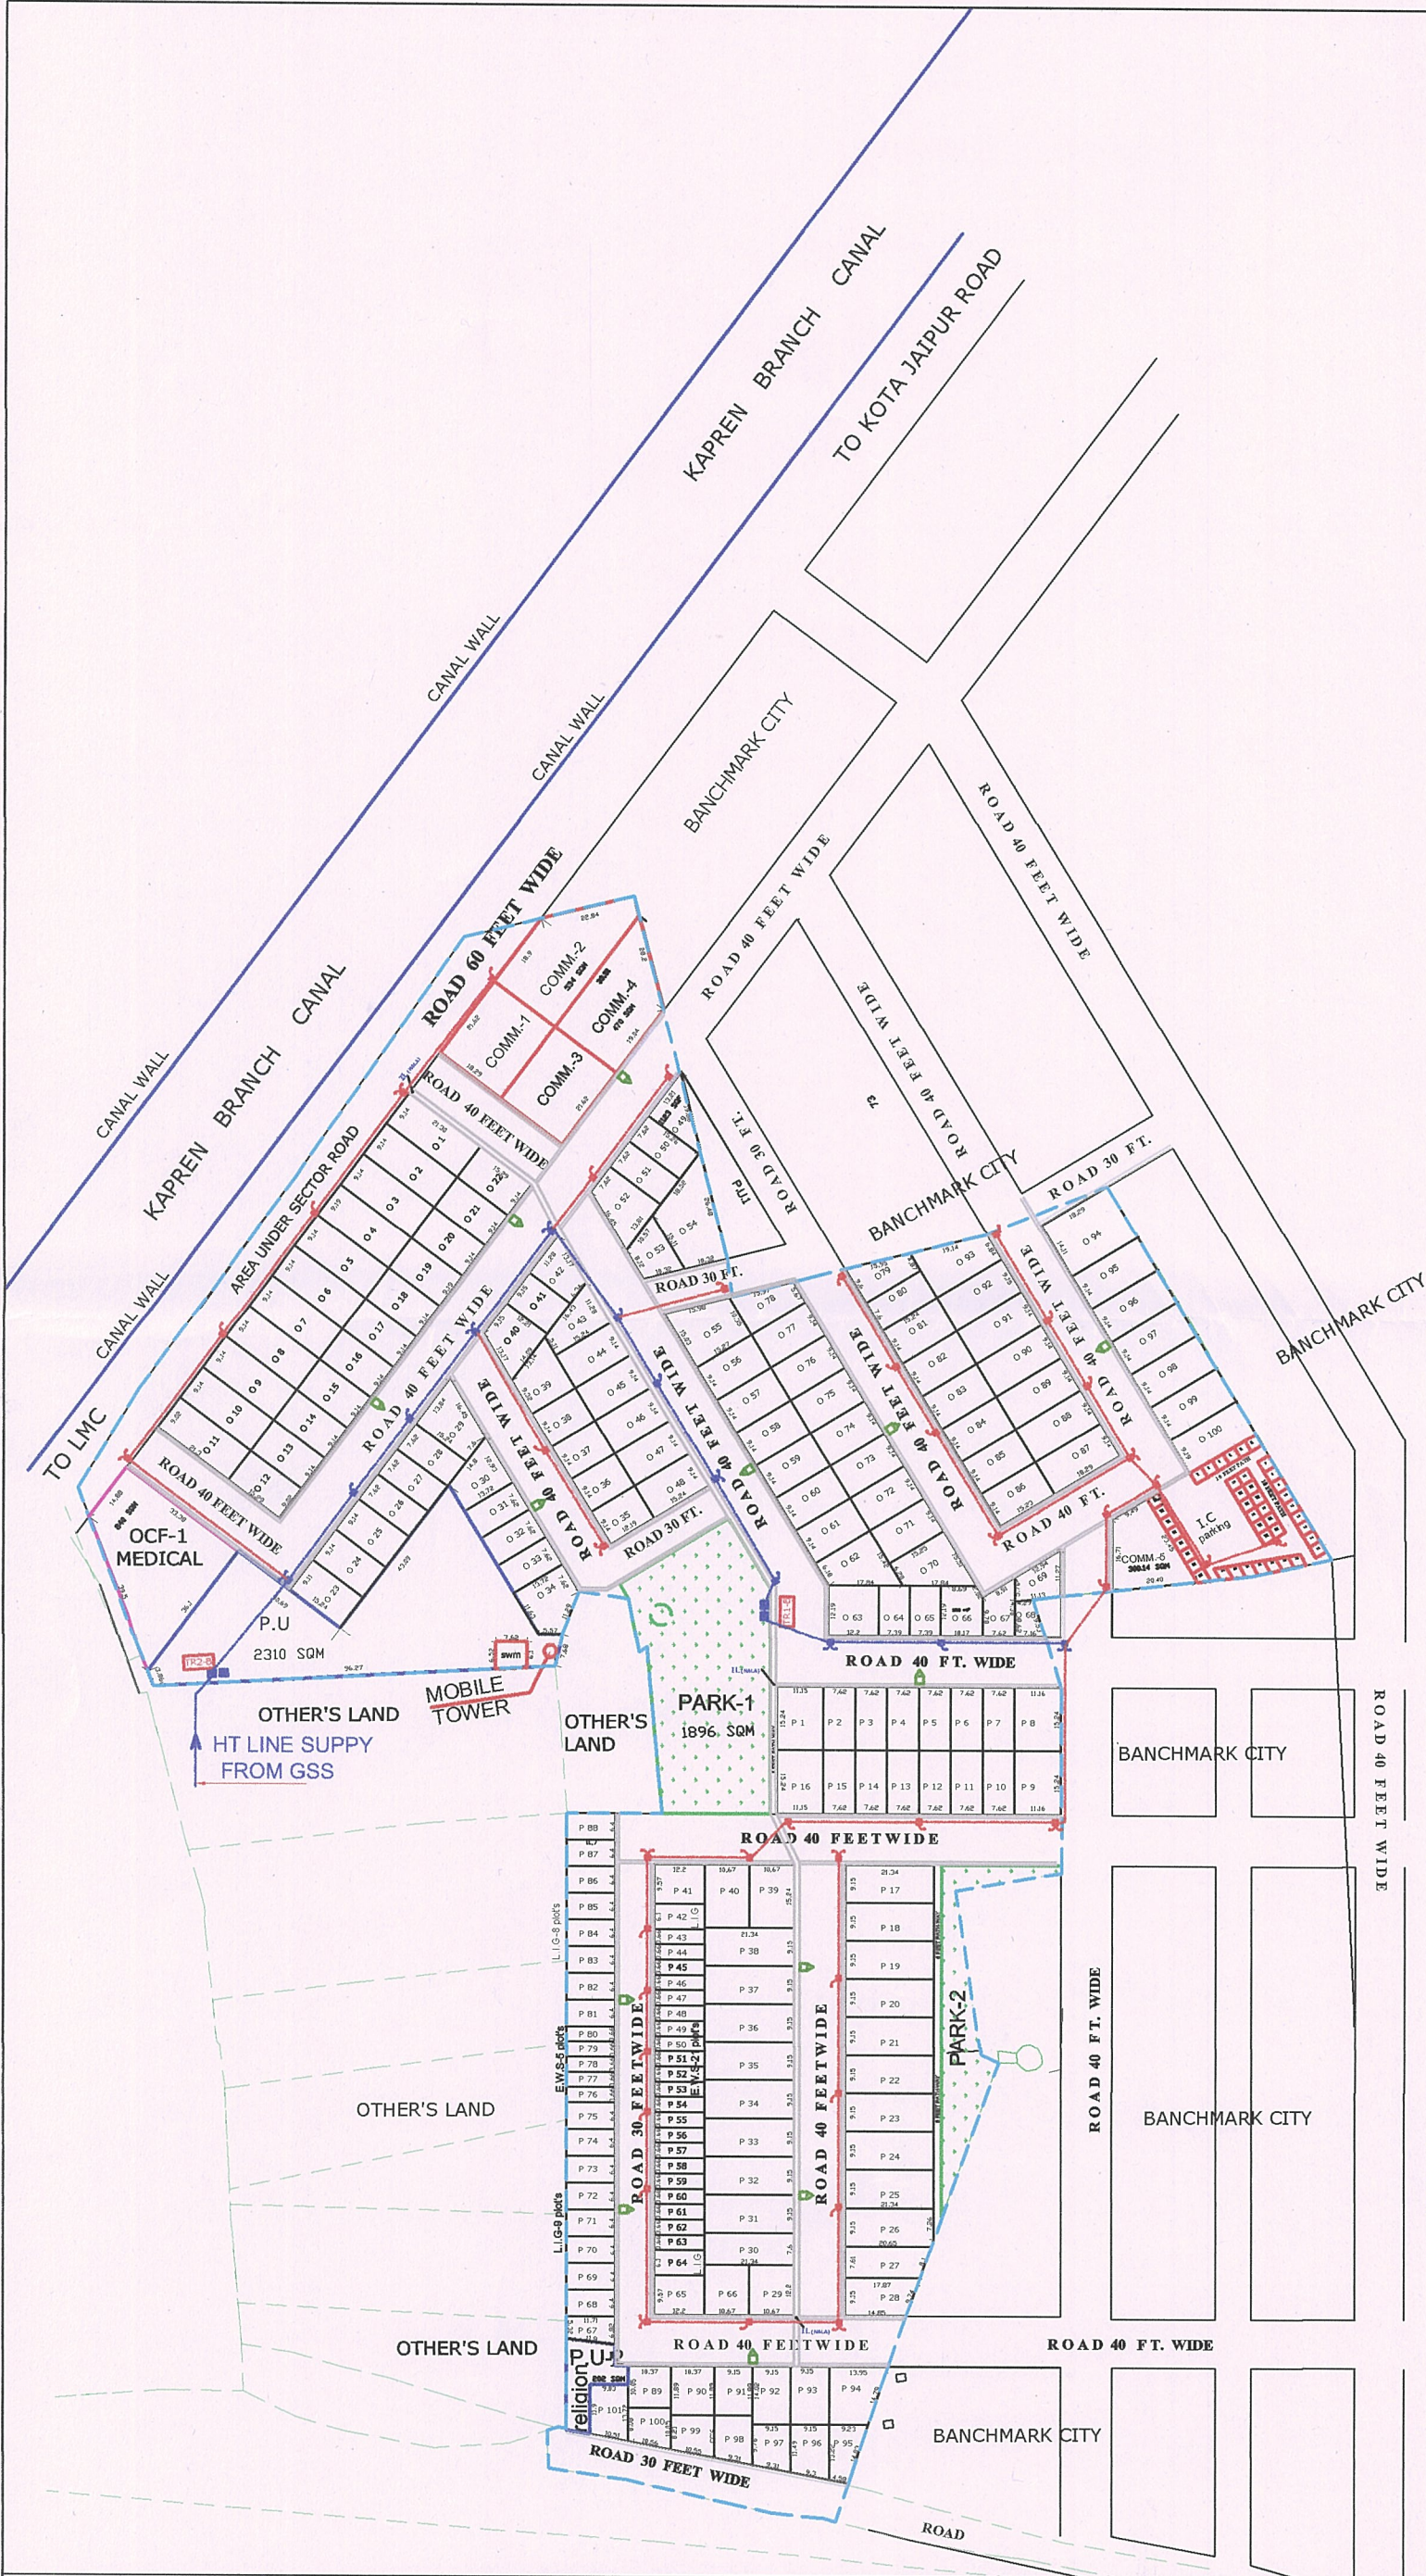

ELECTRICAL LAYOUT PLAN

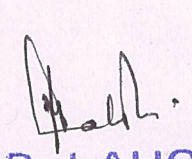
B. LAHOTI
B.E. (Civil), MIE (Arch. 1999)
Chartered Engineer No.- M-119028
Govt. Approved Valuer CAT-1/105/CCIT/63/96-97

Project
PROPOSED LAYOUT PLAN FOR
RESIDENTIAL PLOT'S SCHEME AT
VILLAGE :NAYAKHERA, TEH.
LADPURA, DIST. KOTA (RAJ.)KHASRA
NO.-507,508,509,511,514,
522,522/563,607/523,&523/1

Drawing Title
ELECTRICAL LAYOUT PLAN

SCALE : 1"=40'	NAME OF SCHEME:
LOCATION :	DRAWING NO. -
JOB NO. -	DATE - MAY, 30th, 2024