


PLOT NO. 39

PLOT NO. 46

ROAD 30'-0" WIDE

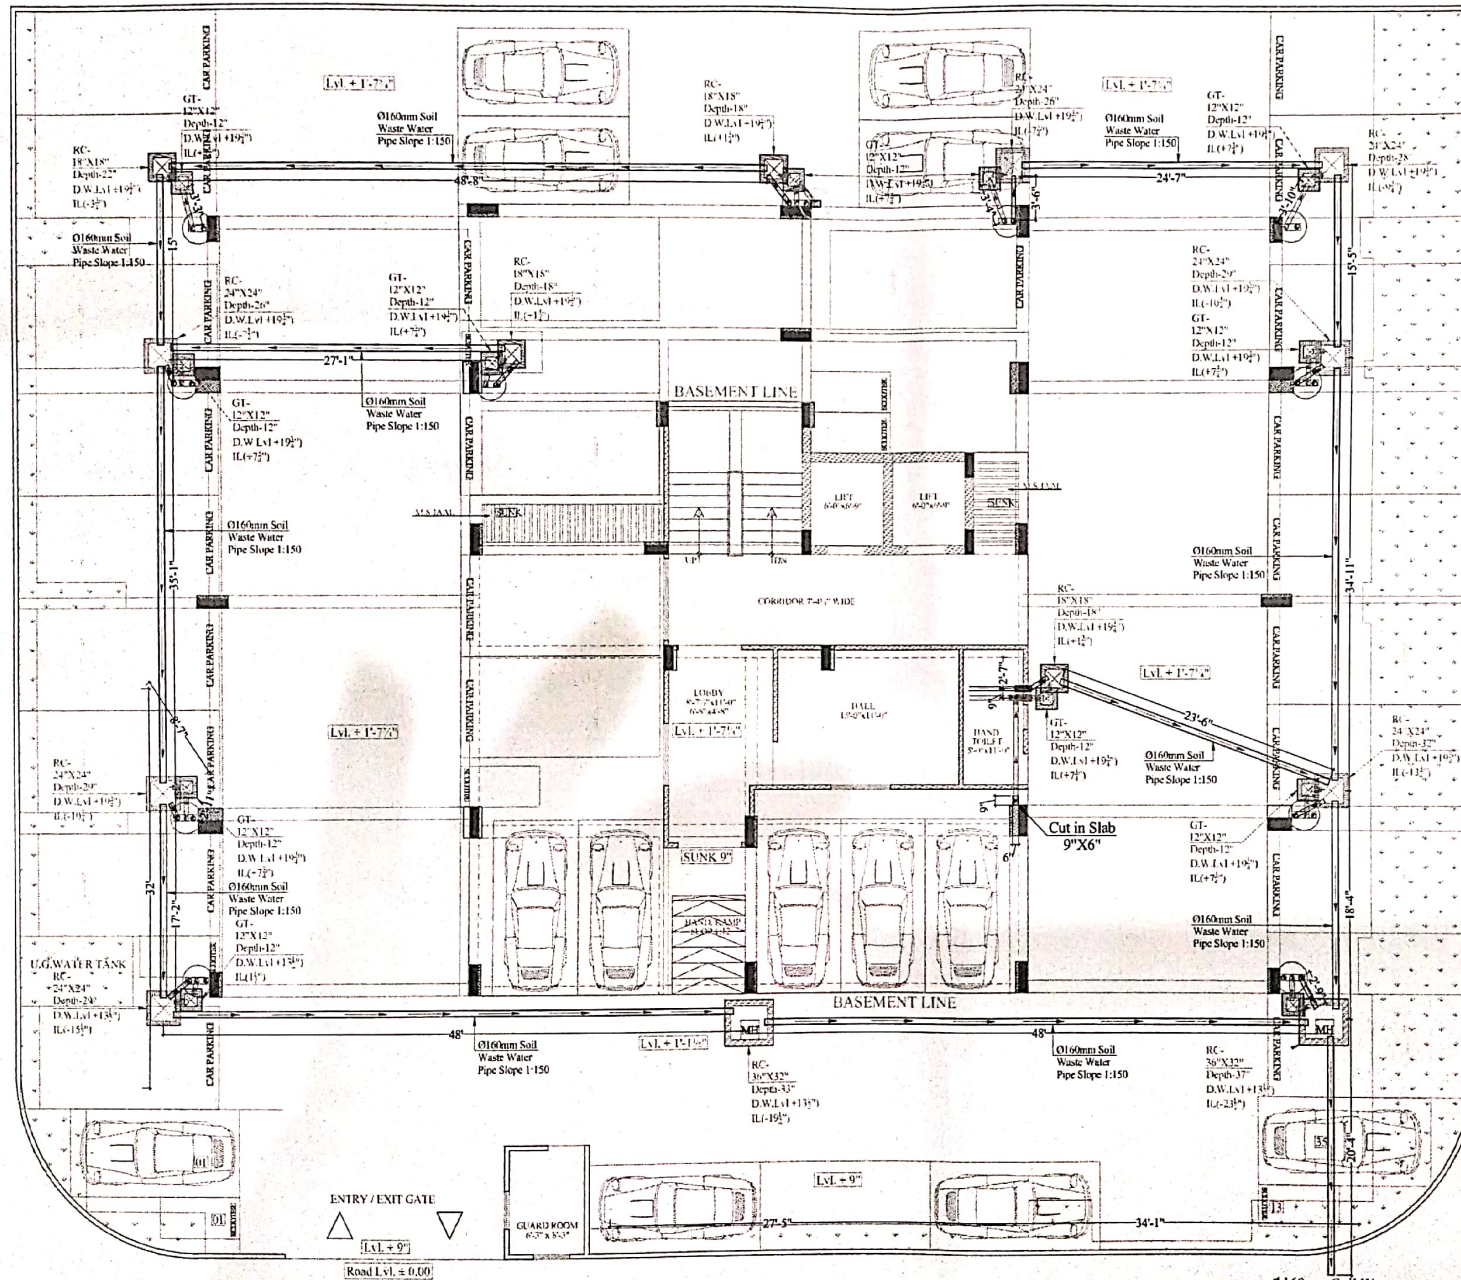

STILT FLOOR PLAN


ROAD 60'-0" WIDE

ROAD 30'-0" WIDE

SYMBOL	DESCRIPTION
	110 mm Soil Waste Water Pipe
	110 mm Waste Water Pipe
	160 mm Soil Waste Water Pipe Slope 1:150
	110 mm Soil Waste Water Pipe Slope 1:150
	110 mm Waste Water Pipe Slope 1:150
	Gully Trap 12"X12" Depth According to Slope
	Man Hole 18"X18" Depth According to Slope
	Man Hole 24"X24" Depth According to Slope
	Man Hole 36"X36" Depth According to Slope
	Flow Direction

Vgt	
VIPUL AGARWAL	
M.E.P. CONSULTANT	
B.E. ELECTRICAL	
SERVICES CONSULTANT	
ASHI ASSOCIATES	
F9/440, Keshav Marg Chitrakut Scheme, Jaipur	
Ph: 91-403146-10438, 0141-2440946 Mail: vipul8599@yahoo.co.in	
ARCHITECT :-	
SPACE GRID	
C-49, Vidya Apartment, paros Marg,	
Bapu Nagar, near Janta Store Circle,	
Jaipur-302015	
Ph-09314918766, 0141-4005506 (o)	
Email: info.spacegrid@gmail.com	
PROJECT:-	RUHEEN DAKSHINPURI
PROJECT NAME:-	RUHEEN REGAL
PROMOTER:-	RUHEEN DEVELOPERS & PROPERTIES LLP
PROJECT ADDRESS:-	PLOT NO.- 40, 41, 42, 43, 44, 45 DAKSHINPURI PHASE-I JAGATPURA, JAIPUR
DRAWING:	STILT FLOOR EXTERNAL SEWERAGE PIPE ROUTE PLAN
DRAWN BY:-	CHKD BY:-
PAWAN	SANJAY
APPD BY:-	VIPUL AGARWAL
DATE:-	REV:-
03-02-2024	00
SCALE:-	1:100



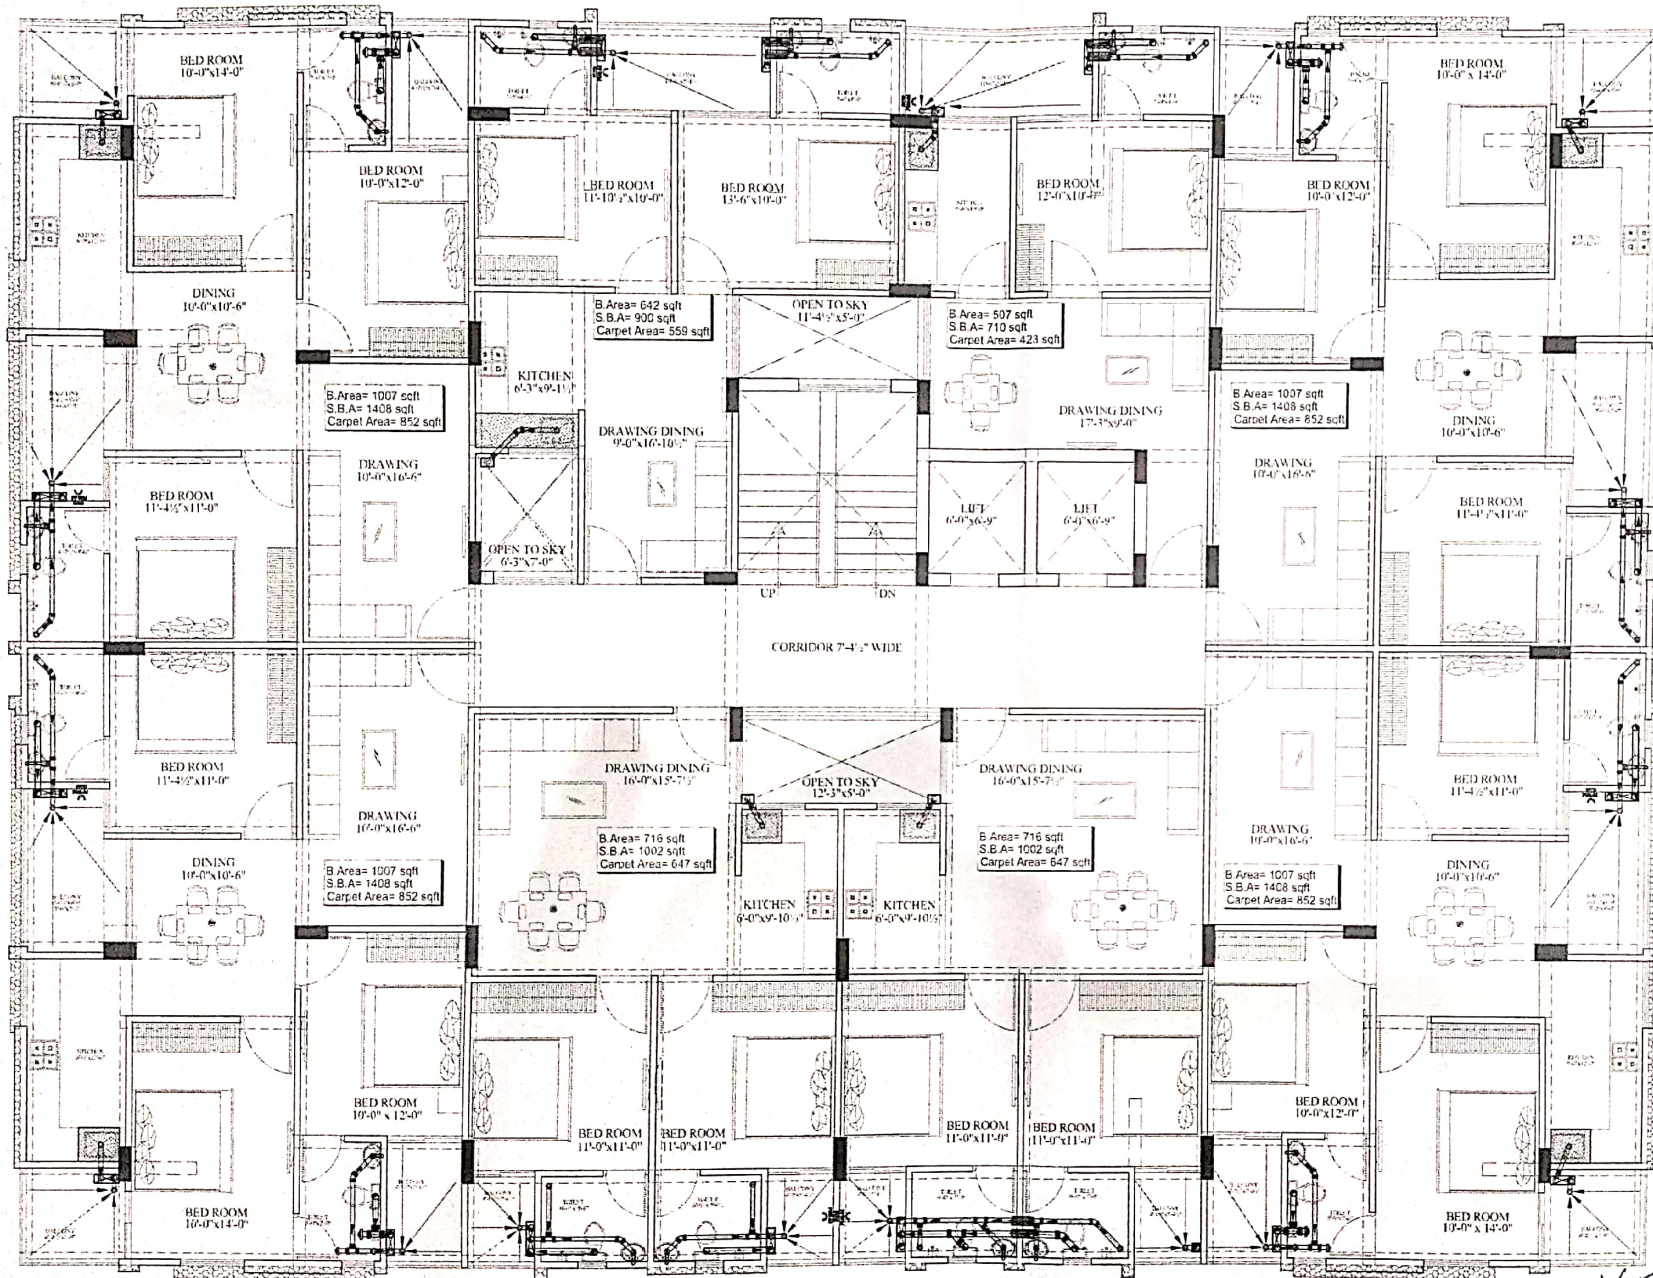

VIPUL ARJWAL
M.E.P. CONSULTANT
B.E. ELECTRICAL

SYMBOL	DESCRIPTION
	110 mm Soil Waste Water Pipe
	110 mm Waste Water Pipe
	110 mm Rain Water Pipe
	110 mm Soil Waste Water Pipe Slope 1:150
	110 mm Waste Water Pipe Slope 1:150
	110 mm Rain Water Pipe Slope 1:150
	75 mm Waste Water Pipe Slope 1:150
	75 mm Rain Water Pipe Slope 1:150
	50mm Waste Water Pipe Bottle Trap
	50mm Waste Water Pipe
	Floor Trap
	TYPICAL SHAFT
	DROPAGE SHAFT
	Flow Direction
	6\"/>
SERVICES CONSULTANT: VIPUL CONSULTING, F 9 / 440 , Keshav Marg Chitrak Scheme,Jaipur PH:91-0-93146-10438 ,0141-2440946 Mail:vipul8599@yahoo.com REV. NO. 00 DATE: 20-05-2021	
DRN. BY:-	GANGA RAM
CHK. BY:-	SANJAY
DATE :-	20-05-2021
ARCHITECT :- SPACE GRID C-49,VIDYA APARTMENT,PARAS MARG, BAPU NAGAR,NEAR JANTA STORE CIRCLE, JAIPUR-302015 PH-09314918766,0141-4005506 (O) Email:-info.spacegrid@gmail.com	
PROJECT :- PROPOSED RESIDENTIAL BUILDING AT DAKSHINPURI, JAIPUR.	
DRG. TITLE :- TYPICAL FLOOR INTERNAL DRAINAGE PLAN	
OWNER	SCALE
	 1:100