


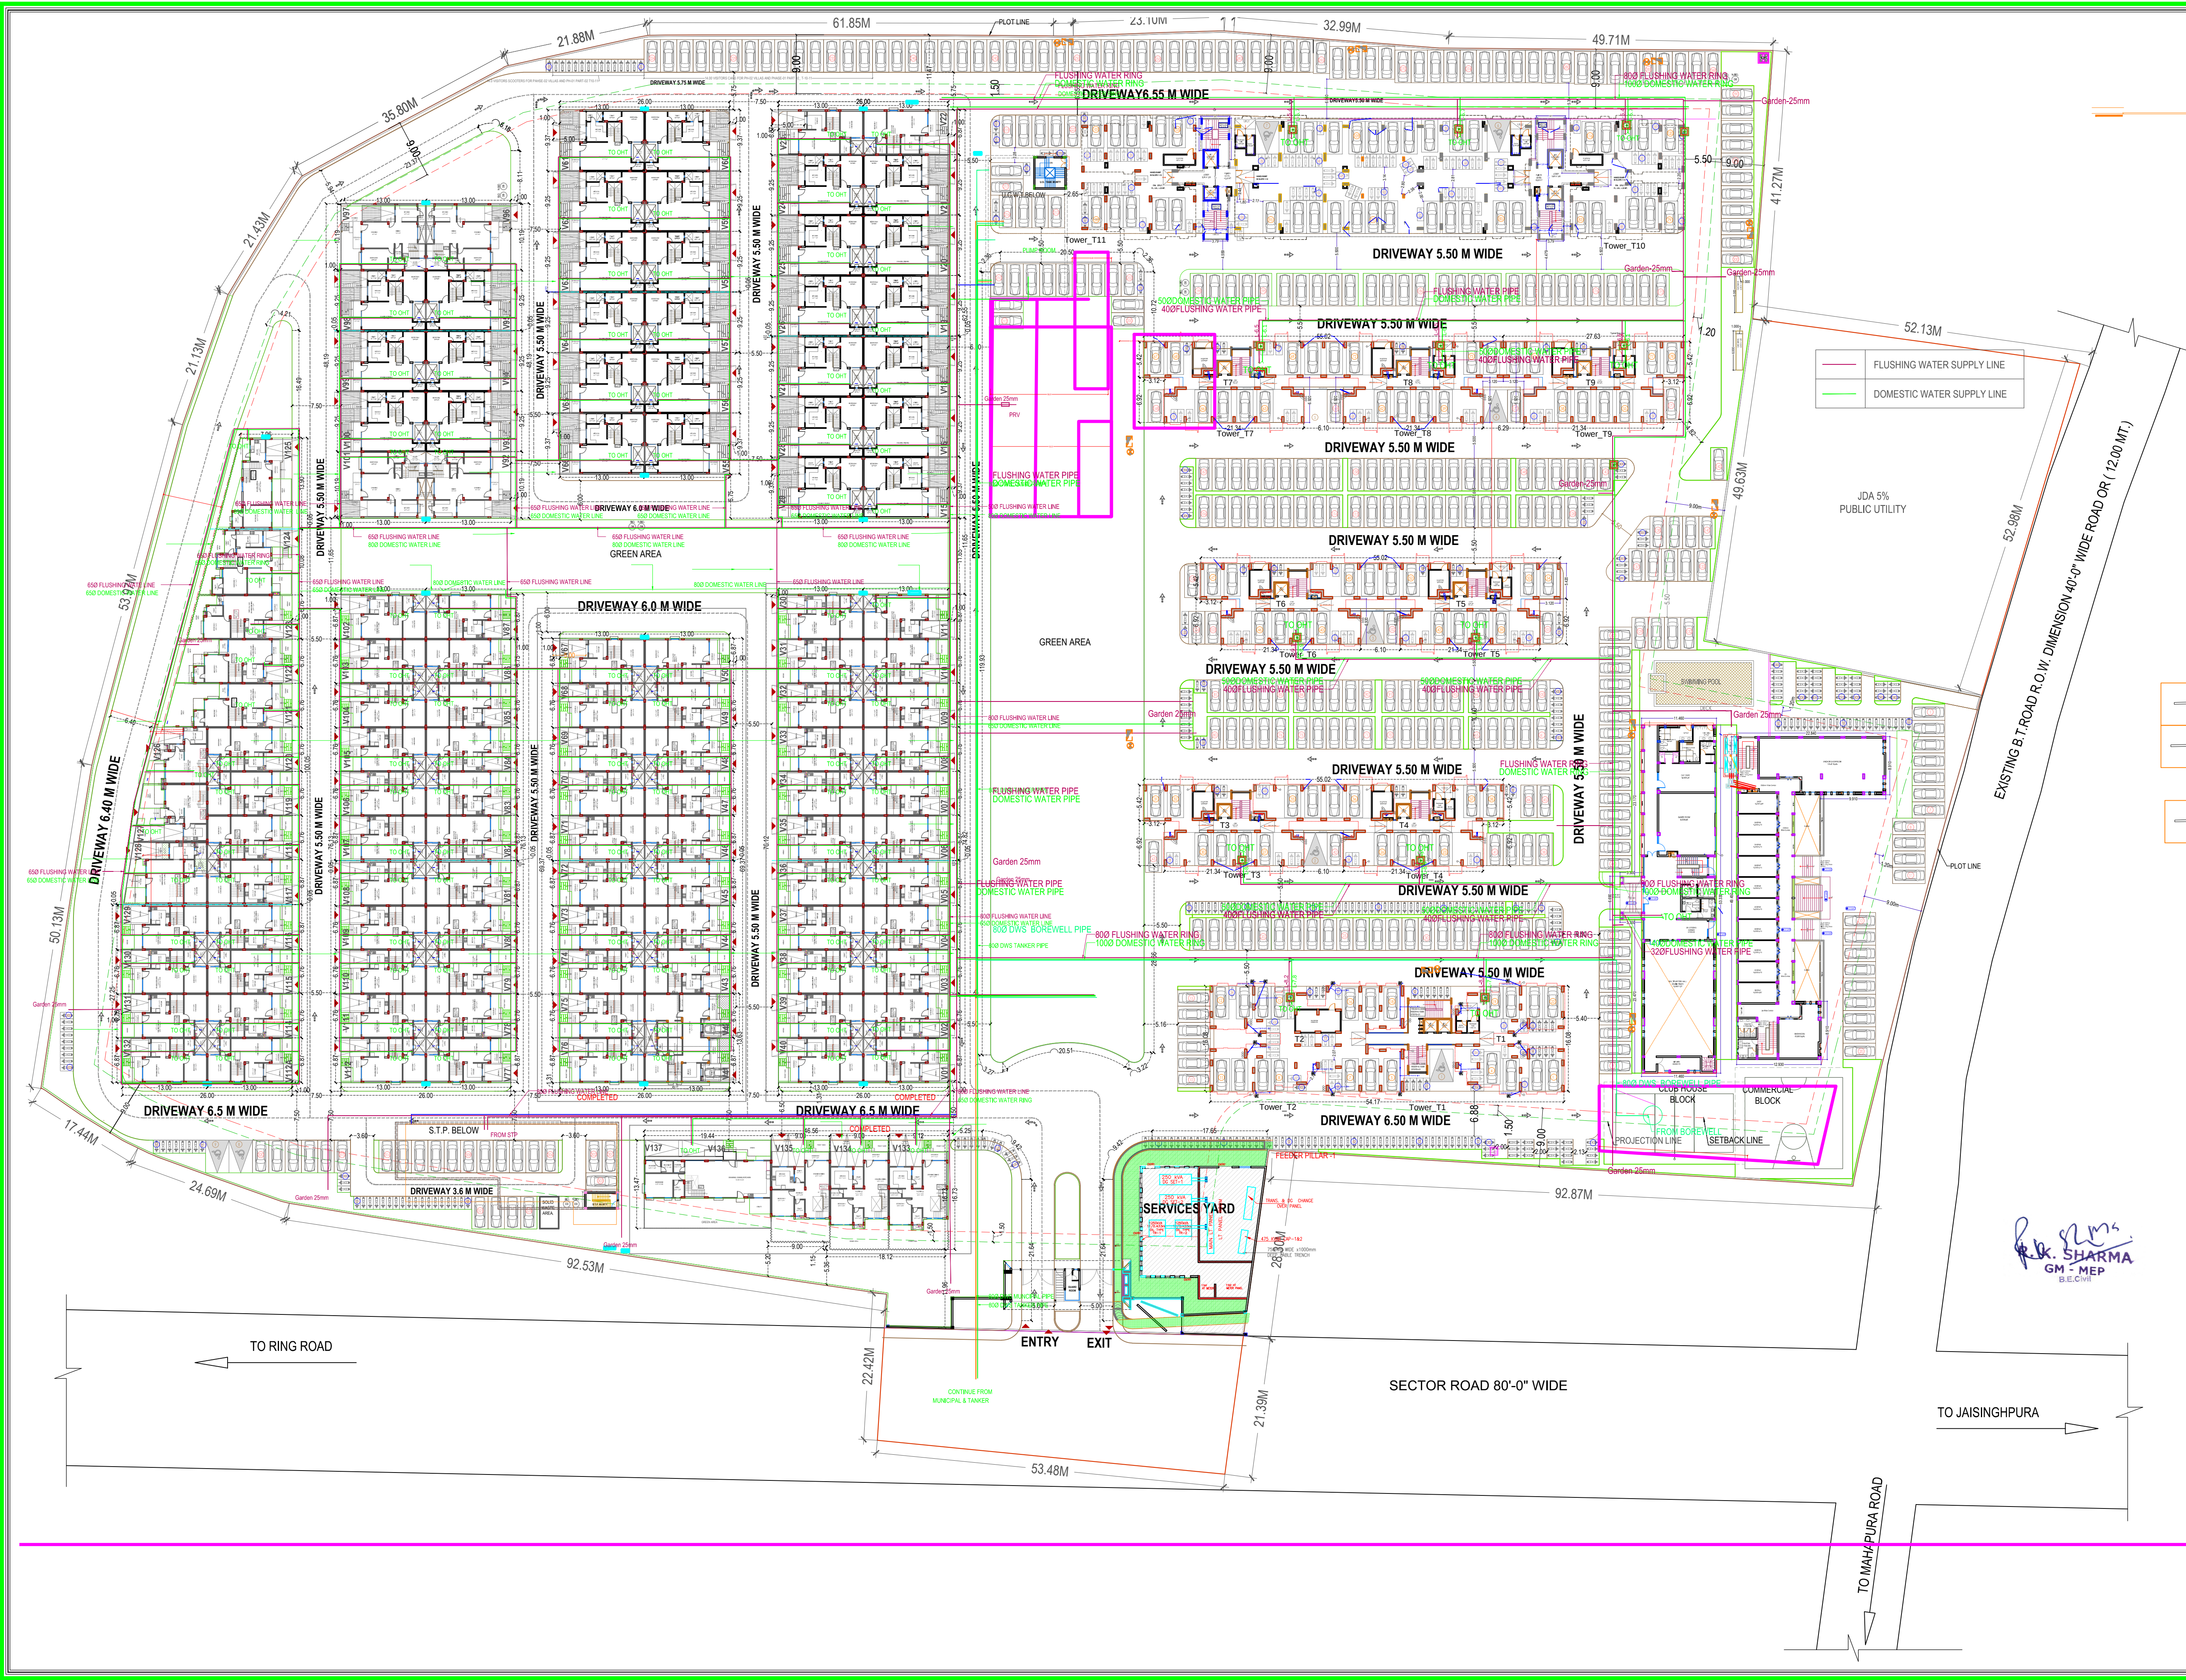

SHEET NO. 02

PARTLY C.C. AND O.C. DRAWING for
VIBH No. V-1, 10V-11, V30, 10V40, V41toV50, V67-V76 and V133-V137
STILT FLOOR PLAN

FLUSHING WATER SUPPLY LINE

DOMESTIC WATER SUPPLY LINE

JDA 5% PUBLIC UTILITY

FLUSHING WATER SUPPLY LINE

DOMESTIC WATER SUPPLY LINE

DRAWING TITLE:

EXTERNAL WATER SUPPLY LAYOUT

TITLE:

STILT FLOOR PLAN

DATE : 10/03/2021

NORTH

SCALE:- 1= 300

PROJECT:

RESIDENTIAL GROUP HOUSING
"MAHIMA SHUBH NILAY PHASE-1 (Part-2)" OF
GREEN BUILD ESTATE PVT. LTD.
IN KHASRA NO. :
129, 130, 131, 132, 133, 134, 135, 136,
137, 141, 142, 142/239, 282/138
AT REVENUE VILLAGE, CHIMANPURA,
TEH. SANGANER, JAIPUR.

ARCHITECTS:

m|a|architects pvt.ltd.
Jaipur - Bangalore - Hyderabad
Plot No. -1, greenwoods, Lal Kothi Scheme,
off Sanganer Jaipur-Jaipur-302001
Tel : 91 141 4299999, 2741232
email - studio@maarchitects.in web-www.maarchitects.in

OWNER

ARCHITECTS