



MAIN UTILITY PANEL

APFC PANEL=25KVAR
(1-2-2-5-5-10)

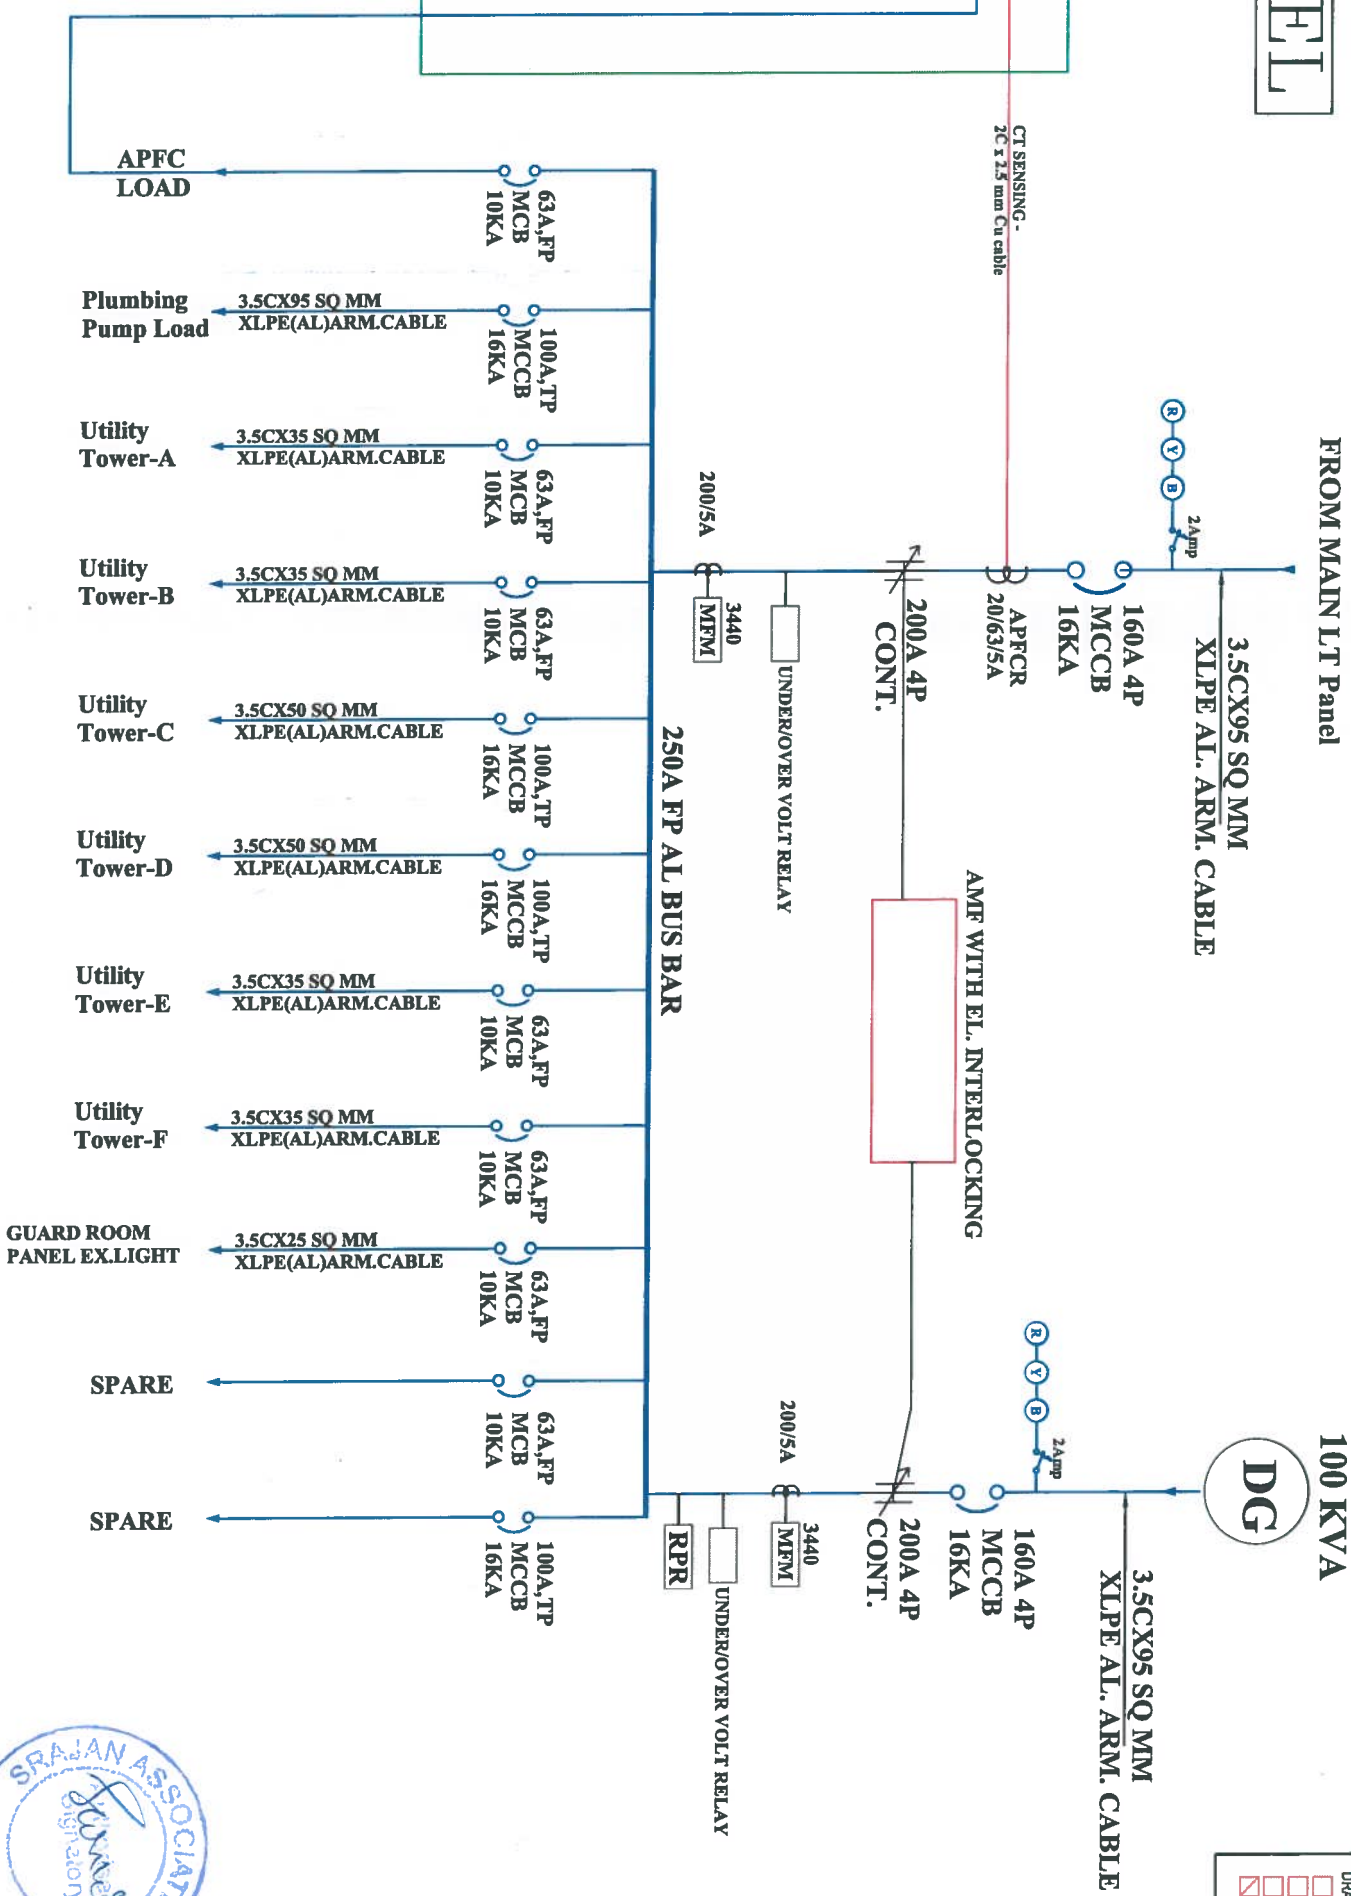

PROJECT TITLE:		TITLE:-		DATE		DEALT		CHECKED		STATUS		SERVICES CONSULTANTS		ARCHITECTS:	
ASHADEEP RUDRAKSH-01		ELECTRICAL MAIN UTILITY PANEL SLD		13-02-2021		SHARWAN		PG		FOR APPROVAL		SRAJAN ASSOCIATES C35A, LAPAT MARG C-SCHEME, JAIPUR e-mail: snajapur@hotmail.com		mlaarchitects ARCHITECTS, ENGINEERS AND INTERIOR DESIGNERS FLAT NO-1, LOH SAKHARI MARG JAIPUR-302015 TEL: 91-0141-2741232, 91-0141-2743619 TELE FAX: 91-0141-2741664 email: -studio@maarchitects.in, maarchitects@gmail.com web - www.maarchitects.in	
				DRAWING NO:- SA/MAS/9158		REV:- R0		SCALE : NTS							

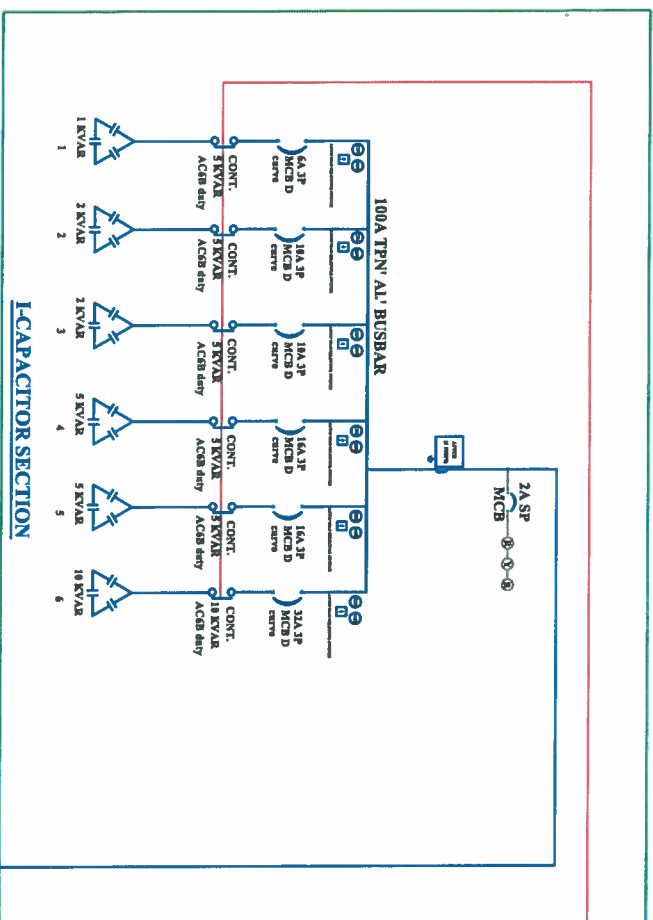

TENDER DRAWING

DRAWING:


☐ FOR TENDER

☐ FOR INFORMATION

☐ FOR EXECUTION

☒ FOR APPROVAL

METER PANEL TOWER-A,B,D&F
40 NOS 1 PHASE CONNECTIONS
(FOR LIG UNIT)

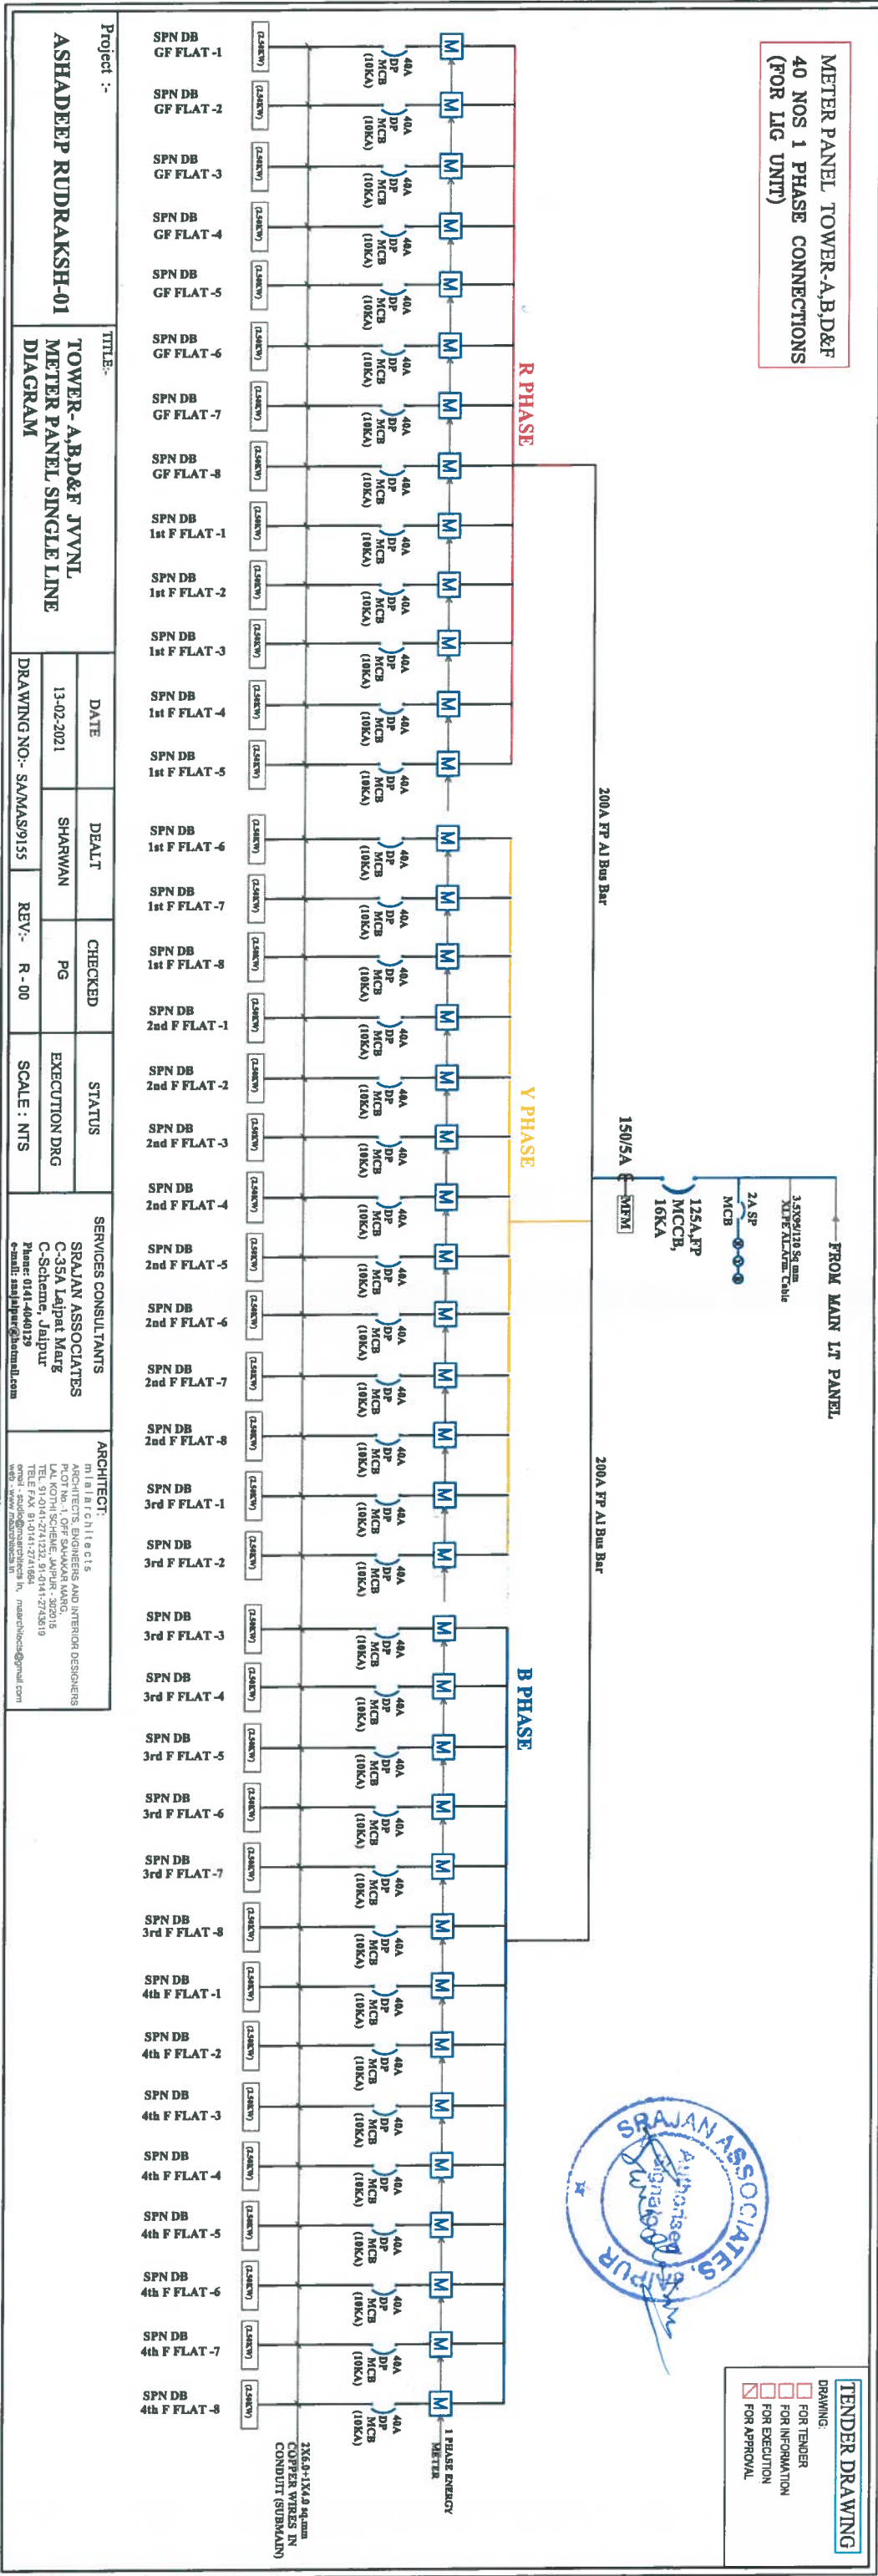

Project :-		TITLE:-	
ASHADEEP RUDRAKSH-01		TOWER-A,B,D&F JVVNL METER PANEL SINGLE LINE DIAGRAM	
DATE	DEALT	CHECKED	STATUS
13-02-2021	SHARWAN	PG	EXECUTION DRG
DRAWING NO:- SAA/MS/9155		REV:- R-00	SCALE: NTS
SERVICES CONSULTANTS		ARCHITECT:	
SRAJAN ASSOCIATES C-35A Lalpat Marg C-Scheme, Jaipur Phone: 0141-4040129 e-mail: srajanassociates@gmail.com		M.B. Architects PLOT NO. 10, SECTOR 10, VARDHANA LAL KOTHI SCHEME, JAIPUR - 302015 TEL: 91-0141-2741232, 91-0141-2743619 TELE FAX: 91-0141-2741884 WEB: www.mbaarchitects.in, mbaarchitects@gmail.com	



TENDER DRAWING

DRAWING:

☐ FOR TENDER

☐ FOR INFORMATION

☒ FOR APPROVAL


TOWER UTILITY COMMON
AREA LOAD DB DETAIL

TOWER A,B,E&F

TENDER DRAWING

DRAWING:

- ☐ FOR TENDER
☐ FOR INFORMATION
☐ FOR EXECUTION
☒ FOR APPROVAL

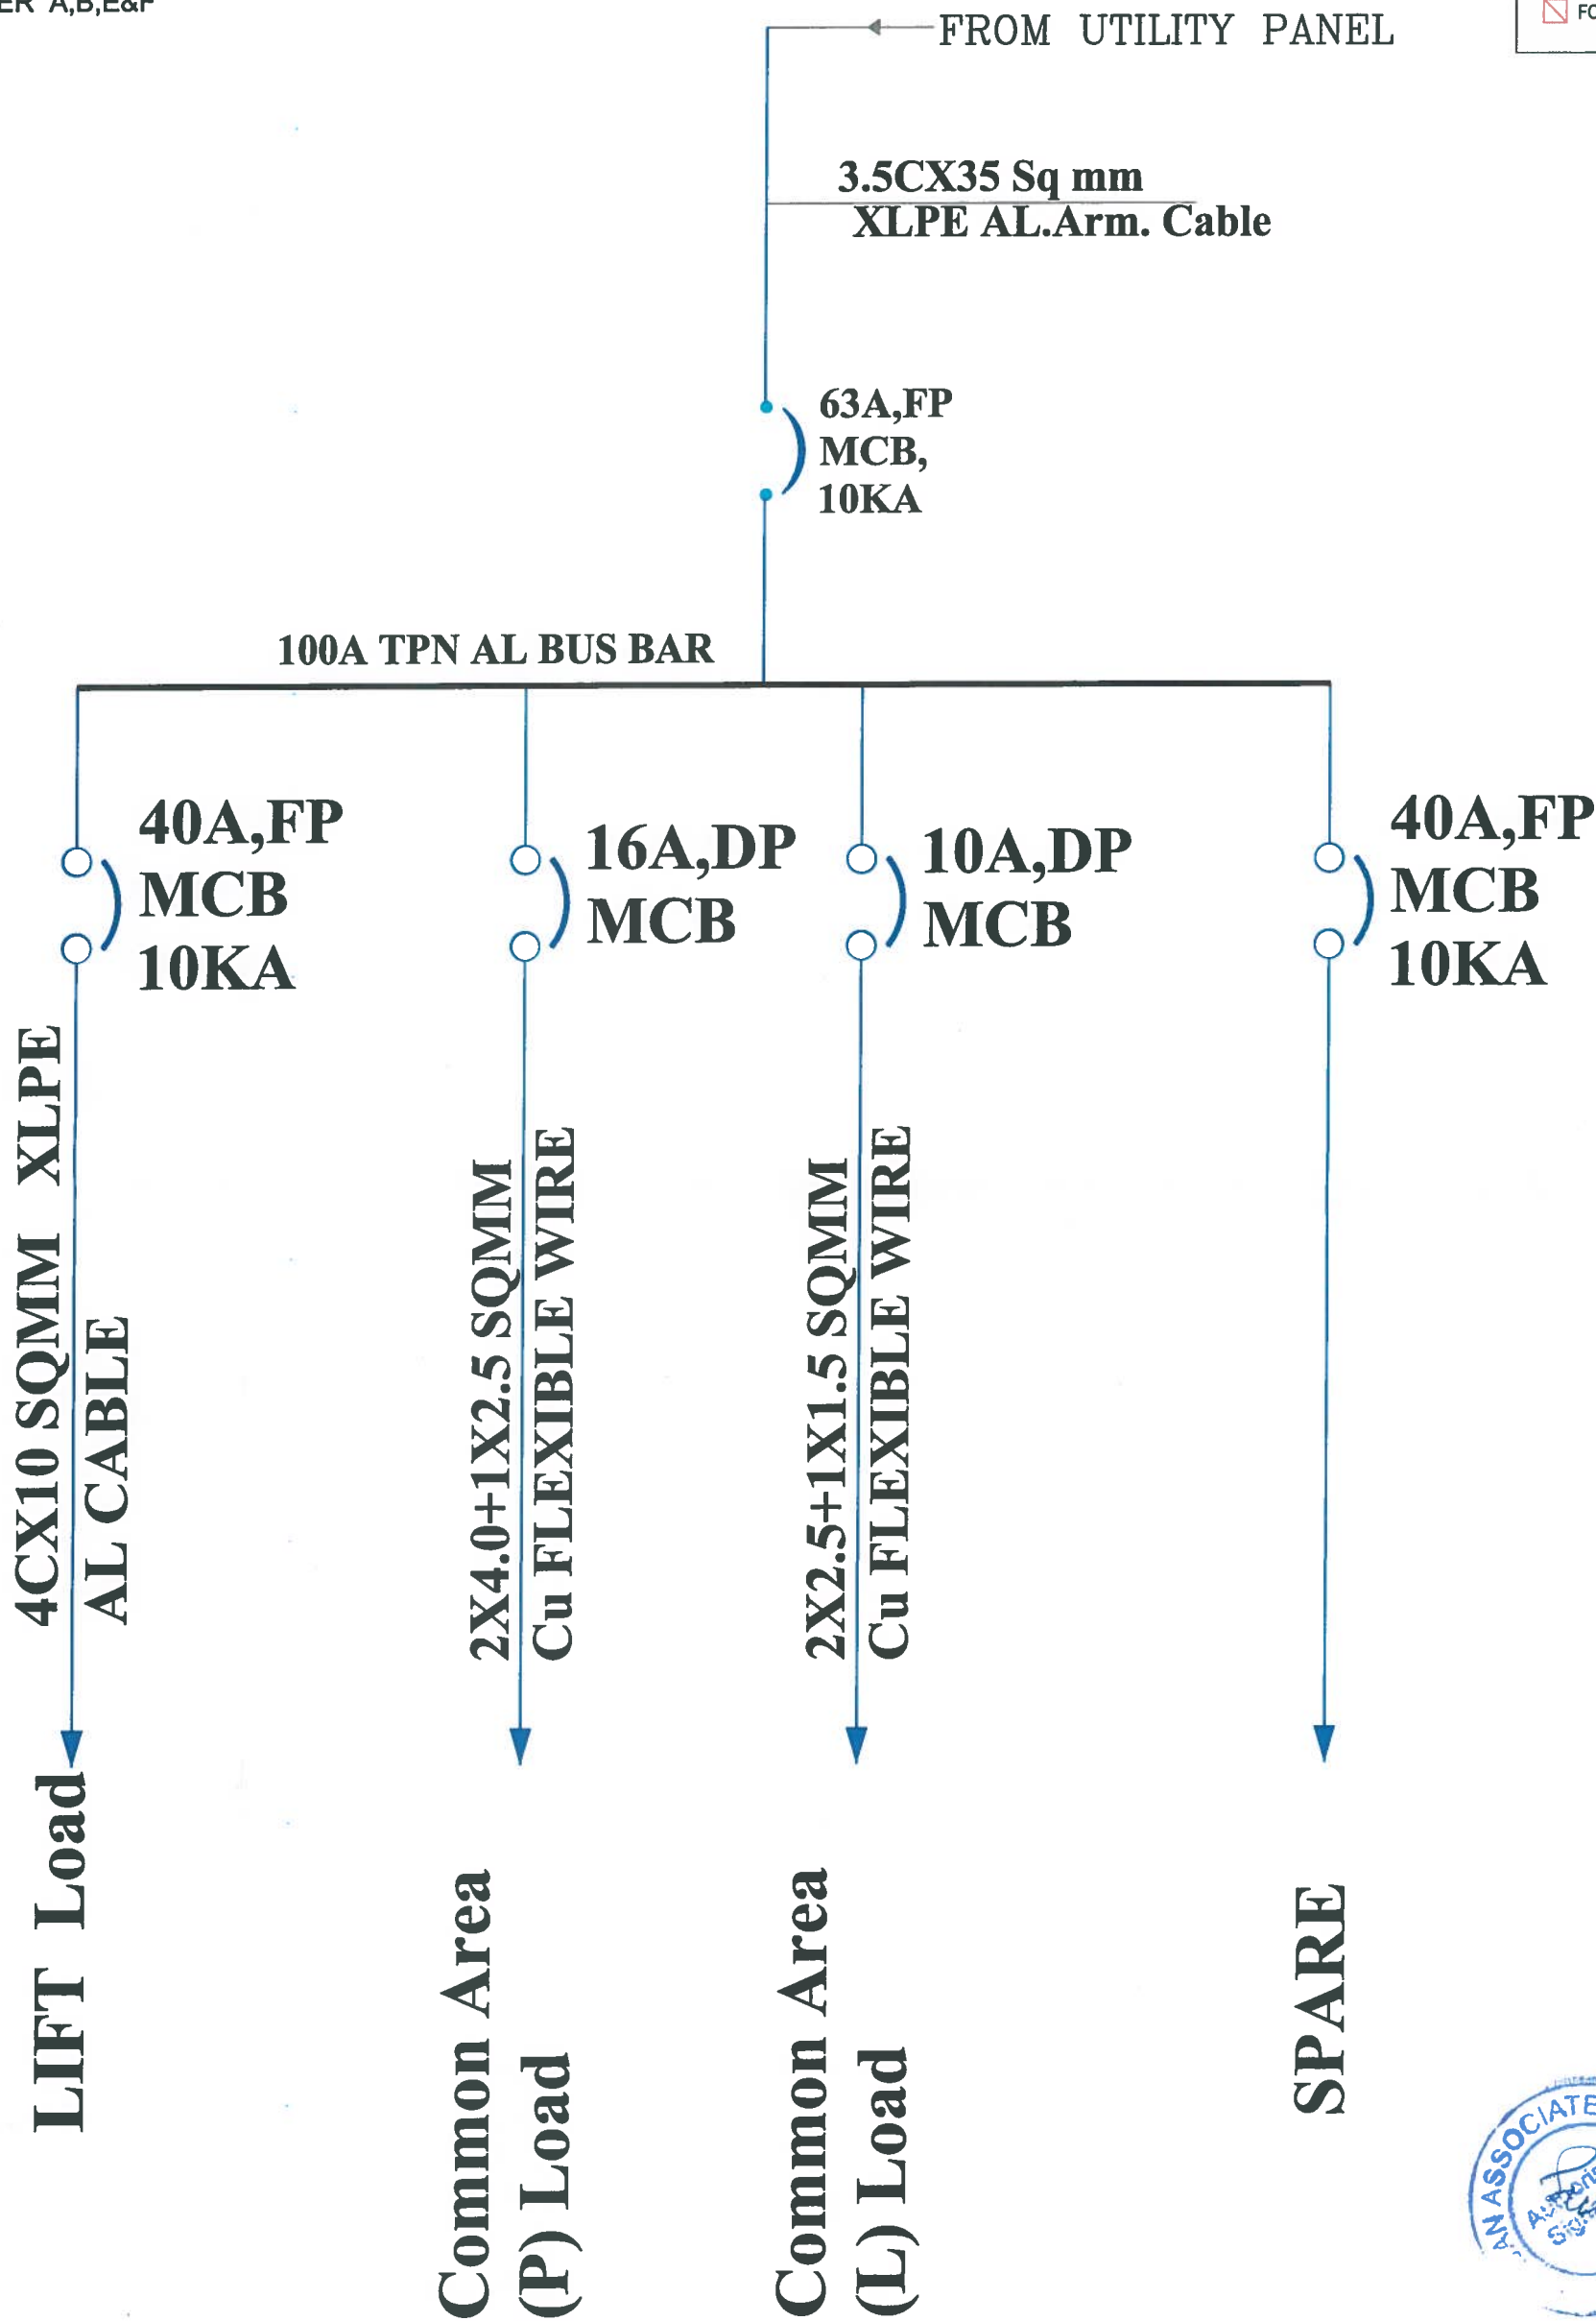

PROJECT TITLE: ASHADEEP RUDRAKSH-01	TITLE:- TOWER UTILITY COMMON AREA LOAD DB DETAIL	DATE	DEALT	CHECKED	STATUS	SERVICES CONSULTANTS SRAJAN ASSOCIATES C35A, LAJPAT MARG C-SCHEME, JAIPUR e-mail: snajipur@hotmail.com	ARCHITECTS: mlaarchitects ARCHITECTS, ENGINEERS AND INTERIOR DESIGNERS PLOT No.-1, OFF SAHAKARI MARG, LAL KOTHI SCHEME, JAIPUR - 302015 TEL: 91-0141-2741232, 91-0141-2743619 TELE FAX: 91-0141-2741604 email - studio@mlaarchitects.in, mlaarchitects@gmail.com web - www.mlaarchitects.in
		13-02-2021	SHARWAN	PG	FOR APPROVAL		
		DRAWING NO:- SA/MAS/9159		REV:- R0	SCALE : NTS		


TOWER UTILITY COMMON
AREA LOAD DB DETAIL

TOWER C & D

TENDER DRAWING

DRAWING:

- ☐ FOR TENDER
- ☐ FOR INFORMATION
- ☐ FOR EXECUTION
- ☒ FOR APPROVAL

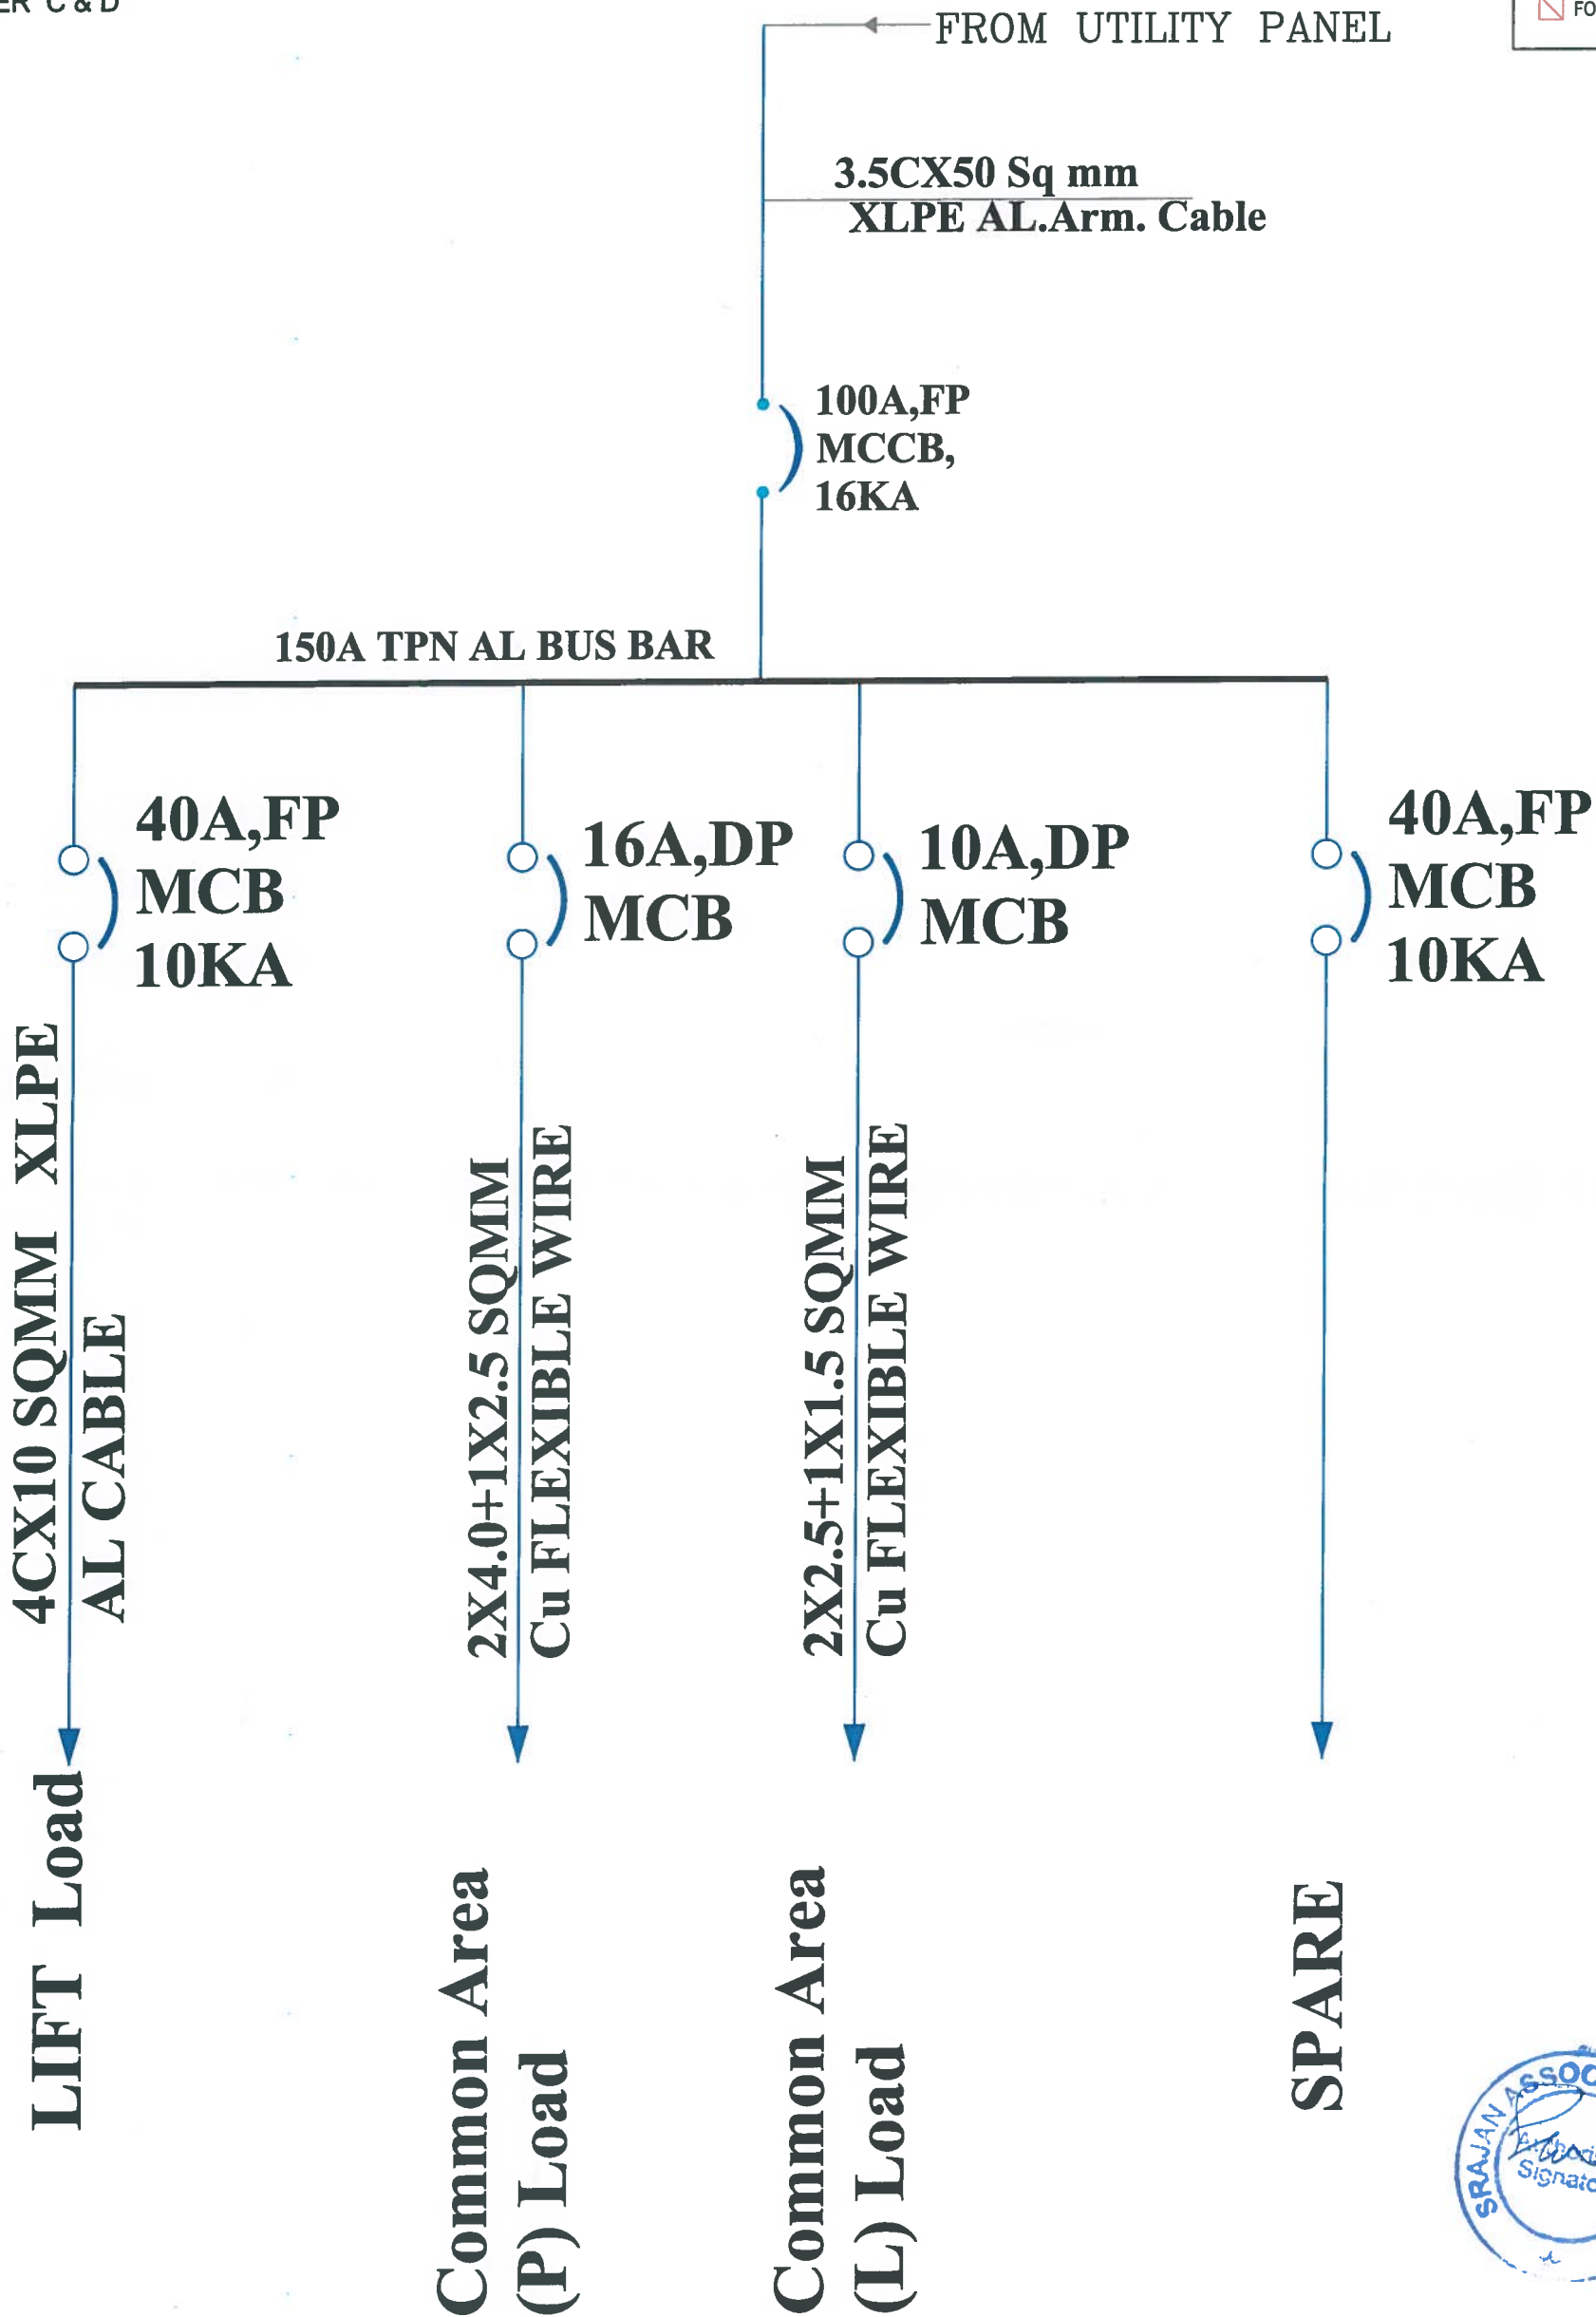

PROJECT TITLE: ASHADEEP RUDRAKSH-01	TITLE:- TOWER UTILITY COMMON AREA LOAD DB DETAIL	DATE	DEALT	CHECKED	STATUS	SERVICES CONSULTANTS SRAJAN ASSOCIATES C35A, LAJPAT MARG C-SCHEME, JAIPUR e-mail: snajaipur@hotmail.com	ARCHITECTS : mla architects ARCHITECTS, ENGINEERS AND INTERIOR DESIGNERS PLOT No-1, OFF SAHAKAR MARG, LAL KOTHI SCHEME, JAIPUR - 302015 TEL: 91-0141-2741232, 91-0141-2743619 TELE FAX: 91-0141-2741664 email - studio@mlaarchitects.in, mlaarchitects@gmail.com web - www.mlaarchitects.in
		13-02-2021	SHARWAN	PG	FOR APPROVAL		
		DRAWING NO:- SA/MAS/9160		REV:- R0	SCALE : NTS		