


130'-10 1/2"

90'

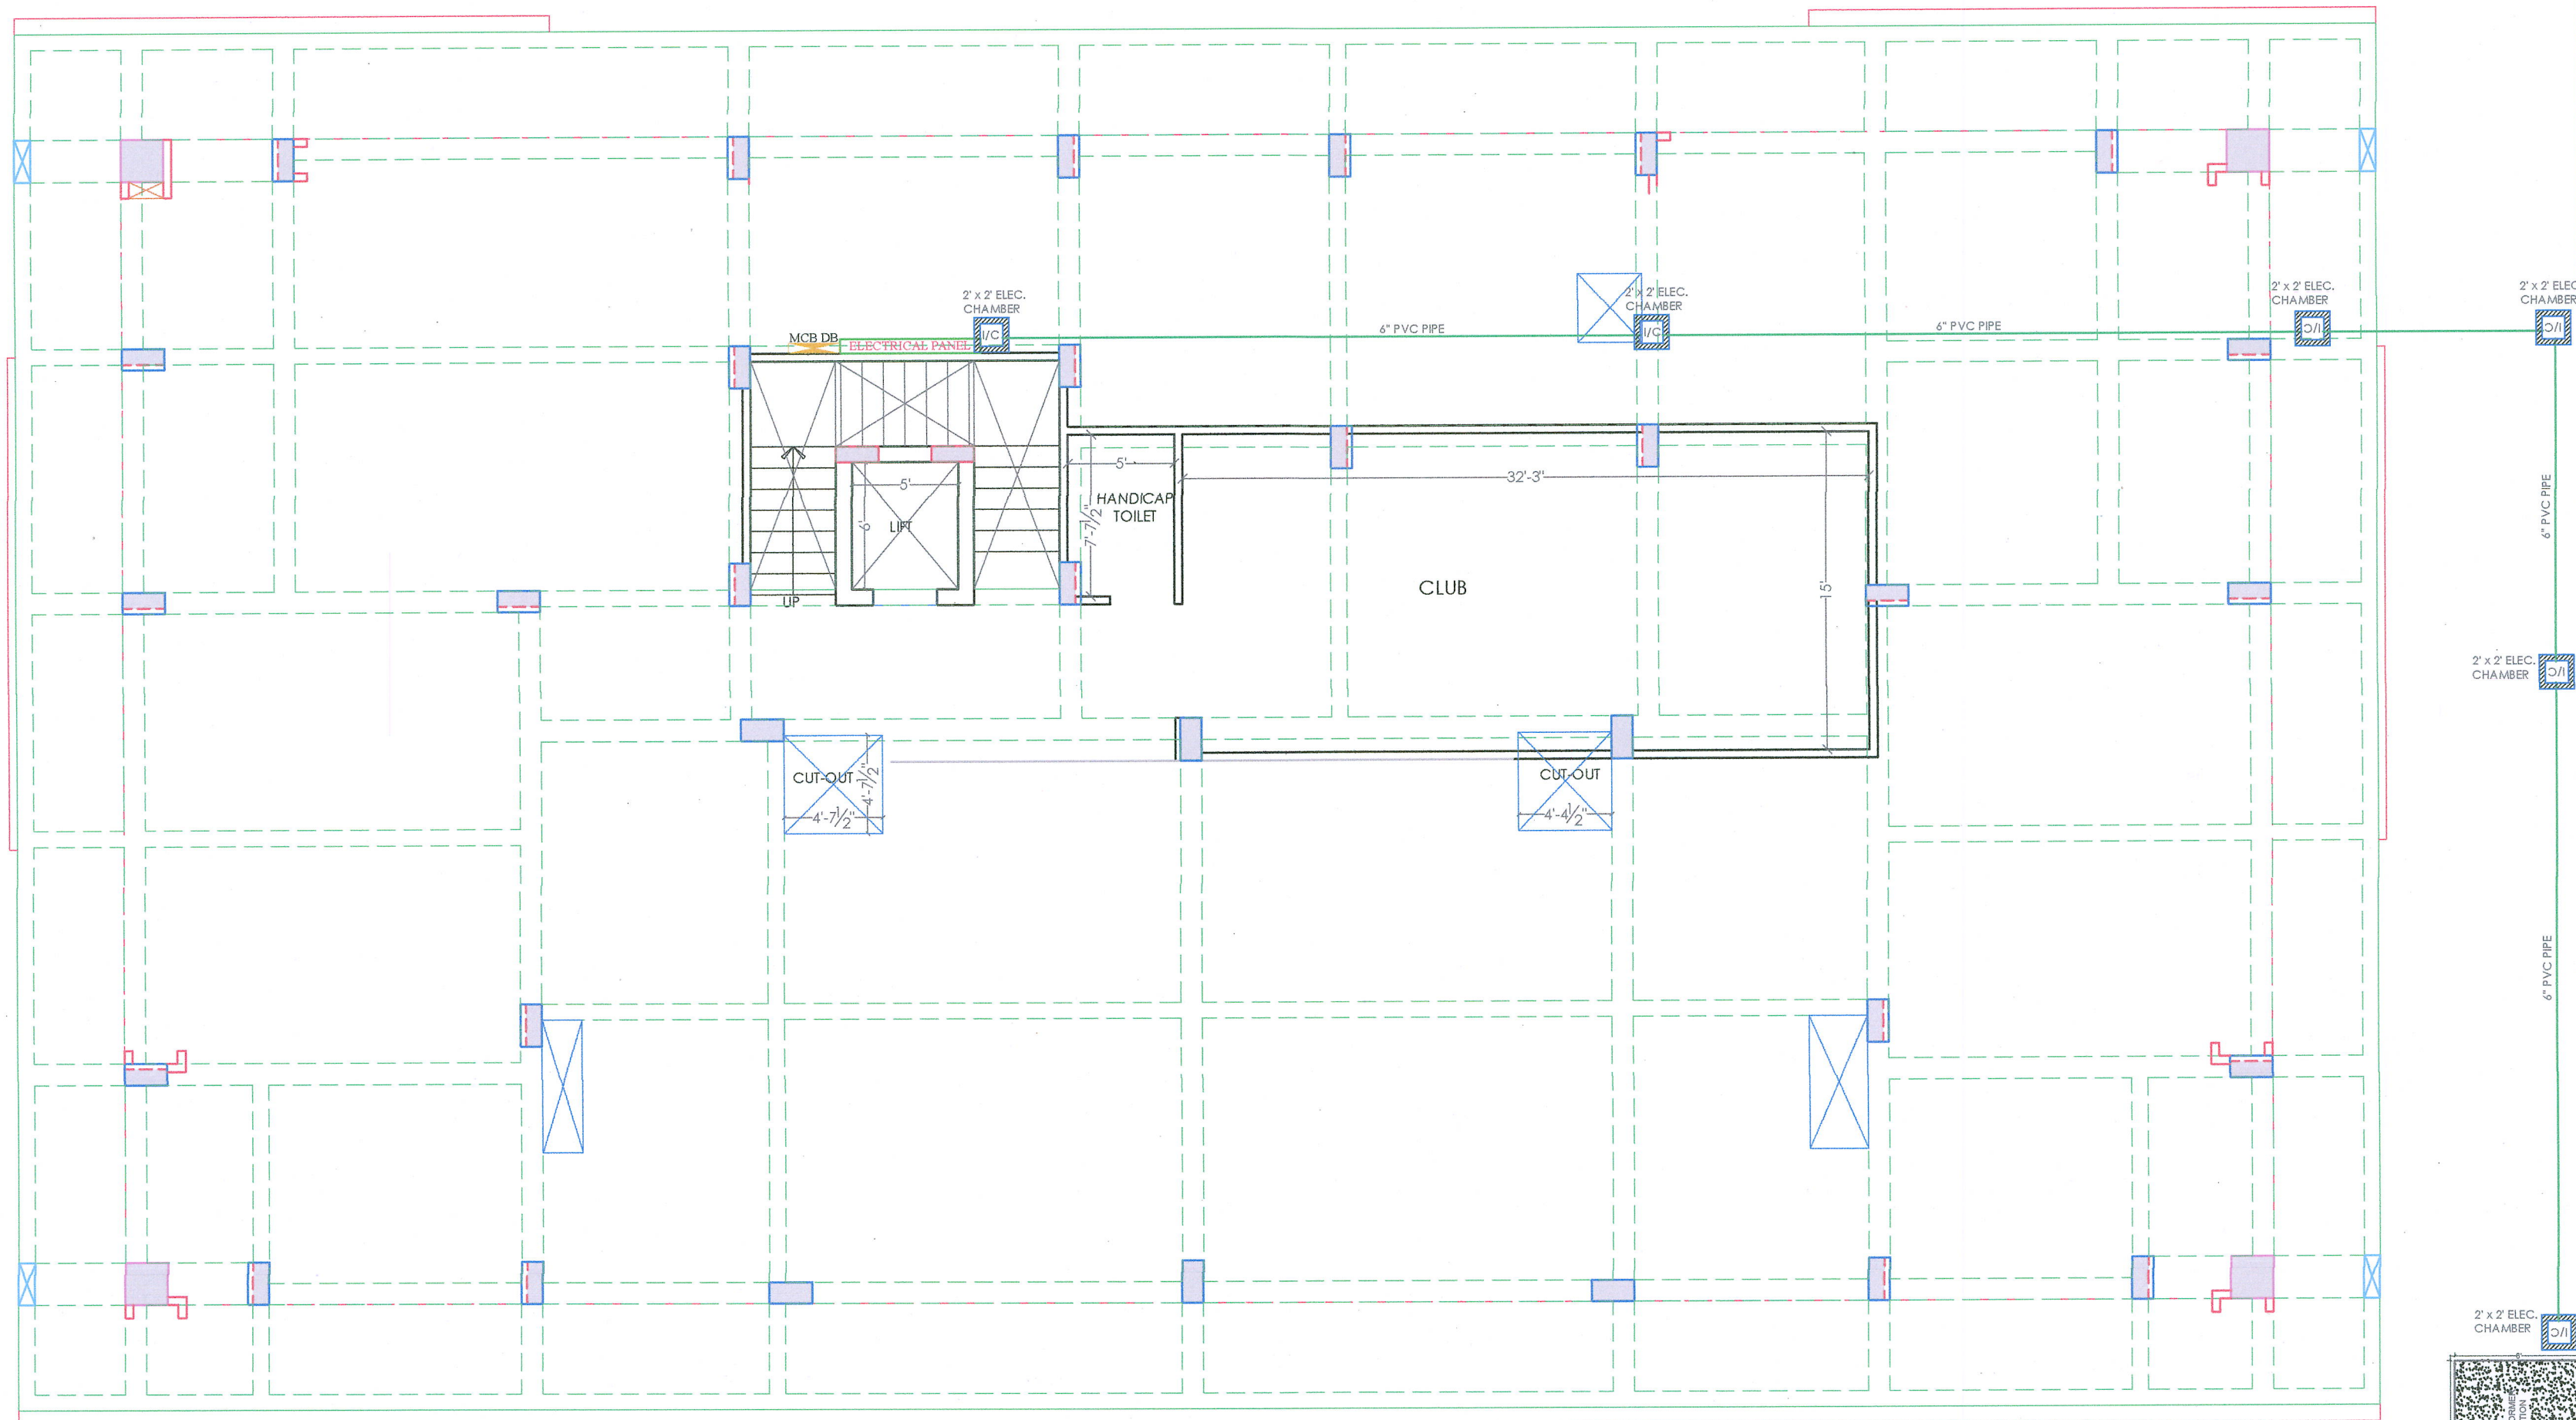

STILT FLOOR ELECTRICAL ROUTE LAYOUT (TRANSFORMER, RMU, METER PANEL, ELECTRICAL CABLE)

Er. Sanjeev Sharma
B.E. (Electrical)

M/s RGB HEIGHTS
PARTNER

PROJECT NAME:-
RGB HEIGHTS

DEVELOPER NAME:-
RGB HEIGHTS

ARCHITECTS :
4 INSIDE
ARCHITECTURE N INTERIORS
Plot no. 72, S.P. Marg, C- Scheme
jaipur, rajasthan, India
cont: +91 9950595991, 91
9982812777
e.mail: jeets.arch@gmail.com

LEGENDS:			
Mounting Height	ID	Symbol	Description
CEILING	FAN 4"		CEILING FAN 4"
CEILING	FAN 30"		CEILING FAN 30"
CEILING	CH		CHANDOLIER
+93"	TL/W		Lat Wall Tube Light
+93"	BCLD		Lat Bulb 20W
+93"	GL		WALL BRACKETS AS DISKIN FOR GANESH LIGHT
+78"	ML		12x2 Lat Mirror Light
CEILING	DL		Lat 4" Down Lighter 20W (Studen Mount)
VENTILATOR HT.	CR		CEILING ROSE
VENTILATOR HT.	EXP		9" DIA FRESH AIR FAN
+24"	2wSB		2w SWITCH BOARD
+42"	SB		SWITCH BOARD (6A SOCKET & SWITCH)
+24"	TEL		TELEPHONE POINT
+24"	LP TEL		6A PLUG POINT FOR TELEPHONE
+48"	TV		TV COAXIAL POINT
+48"	LP TV		6A PLUG POINT FOR TV
+24"	LP		6A PLUG POINT FOR SIDE TABLE
+72"	LP CB		6A PLUG POINT FOR CHIMNEY
+12"	LP PC		6A PLUG FOR COMPUTER POINT
+93"	SAC		SPLIT AC INDOOR UNIT
+42"	PP-MIX		16A POWER POINT FOR MIXER
+42"	PP-MIC		16A POWER POINT FOR MICROPHONE
+78"	PP-Q		16A POWER POINT FOR GEYSER
+54"	PP-F		16A POWER POINT FOR FRIDGE
+78"	PP-WP		16A POWER POINT FOR WATER PURIFIER
+48"	PP-WM		16A POWER POINT FOR WASHING MACHINE
+12"	PP-INV		16A POWER POINT FOR INVERTER
+93"	PP-AC		25A SWITCHES FOR AC
	VC		CHAMBER (2' x 2')
+18"			6A 2 NOE SOCKET + 1 NOE 6A SWITCH, 15 AMPERE
+65"	MCB DB		MCB DISTRIBUTION BOARD
			CAMERA
			WALL FAN
BSB			6A 5/5 FAN REGULATOR, TL SWITCH
BAC			6A 5/5 25 AAC

PROJECT:
PROPOSED RESIDENTIAL FLATS ON PLOT NO.-R10/71, R10/72 & R10/73, SCHEME - "INDRAPRAST COLONY AJMER ROAD, JAIPUR"

NAME OF DRAWING: STILT FLOOR ELECTRICAL ROUTE LAYOUT (TRANSFORMER, RMU, METER PANEL, ELECTRICAL CABLE)

DRAWN BY: JITENDRA SHARMA

DRAWING: NORTH:

PROJECT NO.: DATE: 26-11-2021


SCALE: NTS REV NO.: R-0

DRAWING NO.:

PROJECT	CATEGORY	BLOCK	FLOOR	TYPE	NUMBER

130'-10 1/2"

90'

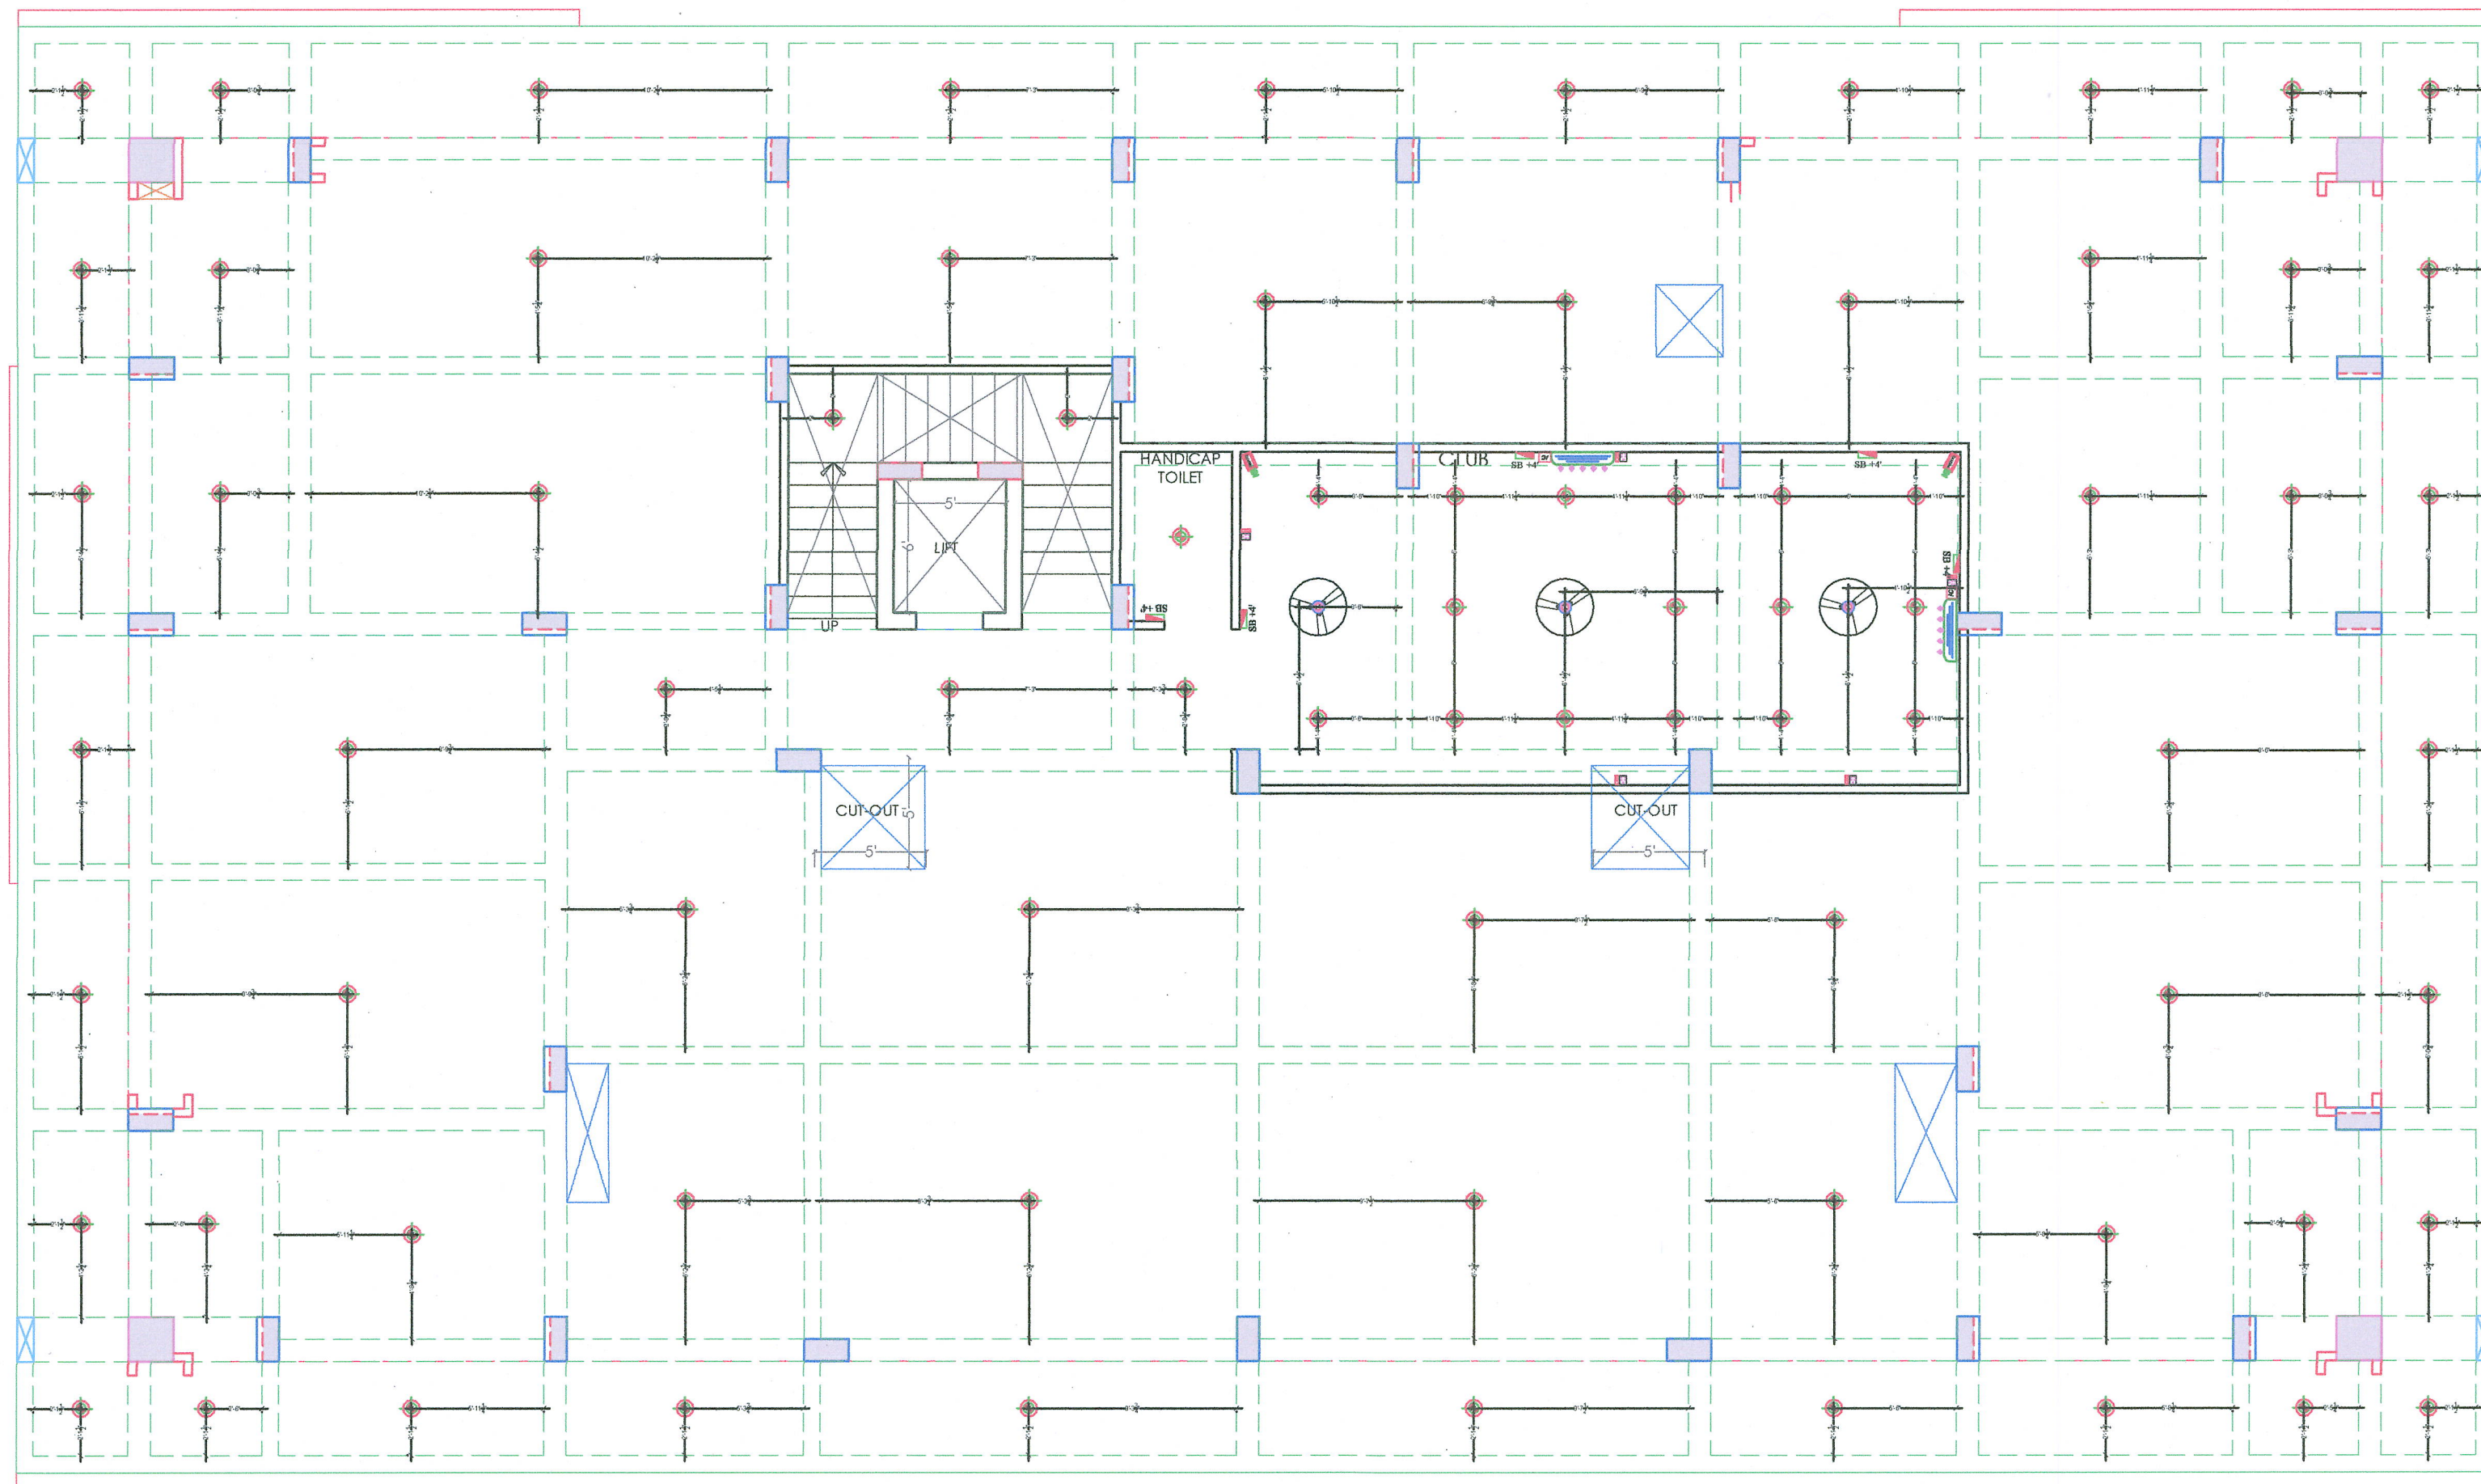

STILT FLOOR CEILING ELECTRICAL LAYOUT, ELECTRICAL POINT DRAWING, CAMERA POINT DRAWING

Er. Sanjeev Sharma
Er. Sanjeev Sharma
B.E. (Electrical)

M/s RGB HEIGHTS
PARTNER

PROJECT NAME:-
RGB HEIGHTS

DEVELOPER NAME:-
RGB HEIGHTS

ARCHITECTS :
4 INSIDE
ARCHITECTURE N INTERIORS
Plot no. 72, S.P. Marg, C-Scheme
Jaipur, Rajasthan, India
cont: +91 9950595991, 91
9982812777
e.mail: jeets.arch@gmail.com

LEGENDS:			
Mounting Height	ID	Symbol	Description
CEILING	FAN 48"		CEILING FAN 48"
CEILING	FAN 36"		CEILING FAN 36"
CEILING	CH		CHANDIELIER
+93"	TL/W		LED Wall Tube Light
+93"	BULB		LED Bulb 20W
+93"	GL		WALL BRACKETS AS ORISKAY FOR GANESHA LIGHT
+78"	ML		12x3 LED Mirror Light
CEILING	DL		LED 6" Down Lighter 20W (Surface Mounting)
VENTILATOR	CR		CEILING ROSE
VENTILATOR	EXP		9" DIA FRESH AIR FAN
+24"	2wSB		2w SWITCH BOARD
+42"	SB		SWITCH BOARD/Socket & SWITCH
+24"	TEL		TELEPHONE POINT
+24"	LP TEL		6 A PLUG POINT FOR TELEPHONE
+48"	TV		TV COAXIAL POINT
+48"	LP TV		6 A PLUG POINT FOR TV
+24"	LP		6 A PLUG POINT FOR SIDE TABLE
+72"	LP-CE		6 A PLUG POINT FOR CHANDIELIER
+12"	LP PC		6 A PLUG POINT FOR COMPUTER POINT
+93"	SAC		SPLIT AC OUTDOOR UNIT
+42"	PP-MIX		16 A POWER POINT FOR MIXER
+42"	PP-MIC		16 A POWER POINT FOR MICROWAVE
+78"	PP-G		16 A POWER POINT FOR GEYSER
+54"	PP-F		16 A POWER POINT FOR FRIDGE
+78"	PP-WP		16 A POWER POINT FOR WATER PURIFIER
+48"	PP-WM		16 A POWER POINT FOR WASHING MACHINE
+12"	PP-INV		16 A POWER POINT FOR INVERTER
+93"	PP-AC		25A SWITCH/DB FOR AC
			CHAMBER 12" X 20"
+18"			6A 2nos SOCKET + 1nos. 16A SWITCH, TELEPHONE LAN
+60"	MCB DB		MCB DISTRIBUTION BOARD
			CAMERA
			WALL FAN
BSB			6A SIS FAN REGULATOR/TL SWITCH
BAC			6A SIS 25 A AC

PROJECT:
PROPOSED RESIDENTIAL FLATS ON PLOT NO.-R10/71, R10/72 & R10/73, SCHEME - "INDRAPRASTH COLONY AJMER ROAD, JAIPUR"

NAME OF DRAWING: STILT FLOOR
CEILING ELECTRICAL LAYOUT,
ELECTRICAL POINT DRAWING,
CAMERA POINT DRAWING

DRAWN BY: JITENDRA SHARMA

DRAWING: NORTH:
WORKING DRAWING

PROJECT NO.: DATE:
26-11-2021

SCALE: NTS REV NO.: R-0

DRAWING NO.:
PROJECT CATEGORY BLOCK FLOOR TYPE NUMBER