


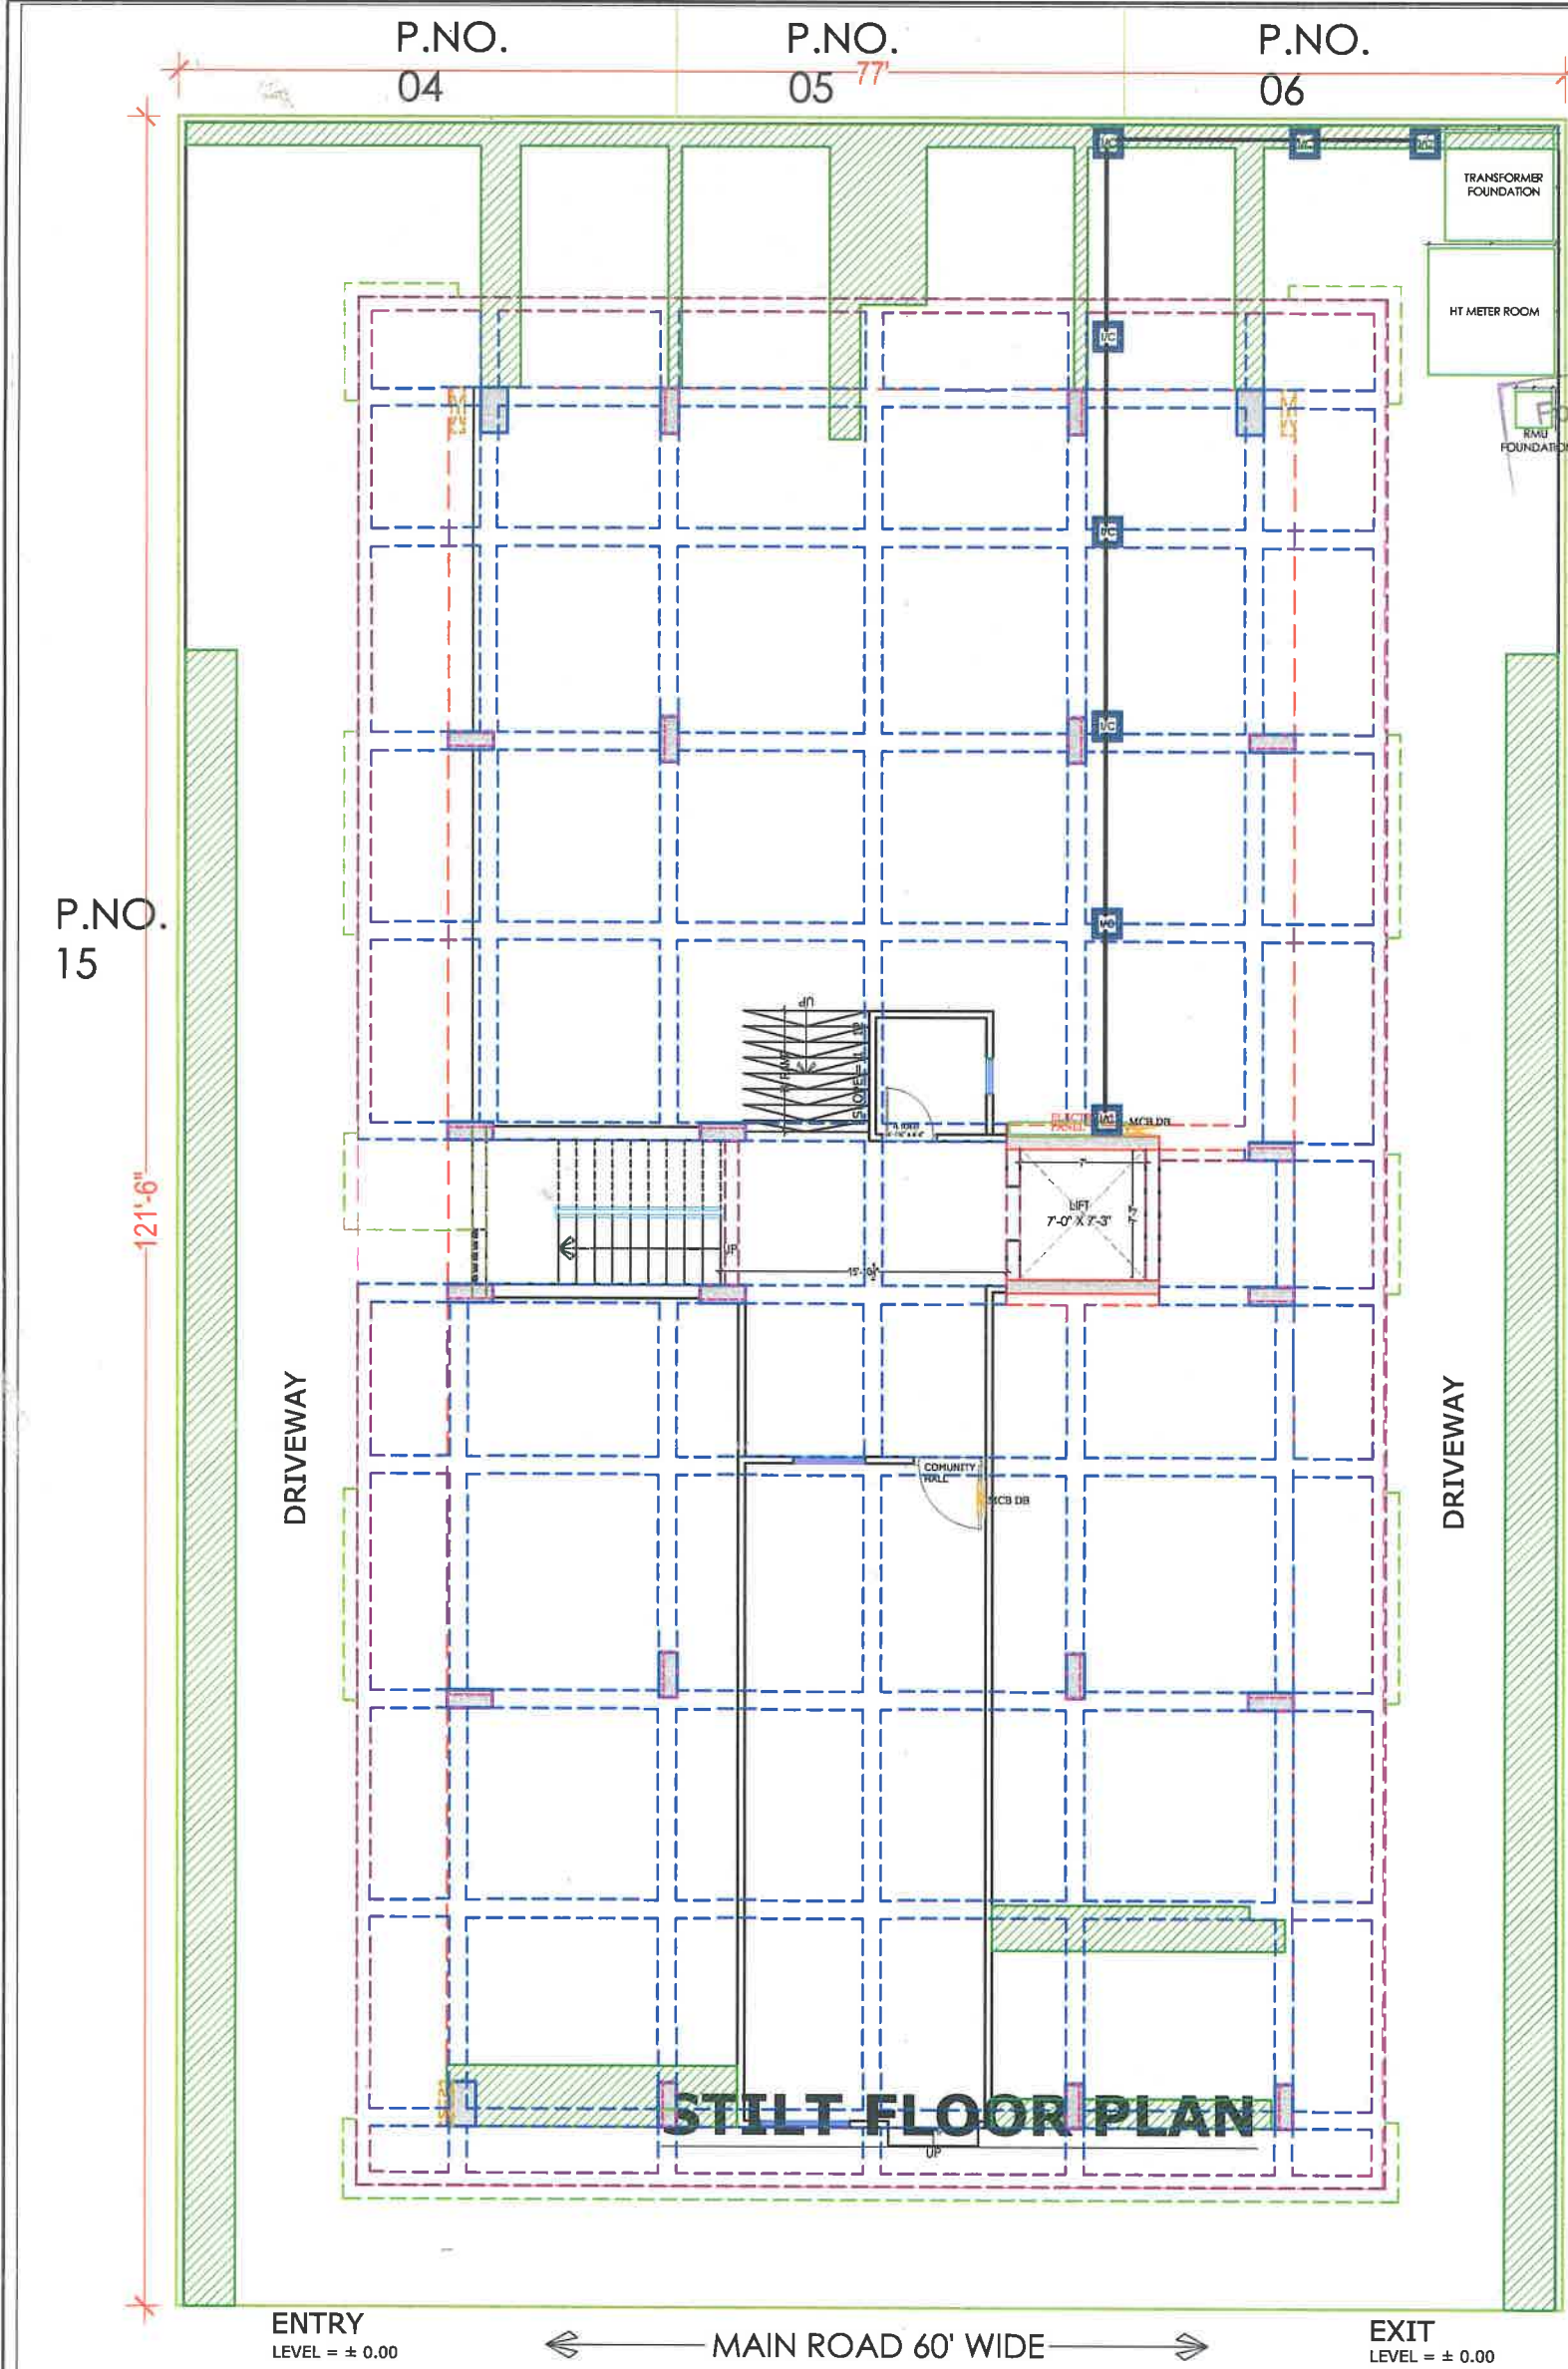

PROJECT NAME :
"UTSAV"

DEVELOPER
NAME :
M/S VINAYAK REAL ESTATE

ARCHITECTS :
INSIDE
ARCHITECTURE N INTERIORS
Plot no. 72, S.P. Marg, C- Scheme
Jaipur, Rajasthan, India
Cont: 91 9950595991, 91 9982812777
e.mail: 4insideofficial@gmail.com

Partner

Sanjeev SHARMA
B.E (Electrical)

LEGENDS:

Mounting Height	TD	Symbol	Description
CEILING	FAN48"		CEILING FAN 48"
CEILING	FAN30"		CEILING FAN 30"
CEILING	CH		CHANDIELIER
+93"	TL/W		Led Wall Tube Light Make:- Syntex Led Cat no:- SDC-15-30W
+93"	BULB		Led Bulb 20W Make:- Syntex Led Cat no:- SDC-20W-57K/3K
+93"	OL		WALL BRACKETS AS DESIGN FOR OUTLET LIGHT
+78"	ML		12x2 Led Mirror Light Make:- Syntex Led Cat no:- SDC-12x2-15W-57K/3K
CEILING	DL		Led 4" Down Lighter 20W (Surface Mounted) Make:- Syntex Led Cat no:- SDC-4"DL-15W-57K/3K
VENTILATOR RT.	CR		CEILING ROSE
VENTILATOR HT	EXP		9" DIA FRESH AIR FAN
+24"	2xSB		2xSWITCH BOARD
+42"	SB		SWITCH BOARD(8A SOCKET & SWITCH)
+24"	TEL		TELEPHONE POINT
+24"	LP TEL		6 A PLUG POINT FOR TELEPHONE
+48"	TV		TV COAXIAL POINT
+48"	LP TV		8 A PLUG POINT FOR TV
+24"	LP		6 A PLUG POINT FOR SIDE TABL
+72"	LP-CH		6 A PLUG POINT FOR CHIMNEY
+12"	LP PC		6 A PLUG FOR COMPUTER POINT
+93"	SAC		SPLIT AC INDOOR UNIT
+42"	PP-MIX		16 A POWER POINT FOR MIXER
+42"	PP-MC		16 A POWER POINT FOR MICROWAVE
+78"	PP-G		16 A POWER POINT FOR GEYSER
+54"	PP-F		16 A POWER POINT FOR FRIDGE
+78"	PP-WP		16 A POWER POINT FOR WATER PURIFIER
+48"	PP-WM		16 A POWER POINT FOR WASHING MACHINE
+12"	PP-INV		16 A POWER POINT FOR INVERTOR
+93"	PP-AC		25A SWITCH/MCB FOR AC
	CH		CHAMBER(2' X 2')
+18"			8A 2 NOS. SOCKET +1 NOS. 16A SWITCH TELEPHONE/LAN
+60"	MCB DB		MCB DISTRIBUTION BOARD
			CAMERA
			WALL FAN

PROJECT:
PROPOSED RESIDENTIAL FLATS ON PLOT NO.-13A & 14 SCHEME - SUMER NAGR VISTAR 'N' BLOCK, JAIPUR

NAME OF DRAWING: STILT FLOOR ELECTRICAL ROUTE LAYOUT (TRANSFORMER, RMU, METER PANEL, ELECTRICAL CABLE)


DRAWING: WORKING DRAWING

PROJECT NO. : DATE : 19, Feb. -2024

SCALE : NTS

REV NO. : R-0

DRAWING NO. : A-01

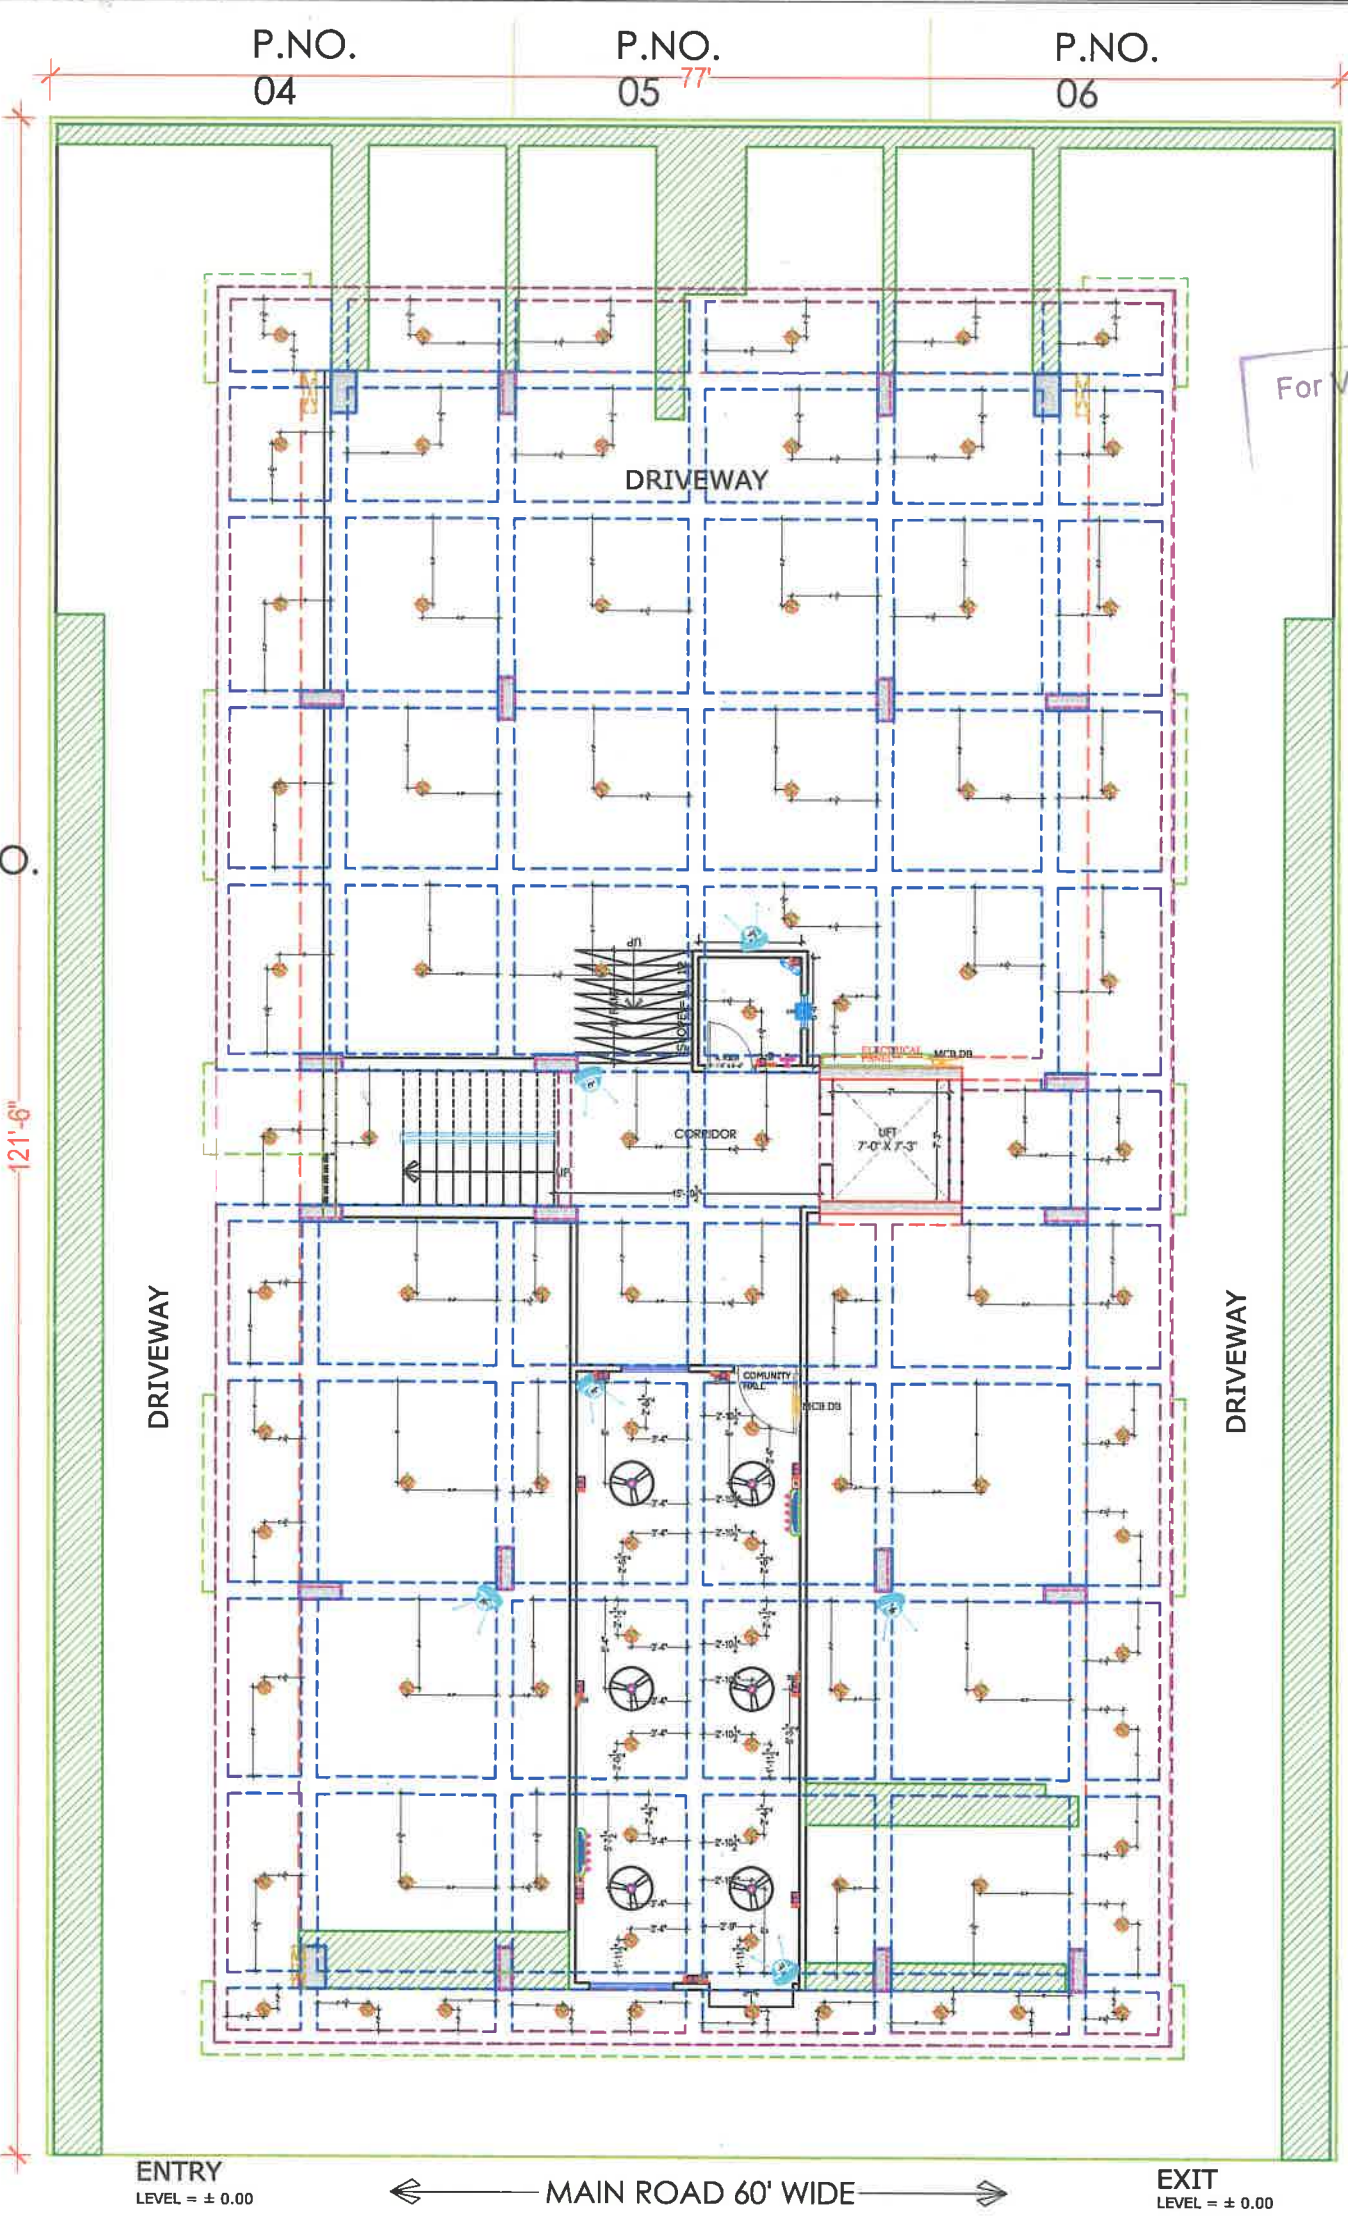

PROJECT NAME :
"UTSAV"
DEVELOPER
NAME :
M/S VINAYAK REAL ESTATE
ARCHITECTS :
INSIDE
ARCHITECTURE N INTERIORS
Plot no. 72, S.P. Marg, C- Scheme
jaipur, rajasthan, India
cont: +91 9950595991, 91 9982812777
e.mail: 4insideofficial@gmail.com

For VINAYAK REAL ESTATE
212
Partner

Er. SANJEEV SHARMA
B.E (Electrical)

Measuring Height	I D	Symbol	Description
CEILING	FAN 4F		CEILING FAN 4F
CEILING	FAN 3F		CEILING FAN 3F
CEILING	CH		CHANDLER
+91"	TLW		Led Tube Light Make:- Syda Led Cat no:- SYL-15-20W
+93"	TLB		Led Bulb 20W Make:- Syda Led Cat no:- SYL-20W-3.75/1C
+93"	OL		WALL BRACKET AS DESIGN FOR CHANDLER LIGHT
+78"	ML		12x2 Led Mirror Light Make:- Syda Led Cat no:- PFL-12x2
CEILING	DL		Led 4" Down Lighter 20W (Surface Mounted) Make:- Syda Led Cat no:- SYL-4"DL-20W
VENTILATOR	CR		CEILING ROSE
VENTILATOR	EXP		8" DIA FRESH AIR FAN
+24"	2xSB		2xSWITCH BOARD
+42"	SB		SWITCH BOARD (5A SOCKET & SWITCH)
+24"	TEL		TELEPHONE POINT
+24"	LP TEL		5 A PLUG POINT FOR TELEPHONE
+48"	TV		TV COAXIAL POINT
+48"	LP TV		5 A PLUG POINT FOR TV
+24"	LP		5 A PLUG POINT FOR SIDE TABLE
+72"	LP CH		5 A PLUG POINT FOR CHIMNEY
+12"	LP FC		5 A PLUG FOR COMPUTER POINT
+93"	SAC		SPLIT AC INDOOR UNIT
+42"	PP-MIX		15 A POWER POINT FOR MIXER
+42"	PP-MC		15 A POWER POINT FOR MICROWAVE
+78"	PP-G		15 A POWER POINT FOR GEYSER
+54"	PP-F		15 A POWER POINT FOR FRIDGE
+78"	PP-WP		15 A POWER POINT FOR WATER PUMP
+48"	PP-WM		15 A POWER POINT FOR WASHING MACHINE
+12"	PP-DV		15 A POWER POINT FOR DIVERTER
+93"	PP-AC		25A SWITCH/MCB FOR AC
	CH		CHAMBER (2' X 2')
+18"	SW		5A 2 NOS. SOCKET +1 NOS. 10A SWITCH, TELEPHONE/LAN
+60"	MCB DB		MCB DISTRIBUTION BOARD
	CA		CAMERA
	WF		WALL FAN

PROJECT:
PROPOSED RESIDENTIAL FLATS ON PLOT
NO.-13A & 14 SCHEME - SUMER NAGR
VISTAR 'N' BLOCK, JAIPUR

NAME OF DRAWING: **STILT FLOOR
CEILING ELECTRICAL LAYOUT,
ELECTRICAL POINT DRAWING,
CAMERA POINT DRAWING**

DRAWING: WORKING DRAWING	NORTH:
PROJECT NO. :	DATE : 19, Feb.- 2024
SCALE : NTS	REV NO. : R-0
DRAWING NO. : 	A-01

STILT FLOOR CEILING ELECTRICAL LAYOUT, ELECTRICAL POINT DRAWING, CAMERA POINT DRAWING