
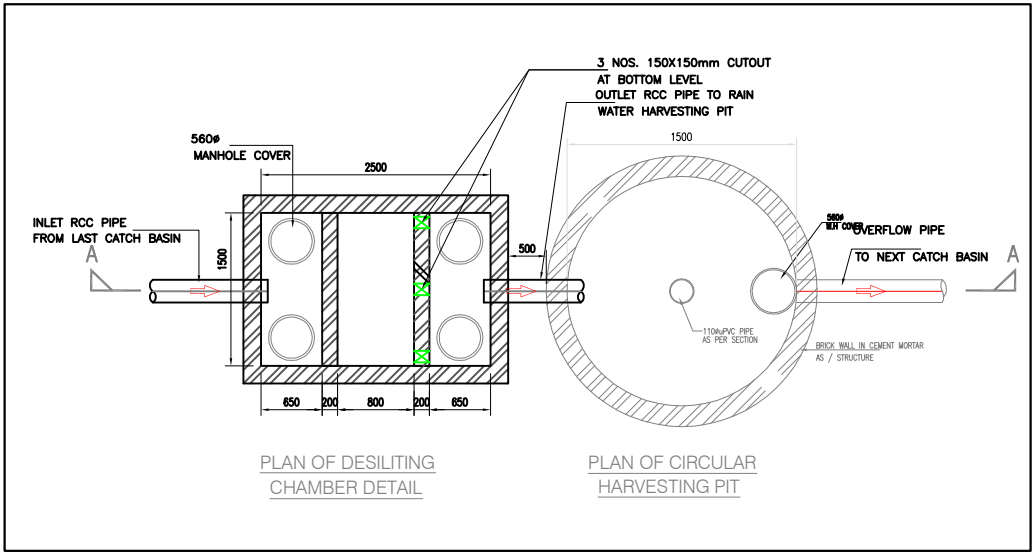
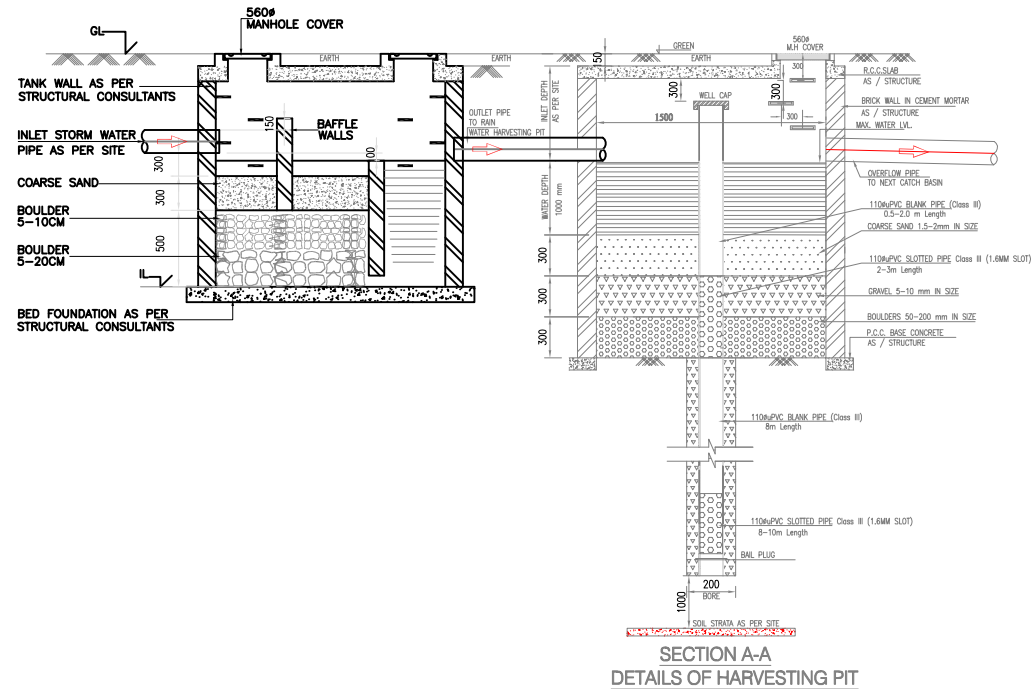


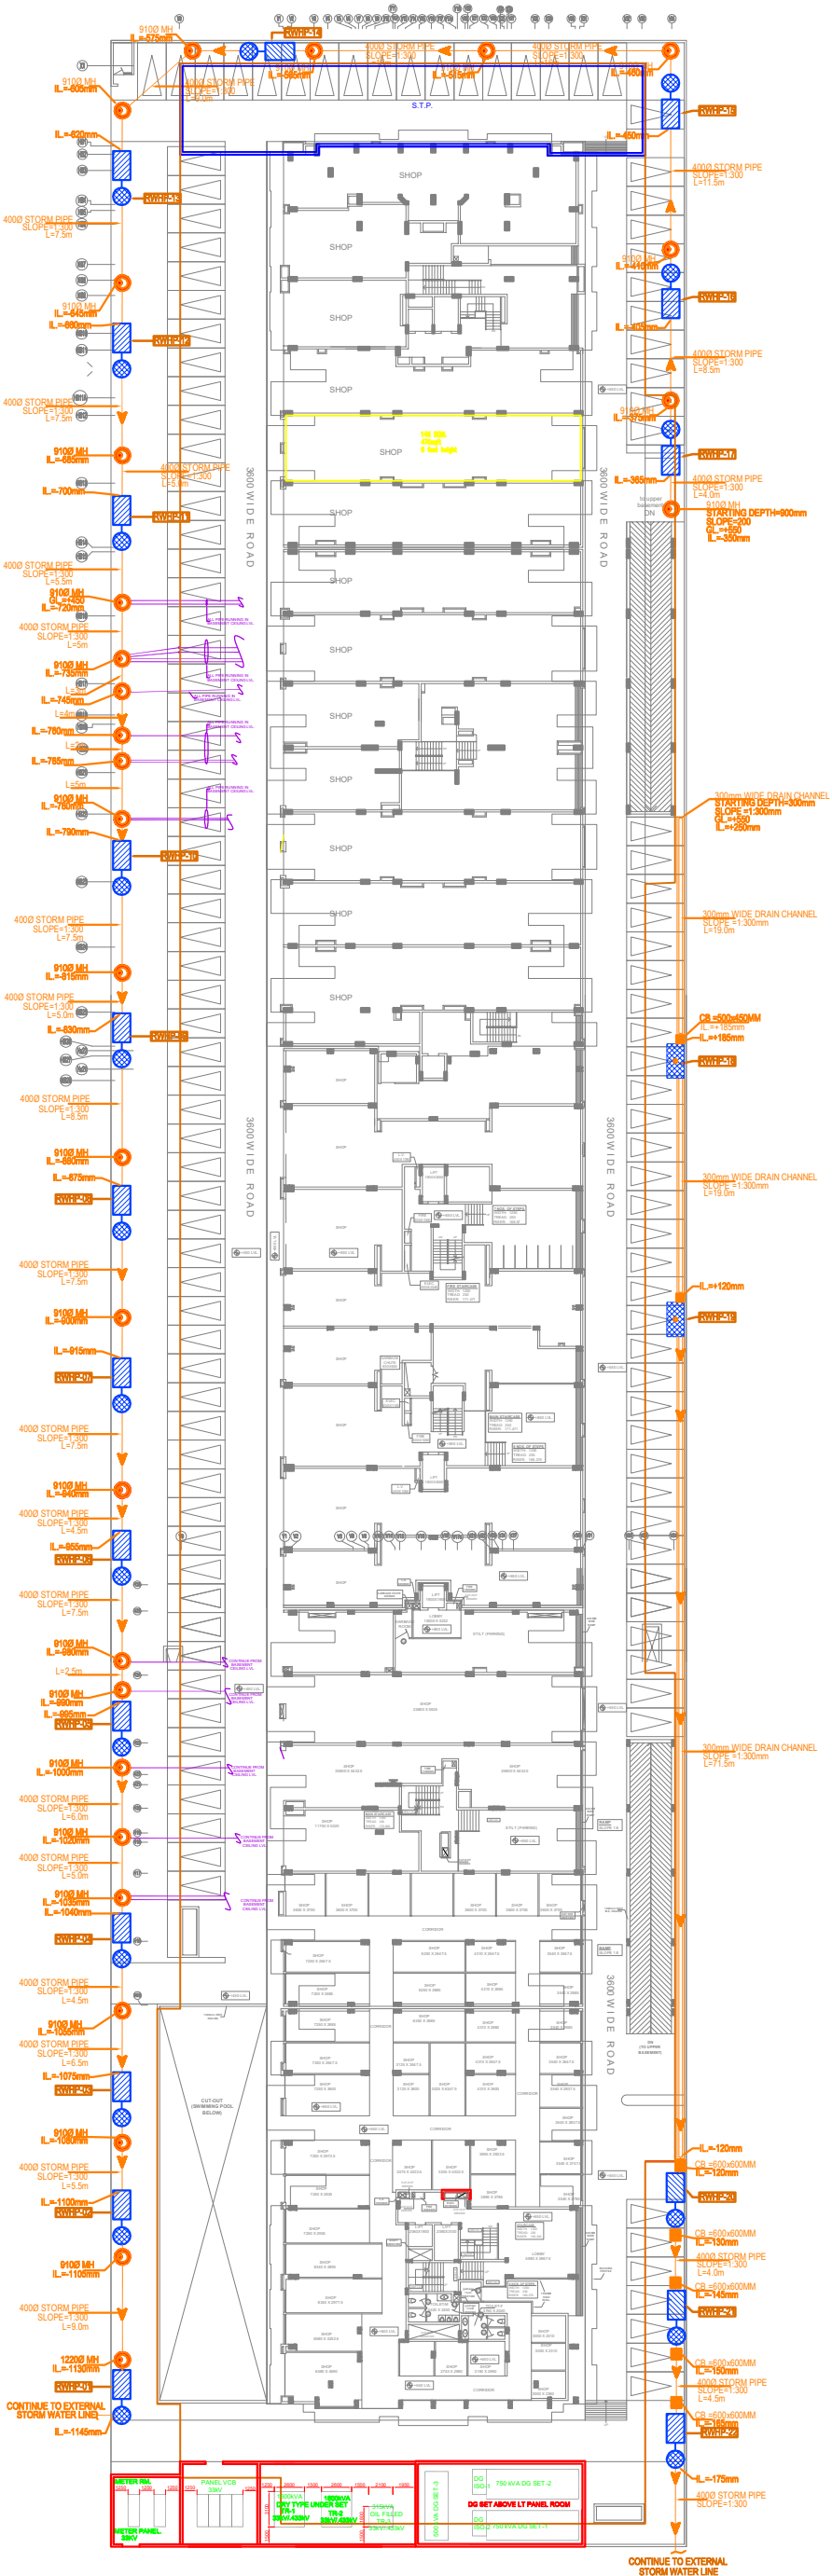

HARVESTING PIT DETAIL WITH DESILTING CHAMBER

| STORM WATER LEGEND:- |                                        |
|----------------------|----------------------------------------|
|                      | EXTERNAL STORM WATER LINE              |
|                      | 9100, 12200, 15200 STORM WATER MANHOLE |
|                      | STORM WATER MANHOLE                    |
|                      | WATER FLOW                             |
|                      | RAIN WATER HARVESTING PIT              |

|                |                                                                                                                                                                                                                     |
|----------------|---------------------------------------------------------------------------------------------------------------------------------------------------------------------------------------------------------------------|
| CLIENT :-      |                                                                                                                                                                                                                     |
| PROJECT :-     | PROPOSED BUILDING AT PLOT NO.1,2,3,4 AT DAKANYA RAILWAY STATION ROAD, RAJEEV GANDHI NAGAR EXT., KOTA                                                                                                                |
| ARCHITECTS :-  | <b>R.K. &amp; ASSOCIATES</b><br>Architects, Engineers & Planners<br>E-31, GREEN PARK MAIN, NEW DELHI - 110016, INDIA<br>Tel : 2616-3118, 2616-1875, 2616-7357<br>Fax: 011-2686-2548 E-mail: rk.associates@gmail.com |
| CONSULTANTS :- | <b>ACROBAT ENGINEERS PVT.LTD.</b><br>H.No. 19/18, Basement Lvl.<br>Spring Field Colony<br>Faridabad (Haryana)<br>Tel. : 0129-4056009<br>customerservice@acrobotengineers.com                                        |
| SHEET TITLE    | <b>EXTERNAL SITE PLAN<br/>STORM WATER LAYOUT<br/>PLUMBING DRAWING</b>                                                                                                                                               |
| DRG. NO.       | <b>AEA/RSR/ESP/SWL/PL-01A</b>                                                                                                                                                                                       |
| DATE           | 14-07-2016                                                                                                                                                                                                          |
| SCALE          | A1@1:300                                                                                                                                                                                                            |
| DETAIL BY      | AMIT MAURYA                                                                                                                                                                                                         |
| REV. NO        | NORTH                                                                                                                                                                                                               |
|                | R1                                                                                                                                                                                                                  |

NOTE  
ALL MH LOCATION WILL BE  
CHANGE AS PER FINAL BASEMENT  
PLUMBING CEILING LAYOUT