


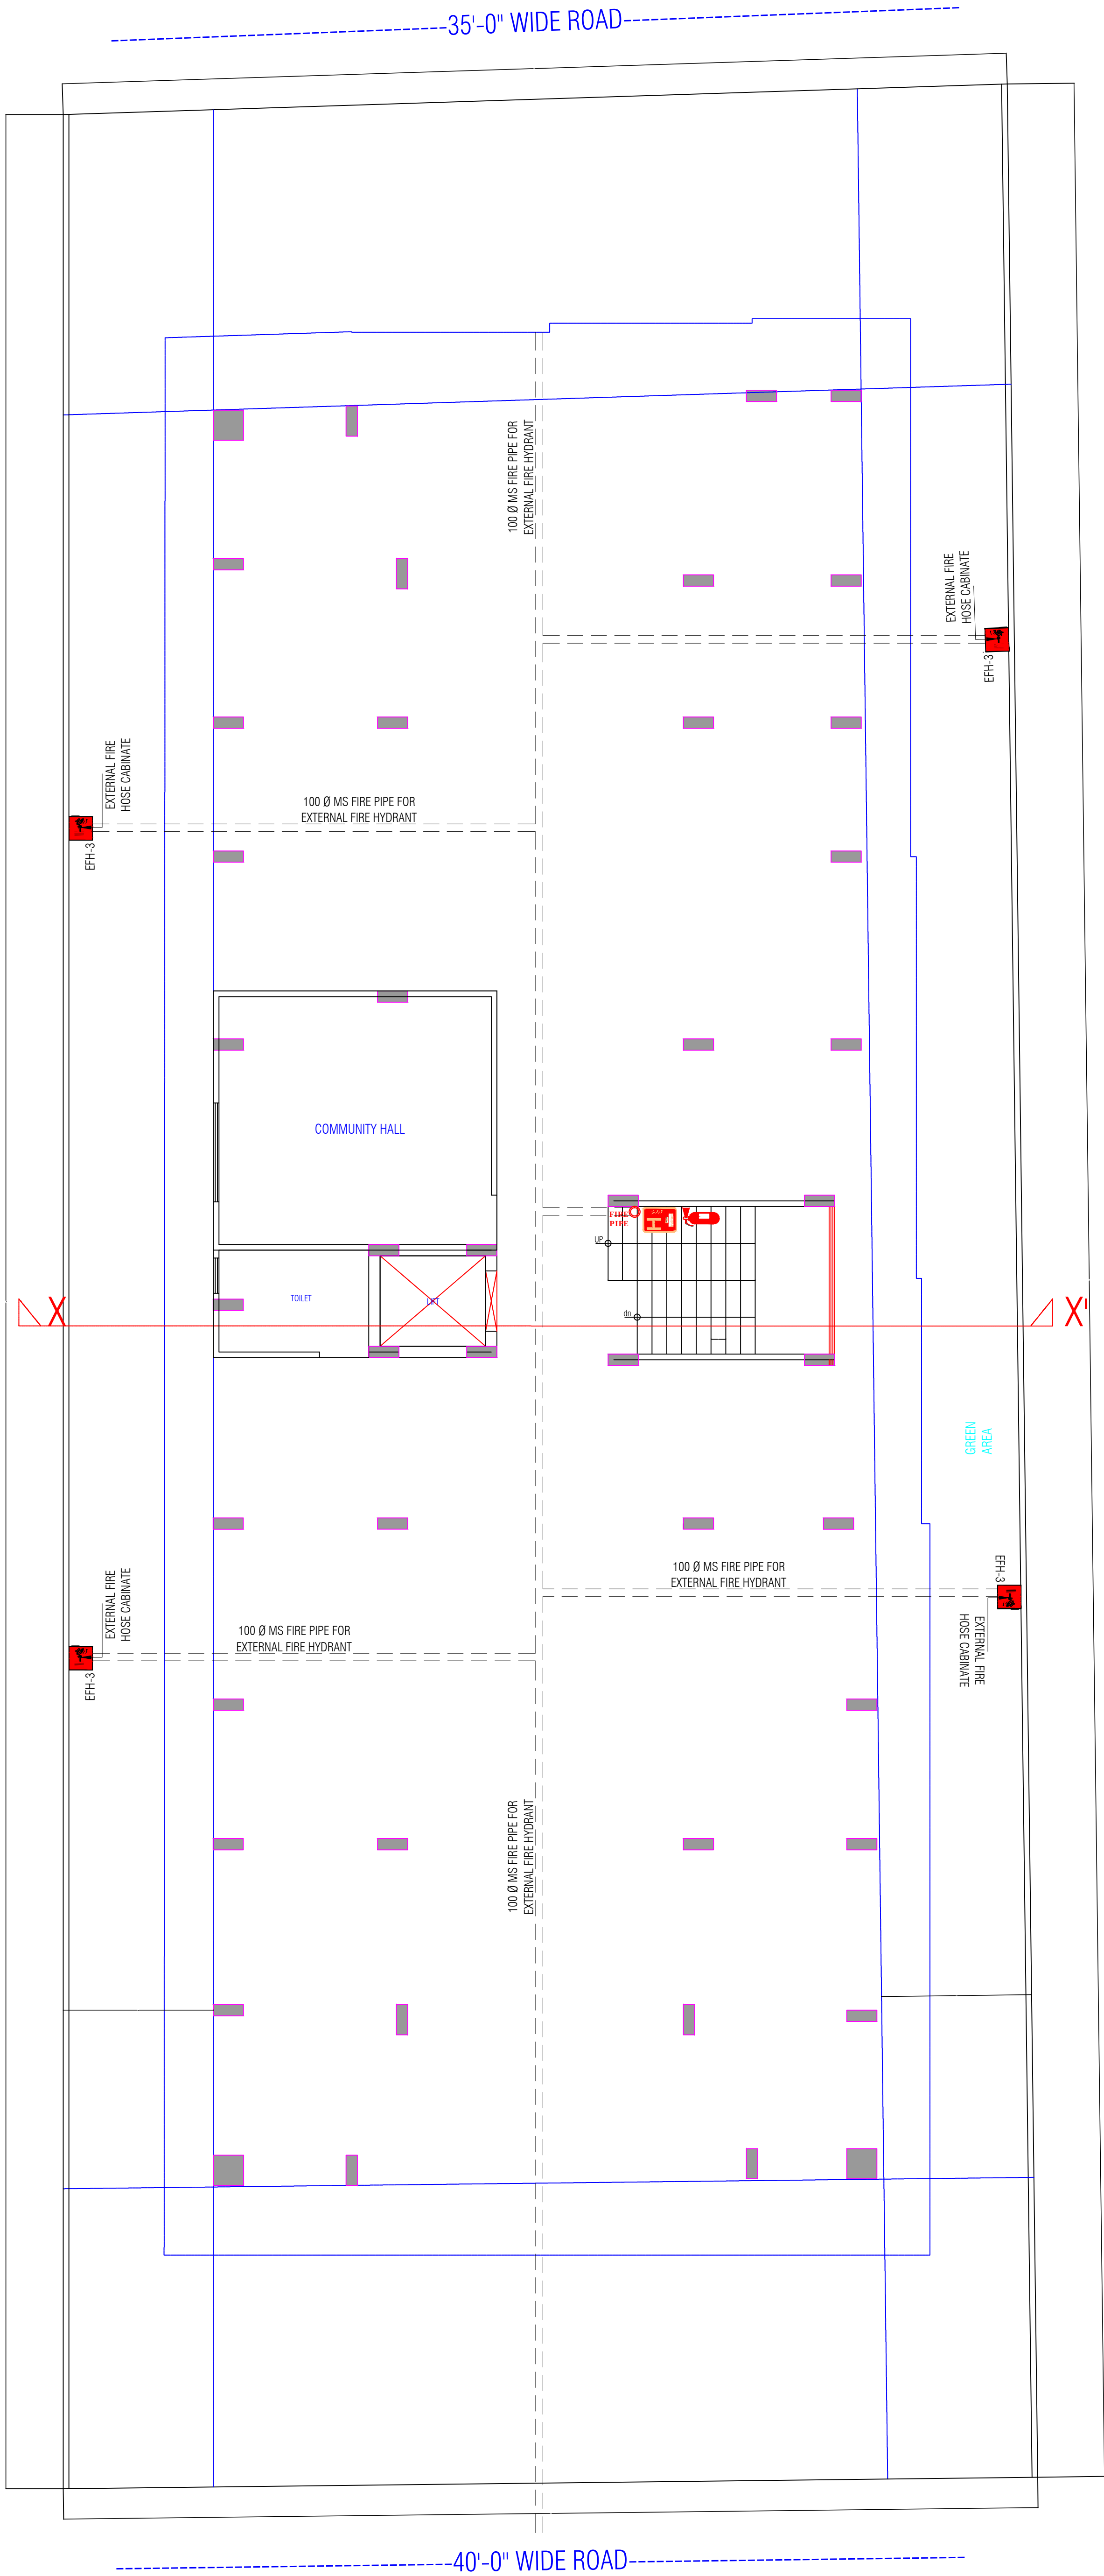

STILT(PARKING)FLOOR PLAN

LEGEND



EMERGENCY
ASSEMBLY POINT



 
FIRE POINT



FIRE HYDRANT



EMERGENCY
CONTROL ROOM



HOSE REEL

DHARMESH SHARMA
B. TECH. (CIVIL)

WARNING

1. This drawing is the sole copyright of Architects **VISTAAR** and should be used for the purpose expressly issued.

GENERAL NOTES

1. All dimensions are in feet and inches.
2. Do not scale this drawing follow written dimensions only.
3. This drawing should be read in conjunction with other architectural and structural drawings.
4. Any discrepancy in the drawing should be immediately brought to the notice of architect.

PROJECT TITLE

Shree Krishna Residency
Plot No. 82,83,84 E.P, 93 E.P-A-W.P,99 W.P,99
E.P-A , Village - Manpur Devri Urf Golyawas ,
Scheme - Vrindavan Vihar , Jaipur - 302020
(Rajasthan)

DRAWING TITLE

STILT FLOOR FIRE FIGHTER

ARCHITECTS :

VISTAAR ARCHITECTS &
PLANNERS

Architects :: Interior Designers
B-2/12, Chitrkoot scheme,
main Gandhi Path,Opp mall of jaipur,Jaipur
PH.- 0141-4116461,09001010366

PATH :-

DRN.	DATE	REV.	NORTH
MANOJ KUMAWAT	09-09-2022		
SCALE	JOB NO.		
N.T.S			



LEGEND



EMERGENCY
ASSEMBLY POINT



FIRE POINT



FIRE HYDRANT



EMERGENCY
CONTROL ROOM



HOSE REEL

Dharmesh
DHARMESH SHARMA
B. TECH. (CIVIL)

WARNING

1. This drawing is the sole copyright of Architects **VISTAAR** and should be used for the purpose expressly issued.

GENERAL NOTES

1. All dimensions are in feet and inches.
2. Do not scale this drawing follow written dimensions only.
3. This drawing should be read in conjunction with other architectural and structural drawings.
4. Any discrepancy in the drawing should be immediately brought to the notice of architect.

PROJECT TITLE

Shree Krishna Residency
Plot No. 82,83,84 E.P, 93 E.P-A-W.P,99 W.P,99
E.P-A , Village - Manpur Devri Urif Golyawas ,
Scheme - Vrindavan Vihar , Jaipur - 302020
(Rajasthan)

DRAWING TITLE

FIRE FIGHTER TYPICAL FLOOR


ARCHITECTS :

VISTAAR ARCHITECTS & PLANNERS

Architects :: Interior Designers
B-2/12, Chitrkoot scheme,
main Gandhi Path,Opp mall of jaipur,Jaipur
PH.- 0141-4116461,09001010366

PATH :-

DRN.	DATE	REV.	NORTH
MANOJ KUMAWAT	09-09-2022		
SCALE	JOB NO.		
N.T.S			

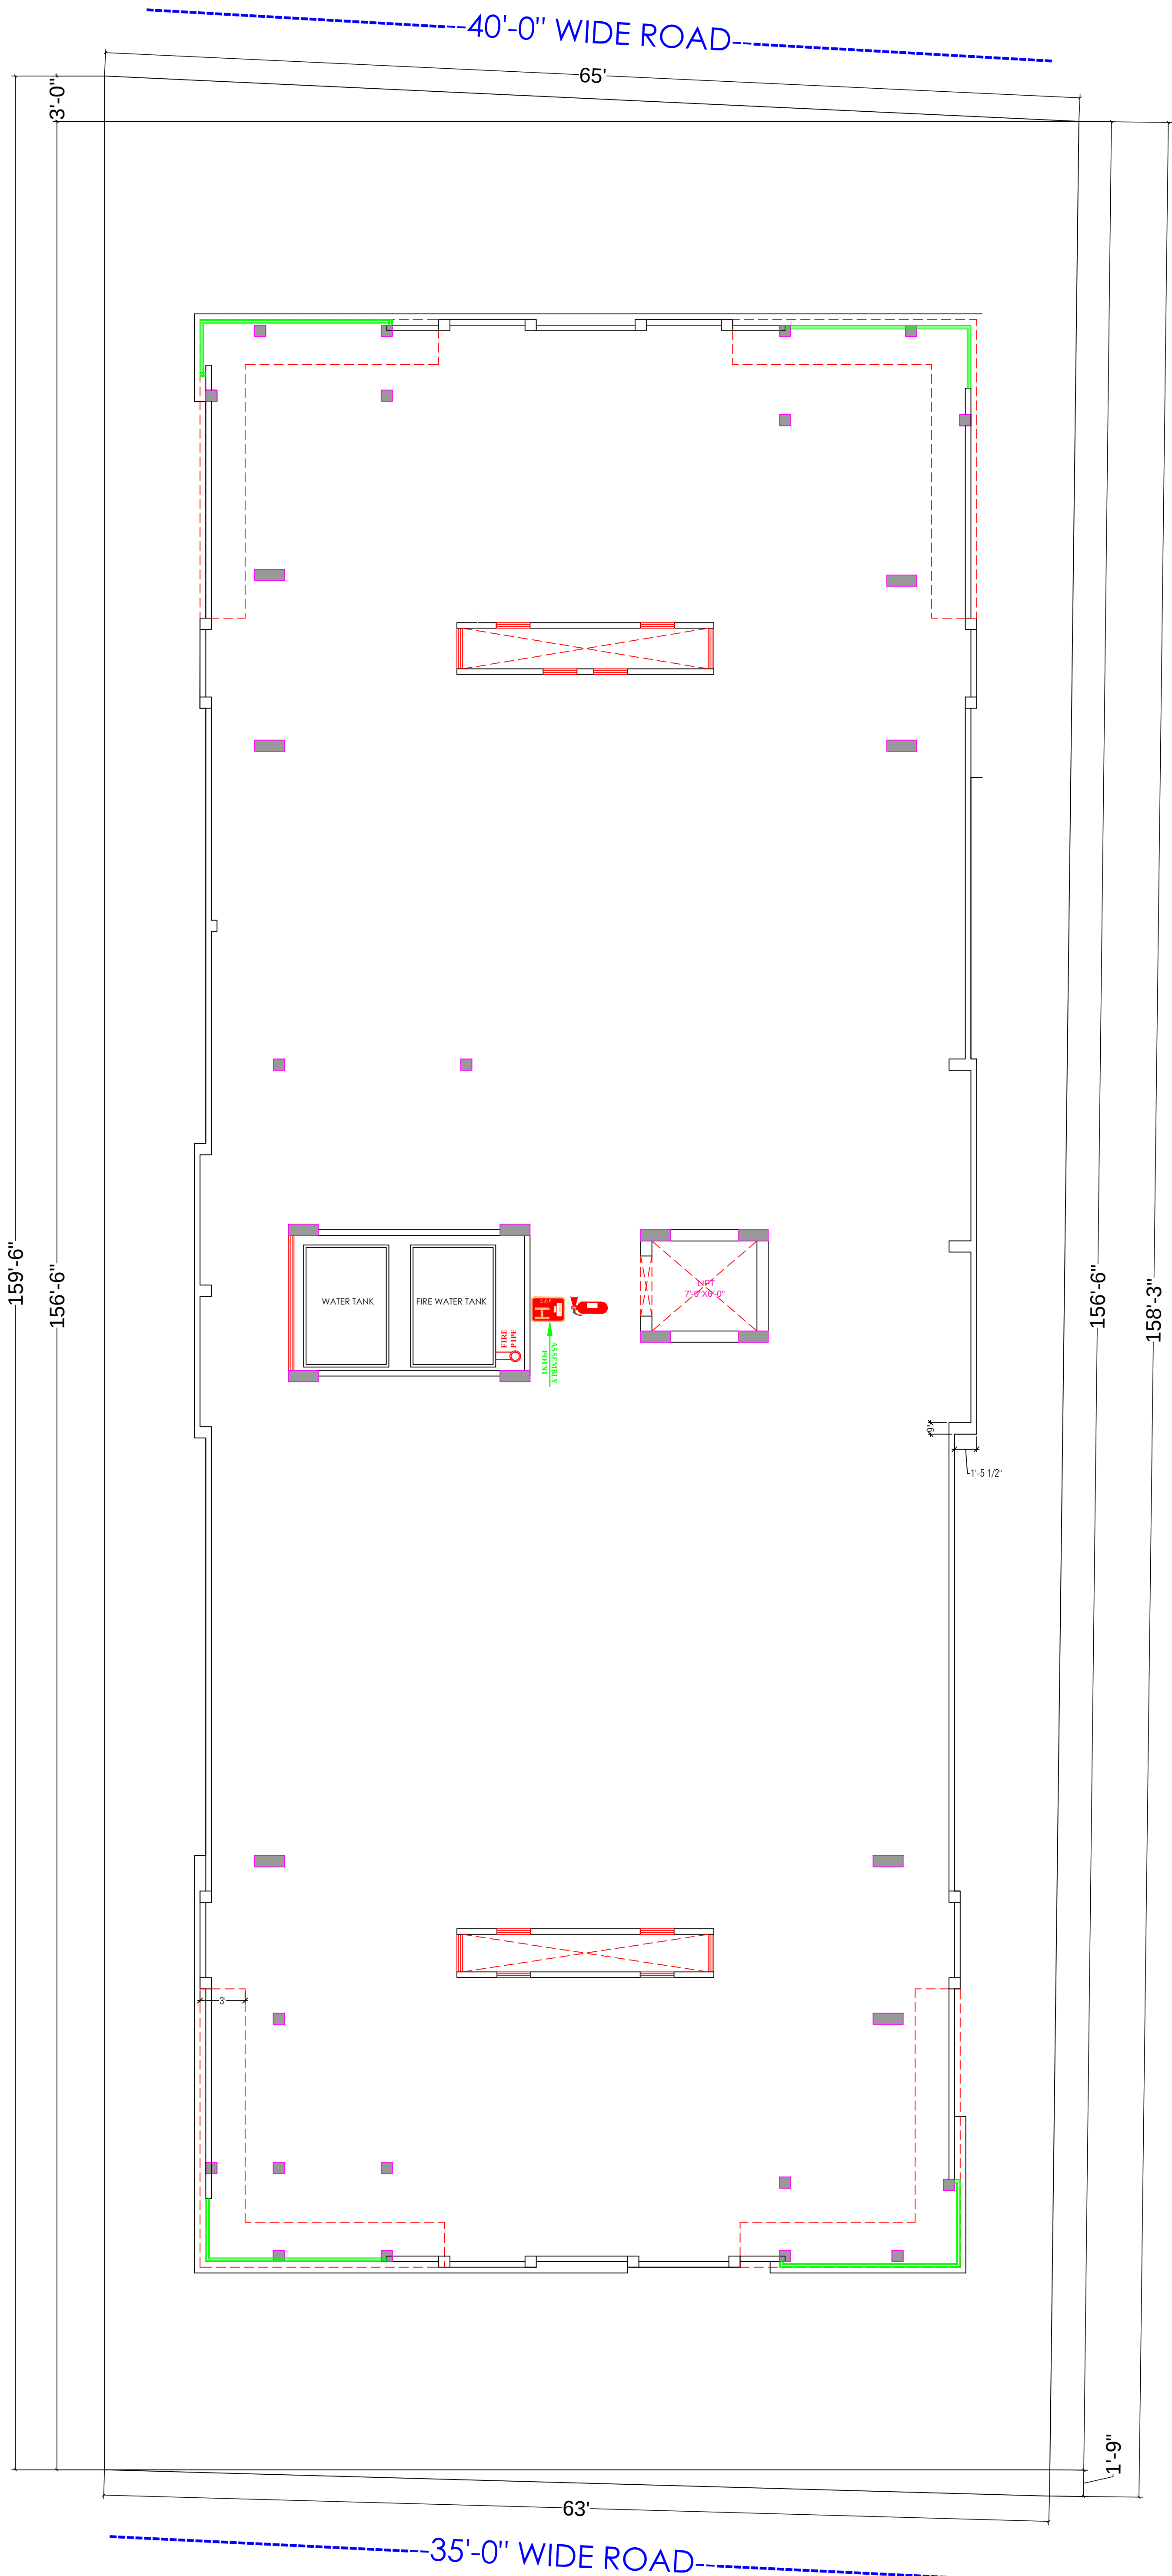

LEGEND



EMERGENCY
ASSEMBLY POINT



FIRE POINT



FIRE HYDRANT



EMERGENCY
CONTROL ROOM



HOSE REEL

Dharmesh Sharma
DHARMESH SHARMA
B. TECH. (CIVIL)

WARNING

1. This drawing is the sole copyright of Architects **VISTAAR** and should be used for the purpose expressly issued.

GENERAL NOTES

1. All dimensions are in feet and inches.
2. Do not scale this drawing follow written dimensions only.
3. This drawing should be read in conjunction with other architectural and structural drawings.
4. Any discrepancy in the drawing should be immediately brought to the notice of architect.

PROJECT TITLE

Shree Krishna Residency
Plot No. 82,83,84 E.P, 93 E.P-A-W.P,99 W.P,99
E.P-A , Village - Manpur Devri Urf Golyawas ,
Scheme - Vrindavan Vihar , Jaipur - 302020
(Rajasthan)

DRAWING TITLE

TERRACE FIRE FIGHTER

ARCHITECTS :

VISTAAR ARCHITECTS & PLANNERS

Architects :: Interior Designers
B-2/12, Chitrkoot scheme,
main Gandhi Path,Opp mall of jaipur,Jaipur
PH.- 0141-4116461,09001010366

PATH :-			
DRN.	DATE	REV.	NORTH
MANOJ KUMAWAT	21-10-2022		
SCALE	JOB NO.		
N.T.S			