


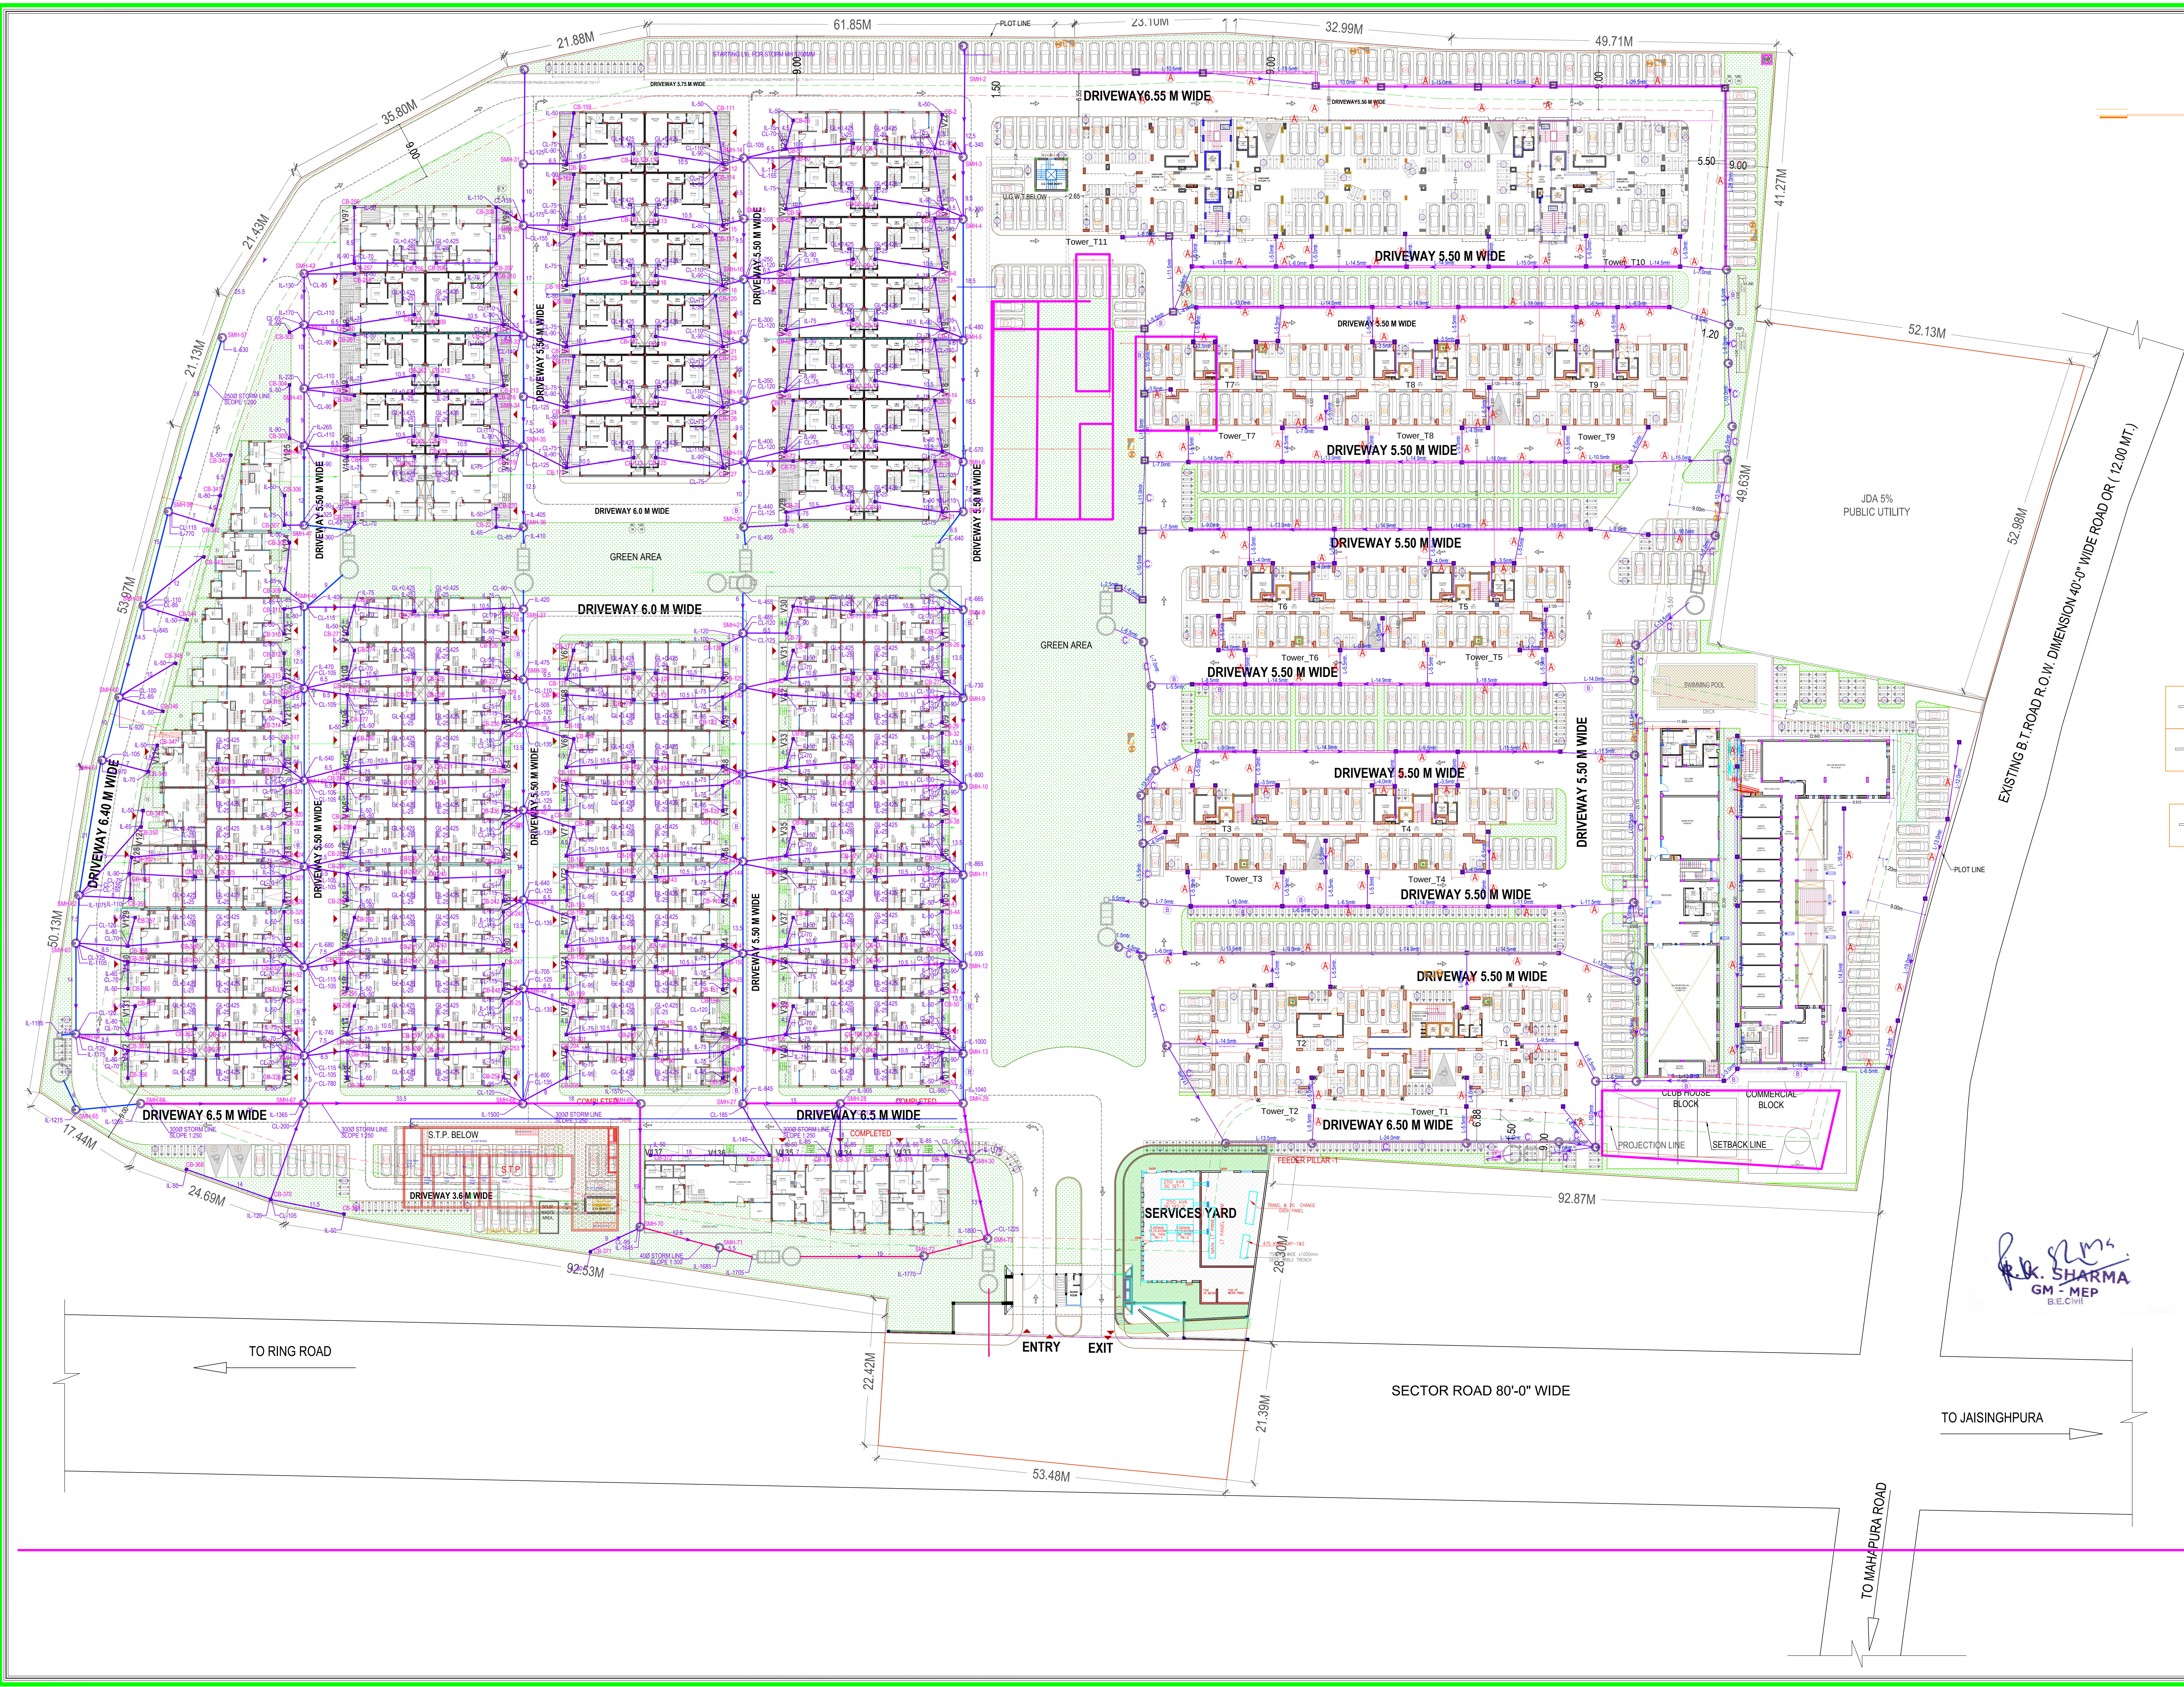

A	2000 STORM WATER PIPE
B	2500 STORM WATER PIPE
C	3000 STORM WATER PIPE
D	4500 STORM WATER PIPE

LEGEND FOR STORM WATER LINE

	STORM WATER LINE
	CB=450x450mm
	9100, 12000 STORM WATER MANHOLE
	MH MANHOLE
	CB CATCH BASIN
	SMH STORM WATER MANHOLE

DRAWING TITLE
EXTERNAL RAINWATER HARVESTING DRAWING
TITLE:
STILT FLOOR PLAN

DATE : 10/03/2021
SCALE:- 1= 300
NORTH :

PROJECT:
RESIDENTIAL GROUP HOUSING
"MAHIMA SHUBH NILAY PHASE-1 (Part-2)" OF
GREEN BUILD ESTATE PVT. LTD.
IN KHASRA NO.-
129,130,131,132,133,134,135,136,
137,141,142,143,239,262/138
AT REVENUE VILLAGE- CHIMANPURA,
TEH-SANGANER, JAIPUR.

ARCHITECTS:
ma architects pvt.ltd.
Jaipur - Bangalore - Hyderabad
Plot No. - 1, greenwood, Lal Kothi Scheme,
off Sakhar Marg Jaipur-302001
Tel:- 91 141 4299999, 2741232
email - studio@maarchitects.in web-www.maarchitects.in