

SECTOR ROAD 18.30 M WIDE

BLOCK-A

NOTE:- DRAWING APPROVAL BY EMPANELLED ARCHITECT ACCORDING TO LETTER NO. रू. प. 18(36) नववि एनएचपी/ 2014/ पद DATED 31 MAY 2017

DRAWING TYPE:-

PROJECT:-

TITLE:-


PROPOSED AFFORDABLE HOUSING
KHASRA NO. 622 & 631
AT VILLAGE NARSINGHPURA URF RIKSHA ,
TEHSIL SANGANER, JAIPUR.

GROUND FLOOR PLAN
EXTERNAL DRAINAGE
ROUTING PLAN (BLOCK-A,B)
STORM- WATER & DRAINAGE .

SCALE:- 1: 200

DATE:- 10-10-23

MEP Consultancy

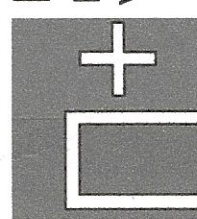

PILLARPLUS PVT LTD-The New Age MEP Consultancy Firm
Plot No. 45,46 guru Jambheshwar Nagar A,
Vijay Dwar, Gandhipath, Jaipur-302021
JAIPUR | GURGAON | BANGLORE
Email: contact@pillarplus.com | Website: www.pillarplus.com



BALCONY VERTICAL COVER



SYMBOL	DESCRIPTION
--------	-------------

110 mm Soil Waste Water Pipe

110 mm Waste Water Pipe

Floor Trap Grating Cover

P TRAP

SHOEPP

DOUBLE Y TEE


110 mm Soil Waste Water Pipe

110 mm Waste Water Pipe

PIPE SCHEDULE TABLE		
S.No.	PIPE DIA.	DESCRIPTION MATERIAL
1.	50 MM	WASH BASIN (BOTTLE TRAP) UPVC (4kg/ Sqcm)
2.	75 MM	WASTE WATER PIPE UPVC (4kg/ Sqcm)
3.	110 MM	SOIL WATER PIPE UPVC (4kg/ Sqcm)

PHILARPLUS PVT.LTD-The New Age MEP Consultancy Firm
Plot No. 45/46 suraj nagar west,
Vijay Dwar, Gurukulpath, Jaipur-302021
Email: info@philplus.com, contact: Mr. +91-9799605031 Website: www.philplus.com

BLOCK - A

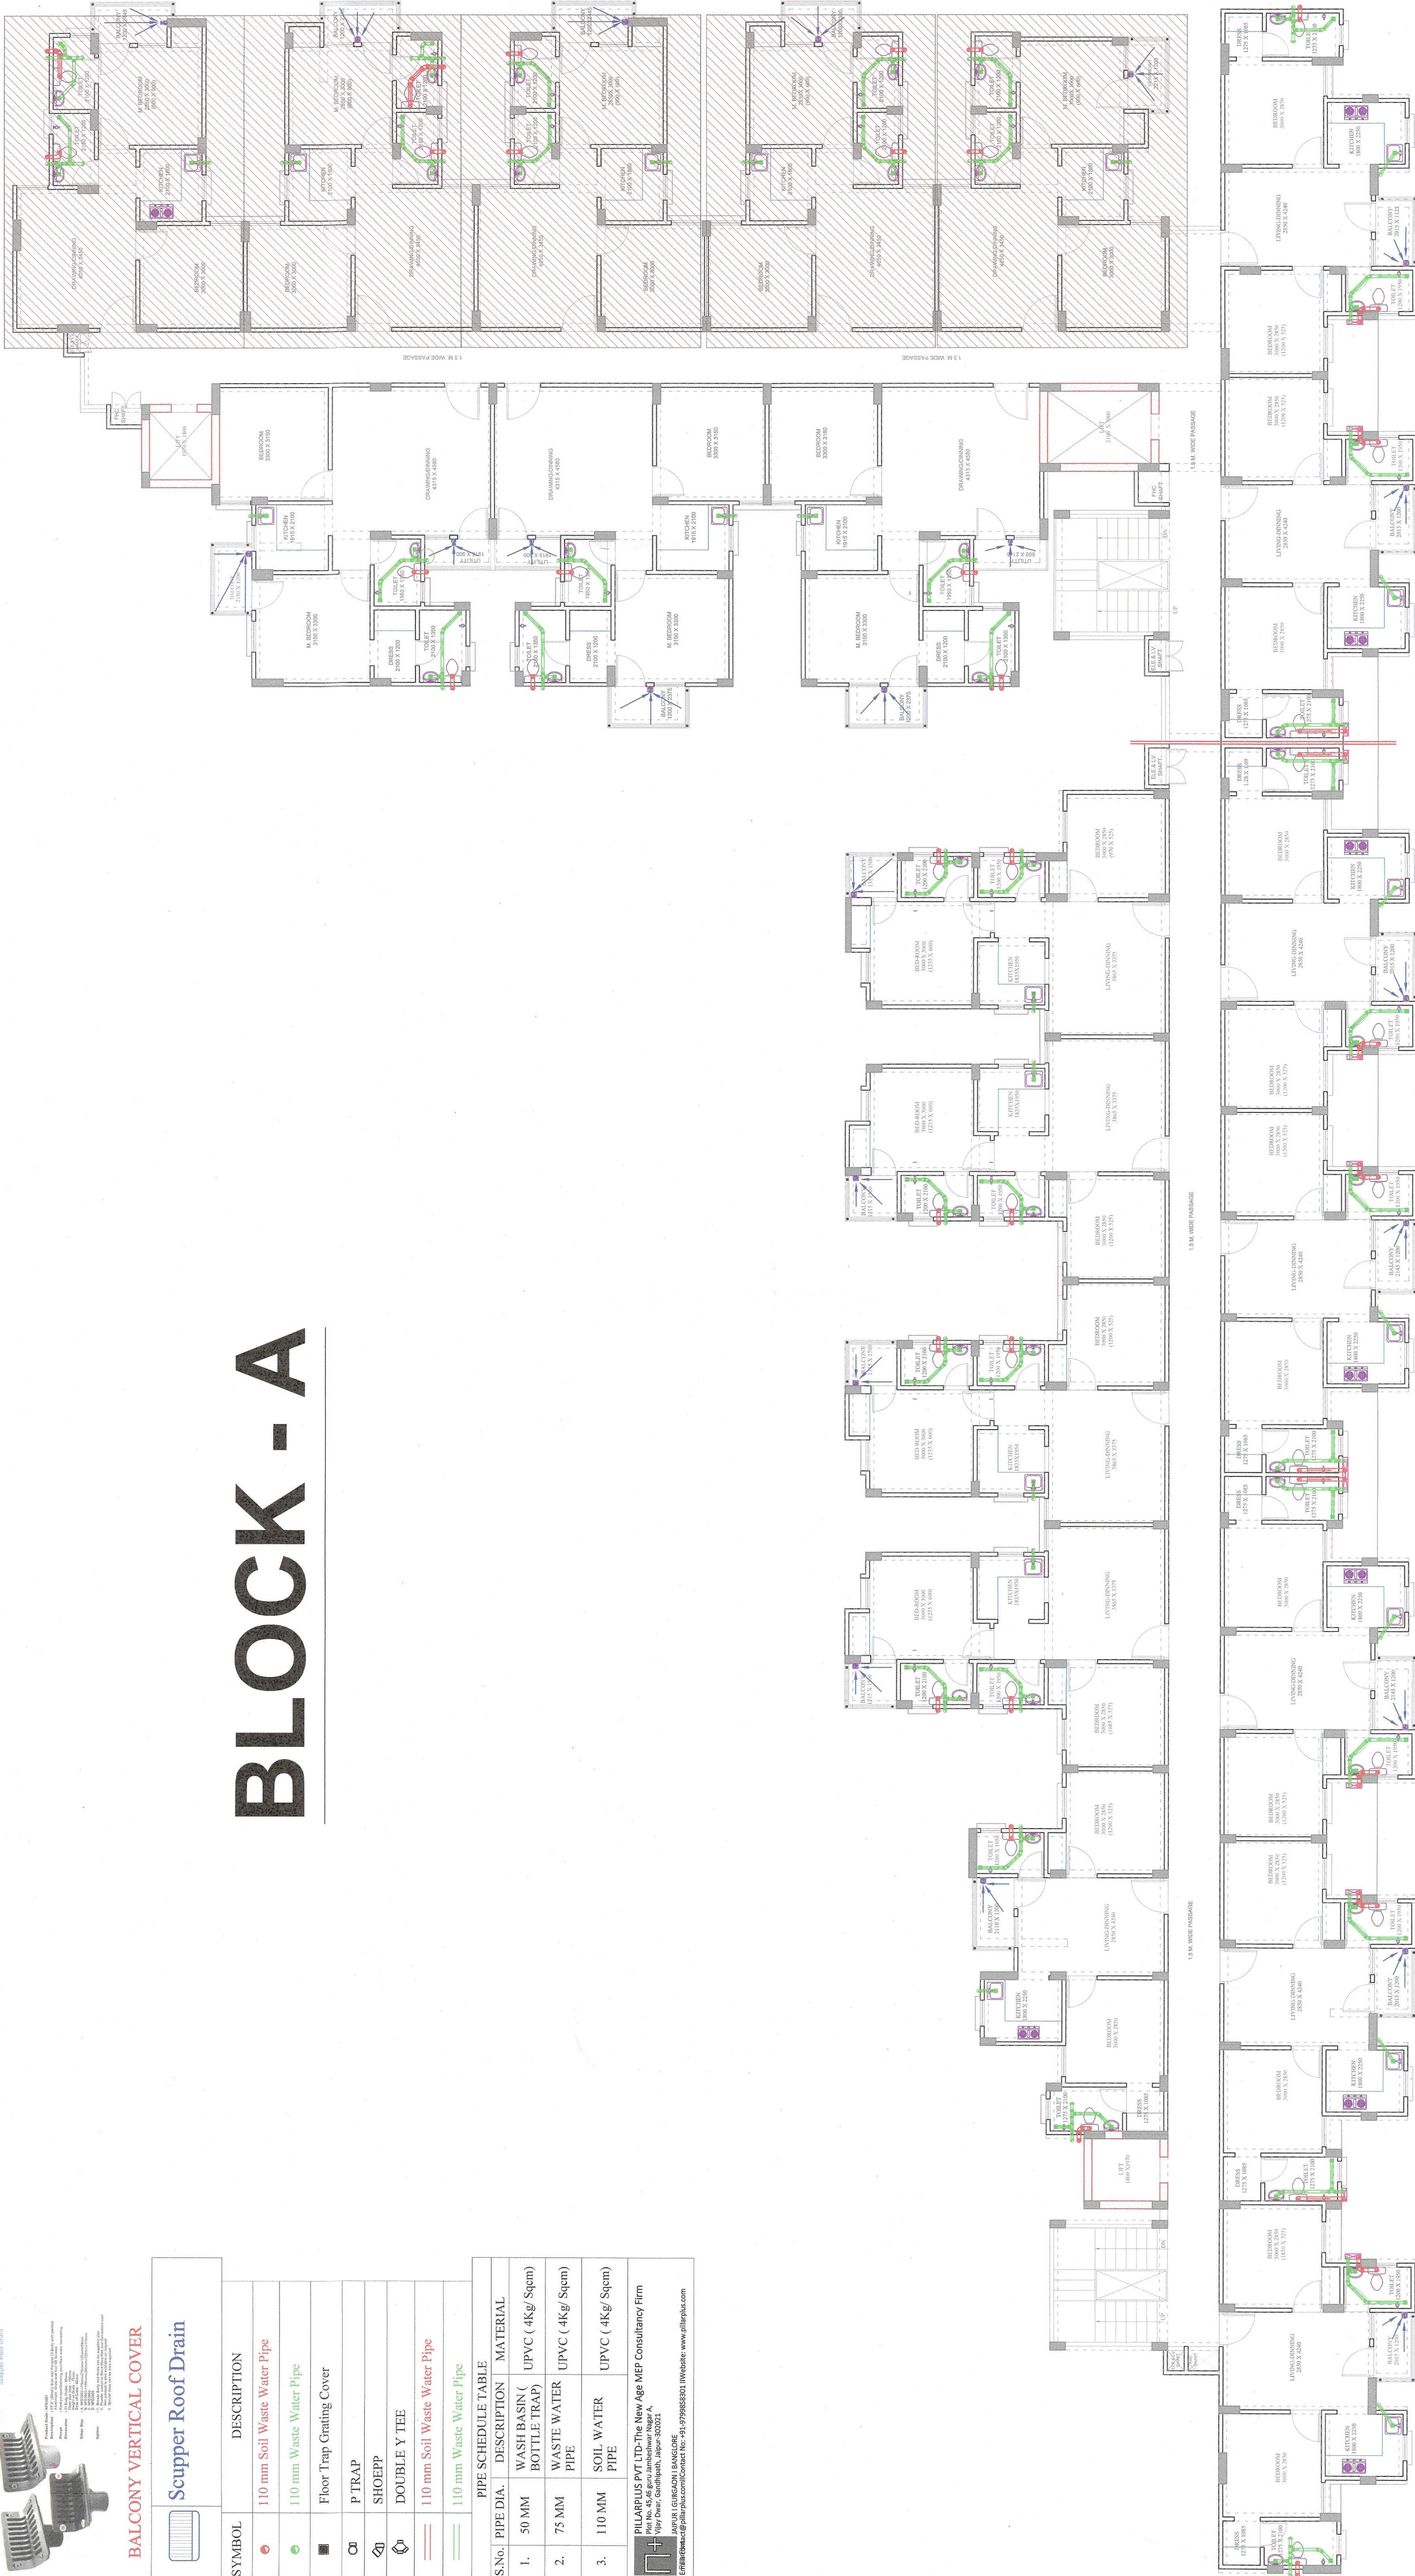

ARCHITECTS :



SKYLINE PLANNERS & DESIGN DEVELOPERS
ARCHITECTS . PLANNERS . INTERIOR DESIGNERS . LANDSCAPE
31, Shiv Path, Suraj Nagar West,
Civil Lines, Jaipur -302019 (Raj.)
Ph: 0141-4036189, M: 09887483594
web : www.skylineplanners.com, email: sdjlpr@gmail.com

PROJECT : PROPOSED AFFORDABLE HOUSING
KHASRA NO. 622 & 631
AT VILLAGE NARSINGHPURA URF RIKSHA , TEHSIL SANGANER, JAIPUR.

PROJECT TYPE : AFFORDABLE HOUSING
CLIENT : B3B GROUP

NAME OF DRAWING :
TYPICAL FLOOR
DRAINAGE PLAN

DRAWN BY :
NITIN SHARMA

APPROVED BY :
WASEEM NOOR

DATE :27-05-2022

SCALE : N.T.S.

S.NO.

DATE

REVISION DESCRIPTION

GENERAL NOTES :

1. ALL THE DIMENSIONS ON THE DRAWING ARE IN METERS.
2. ONLY WRITER DIMENSIONS ARE TO BE FOLLOWED. DRAWING SHOULD NOT BE SCALED IN ANY MANNER.
3. ALL MEASUREMENTS MUST BE CHECKED AND VERIFIED BY THE CONTRACTORS PRIOR TO EXECUTION OF WORK AT THE SITE.
4. THE CONTRACTOR SHALL BE RESPONSIBLE FOR THE LOCATION OF ALL STRUCTURAL MEMBERS AND FACILITY PLANNING DRAWINGS.
5. THE CONTRACTOR SHALL BE RESPONSIBLE FOR THE LOCATION OF ALL STRUCTURAL MEMBERS AND FACILITY PLANNING DRAWINGS.
6. THE CONTRACTOR SHALL BE RESPONSIBLE FOR THE LOCATION OF ALL STRUCTURAL MEMBERS AND FACILITY PLANNING DRAWINGS.
7. THE CONTRACTOR SHALL BE RESPONSIBLE FOR THE LOCATION OF ALL STRUCTURAL MEMBERS AND FACILITY PLANNING DRAWINGS.
8. THE CONTRACTOR SHALL BE RESPONSIBLE FOR THE LOCATION OF ALL STRUCTURAL MEMBERS AND FACILITY PLANNING DRAWINGS.
9. FOR DETAILS, REFER RELEVANT LARGE SCALE DETAIL DRGS. AS INDICATED.