



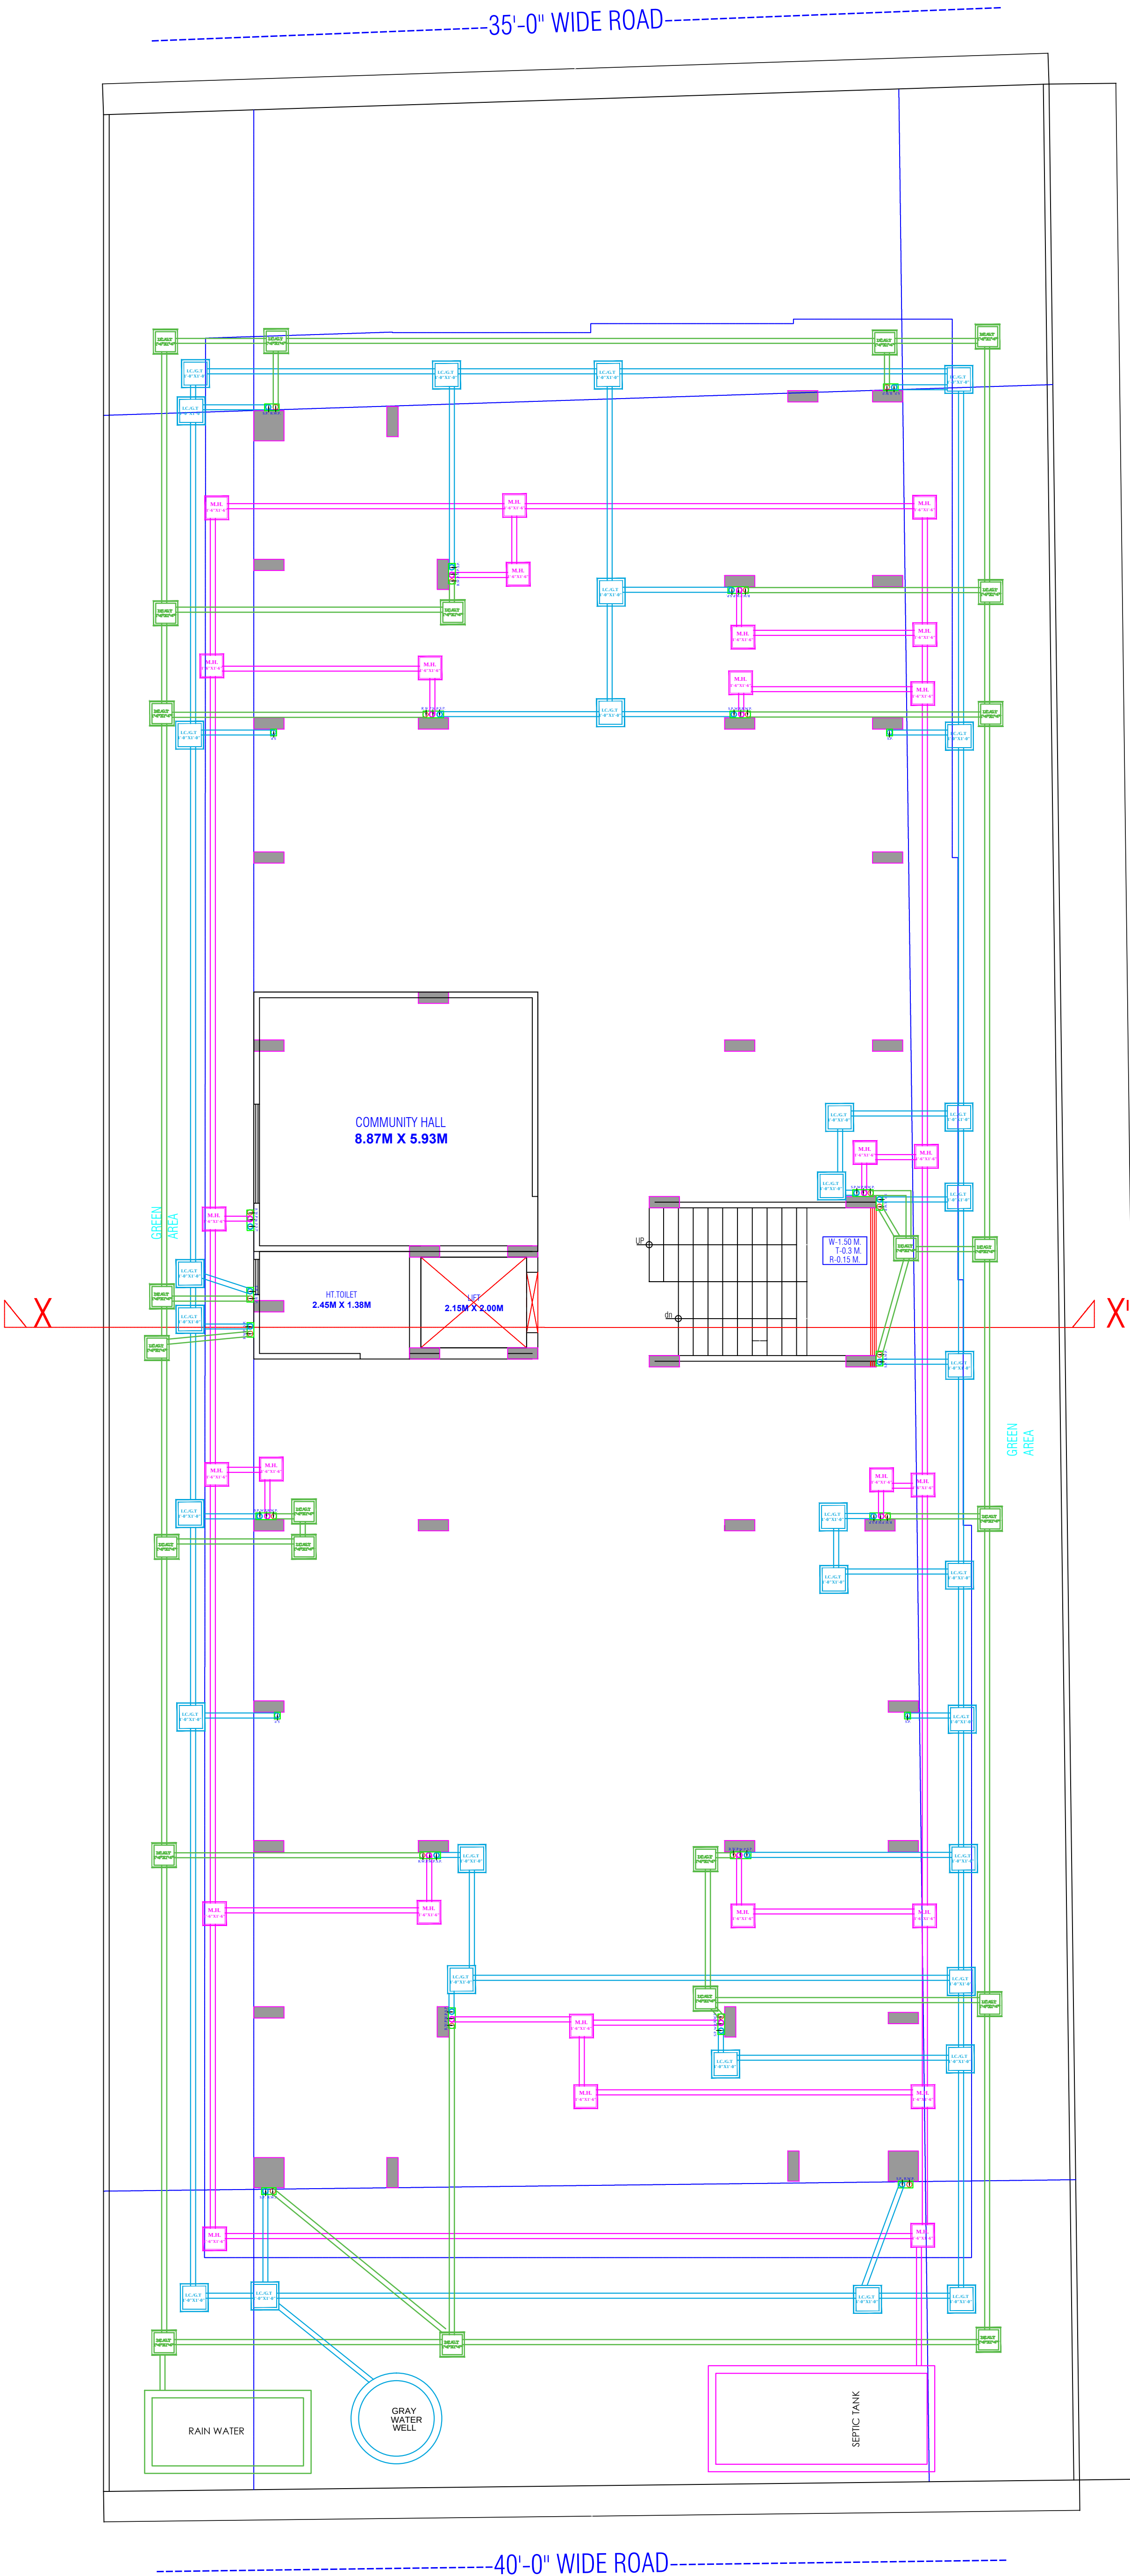

①	RAIN WATER PIPE		
②	WEST WATER PIPE		
③	SOIL WATER PIPE		
④	INSPECTION CHAMBER / GULLY TRAP		2'6" DEPTH
⑤	MAN HOLE		2'6" DEPTH
⑥	ELECTRICAL PIPELINE		

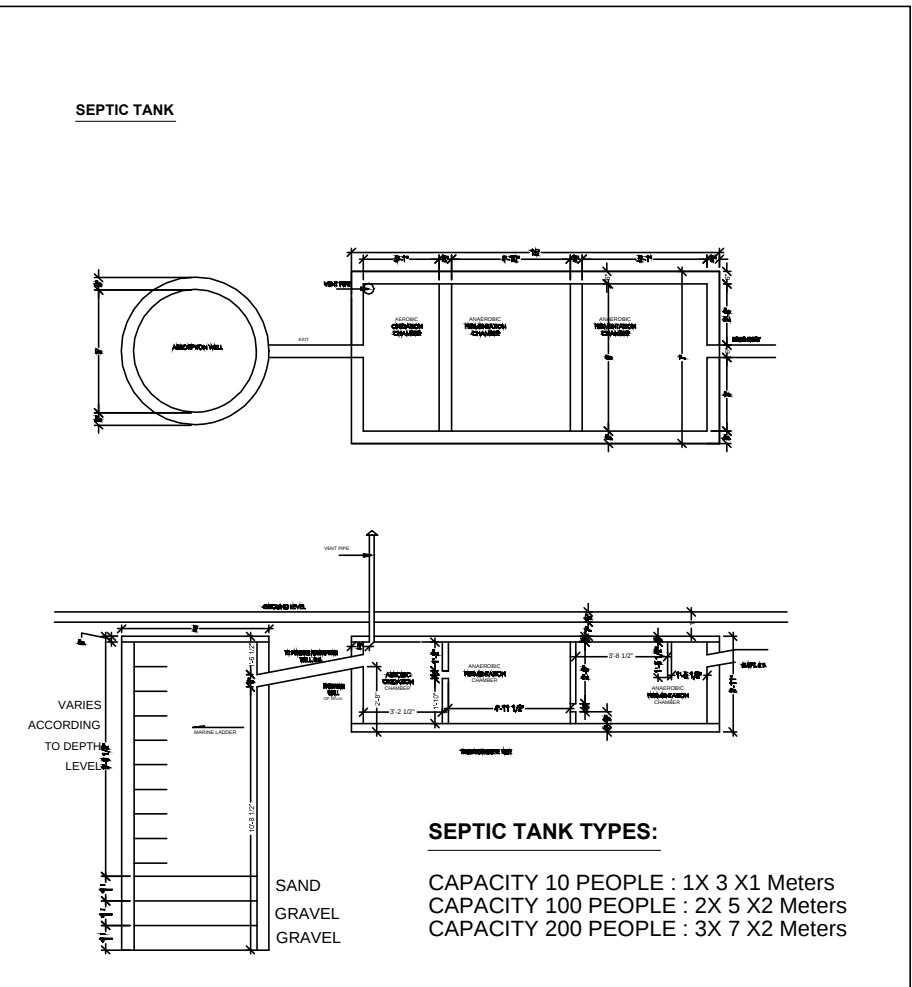

Dharmesh
DHARMESH SHARMA
B. TECH. (CIVIL)

WARNING

1. This drawing is the sole copyright of Architects **VISTAAR** and should be used for the purpose expressly issued.

GENERAL NOTES

1. All dimensions are in feets and inches.
2. Do not scale this drawing follow written dimensions only.
3. This drawing should be read in conjunction with other architectural and structural drawings.
4. Any discrepancy in the drawing should be immediately brought to the notice of architect.

PROJECT TITLE

Shree Krishna Residency
Plot No. 82,83,84 E.P. 93 E.P-A-W.P.99 W.P.99
E.P-A , Village - Manpur Devri Urf Golyawas ,
Scheme - Vrindavan Vihar , Jaipur - 302020
(Rajasthan)

DRAWING TITLE

COMMON AREA WATER SUPPLY
,SANITATION(STORM WATER DRAINAGE,
SEWERAGE,STP,SOLID WATER DISPOSAL) AND
RAIN WATER HARVESTING PLAN

ARCHITECTS :

VISTAAR ARCHITECTS & PLANNERS

Architects :: Interior Designers
B-2/12, Chitrkoot scheme,
main Gandhi Path,Opp mall of jaipur,Jaipur
PH.- 0141-4116461,09001010366

PATH :-

DRN.	DATE	REV.	NORTH
------	------	------	-------

MANOJ KUMAWAT


09-09-2022

SCALE

JOB NO.

N.T.S



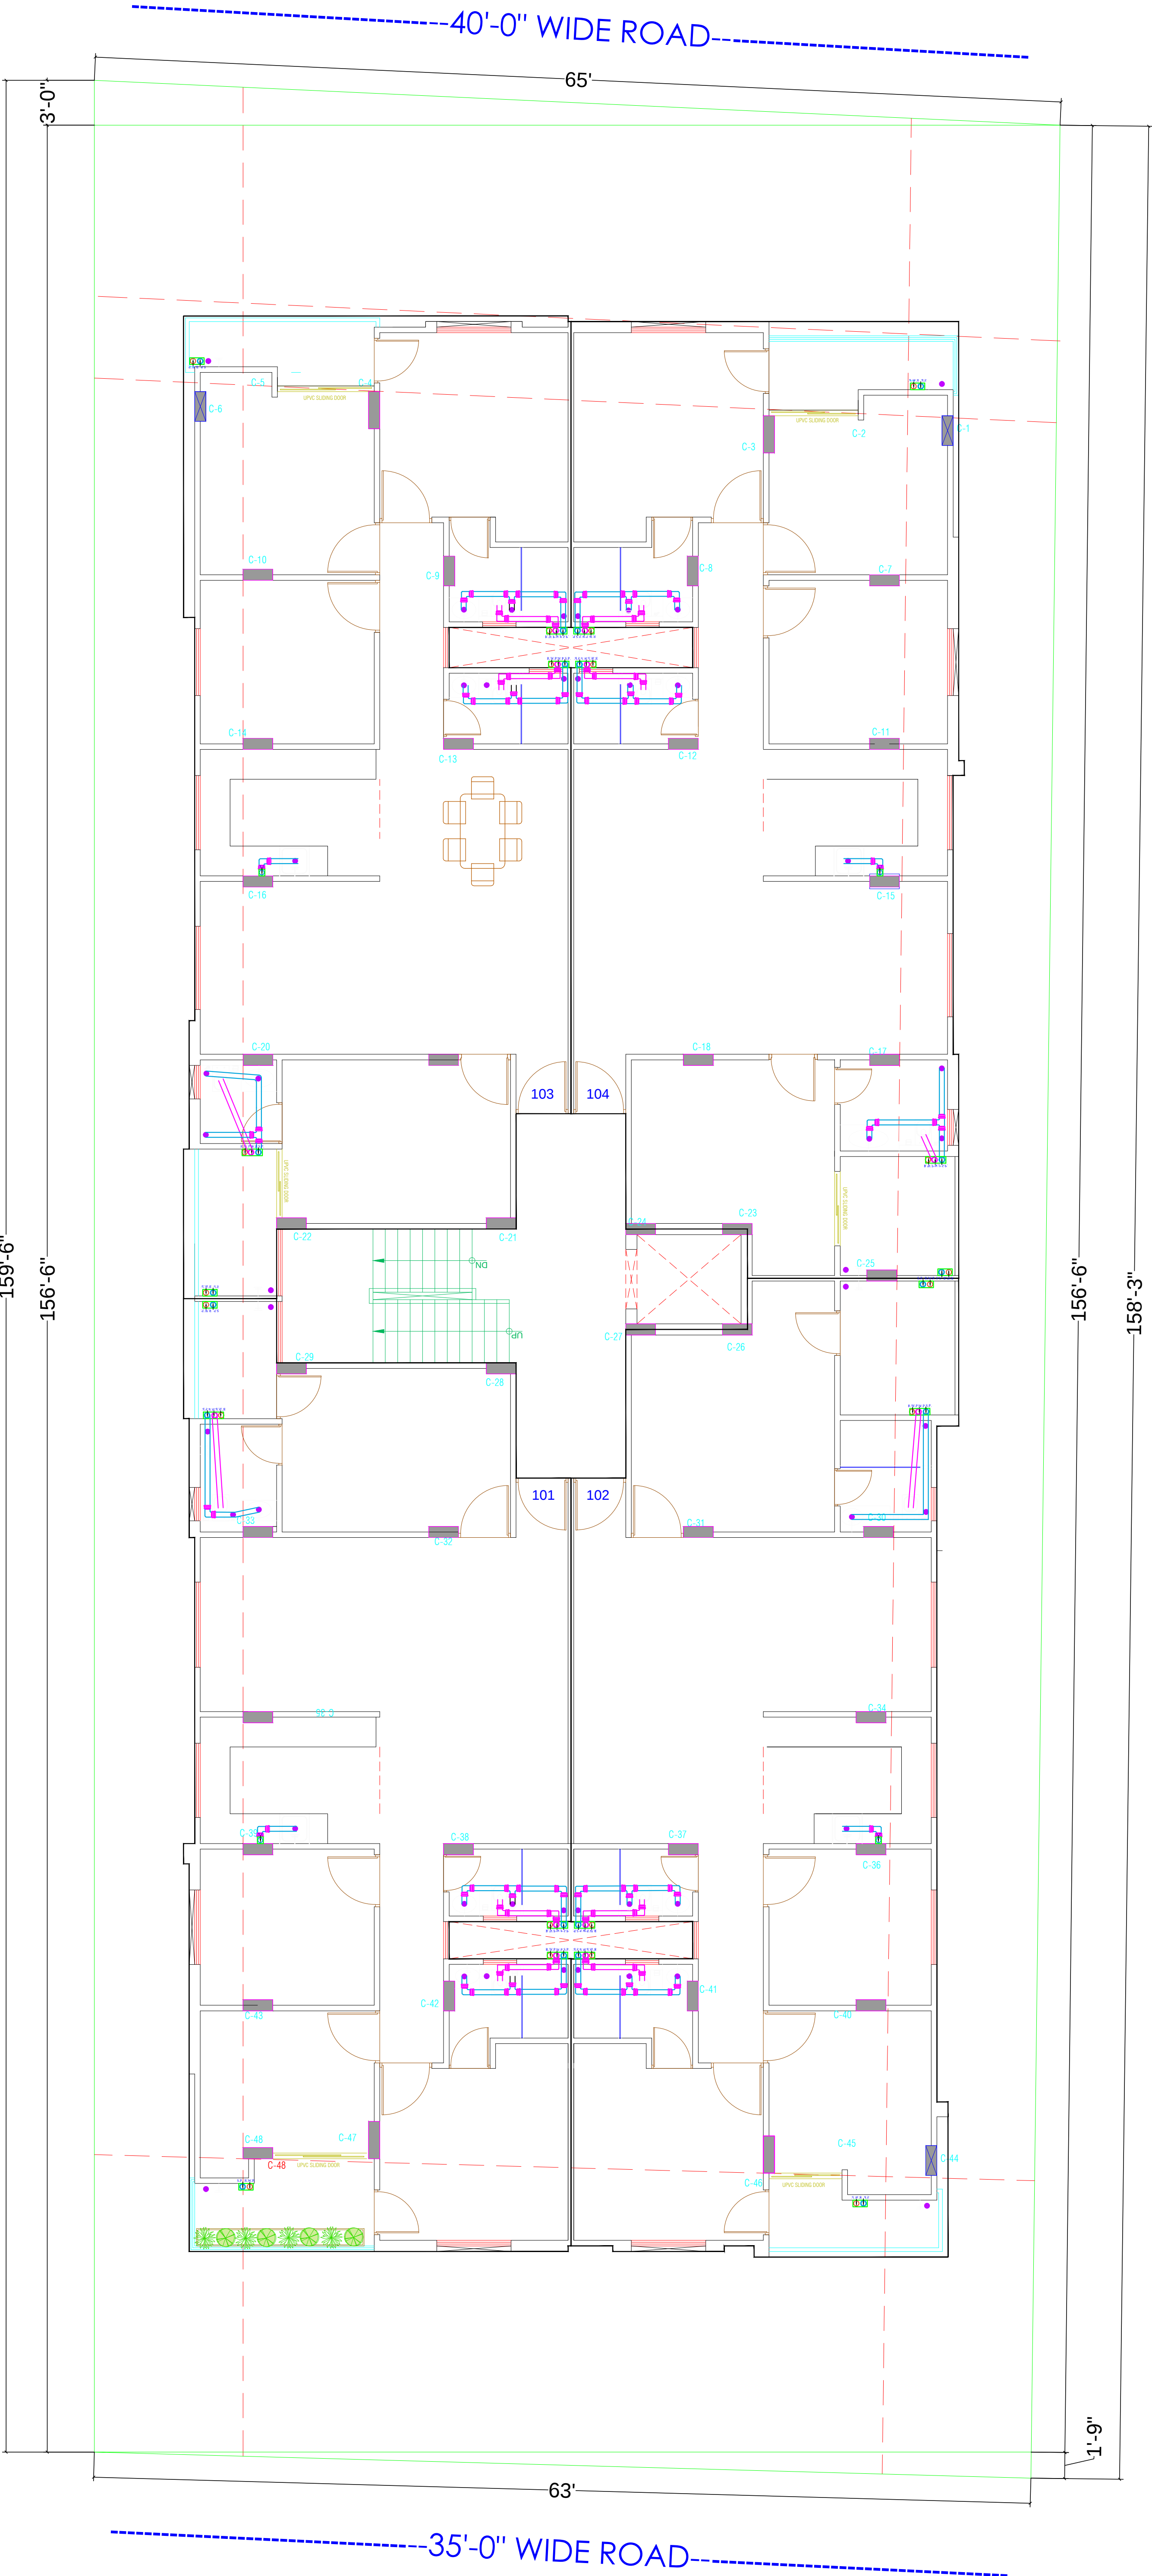

Dharmesh Sharma
DHARMESH SHARMA
B. TECH. (CIVIL)

WARNING

1. This drawing is the sole copyright of Architects **VISTAAR** and should be used for the purpose expressly issued.

GENERAL NOTES

1. All dimensions are in feets and inches.
2. Do not scale this drawing follow written dimensions only.
3. This drawing should be read in conjunction with other architectural and structural drawings.
4. Any discrepancy in the drawing should be immediately brought to the notice of architect.

PROJECT TITLE

Shree Krishna Residency
Plot No. 82,83,84 E.P, 93 E.P-A-W.P,99 W.P,99
E.P-A , Village - Manpur Devri Urf Golyawas ,
Scheme - Vrindavan Vihar , Jaipur - 302020
(Rajasthan)

DRAWING TITLE

TYPICAL FLOOR
DRAINAGE PLAN

ARCHITECTS :

VISTAAR ARCHITECTS & PLANNERS

Architects :: Interior Designers
B-2/12, Chitrkoot scheme,
main Gandhi Path,Opp mall of jaipur,Jaipur
PH.- 0141-4116461,09001010366

PATH :-

DRN.	DATE	REV.	NORTH
MANOJ KUMAWAT	09-09-2022		
SCALE	JOB NO.		
N.T.S			